


1 VOICE/DATA RISER

NO SCALE

2 "CTE" GROUNDING DETAIL

NTS

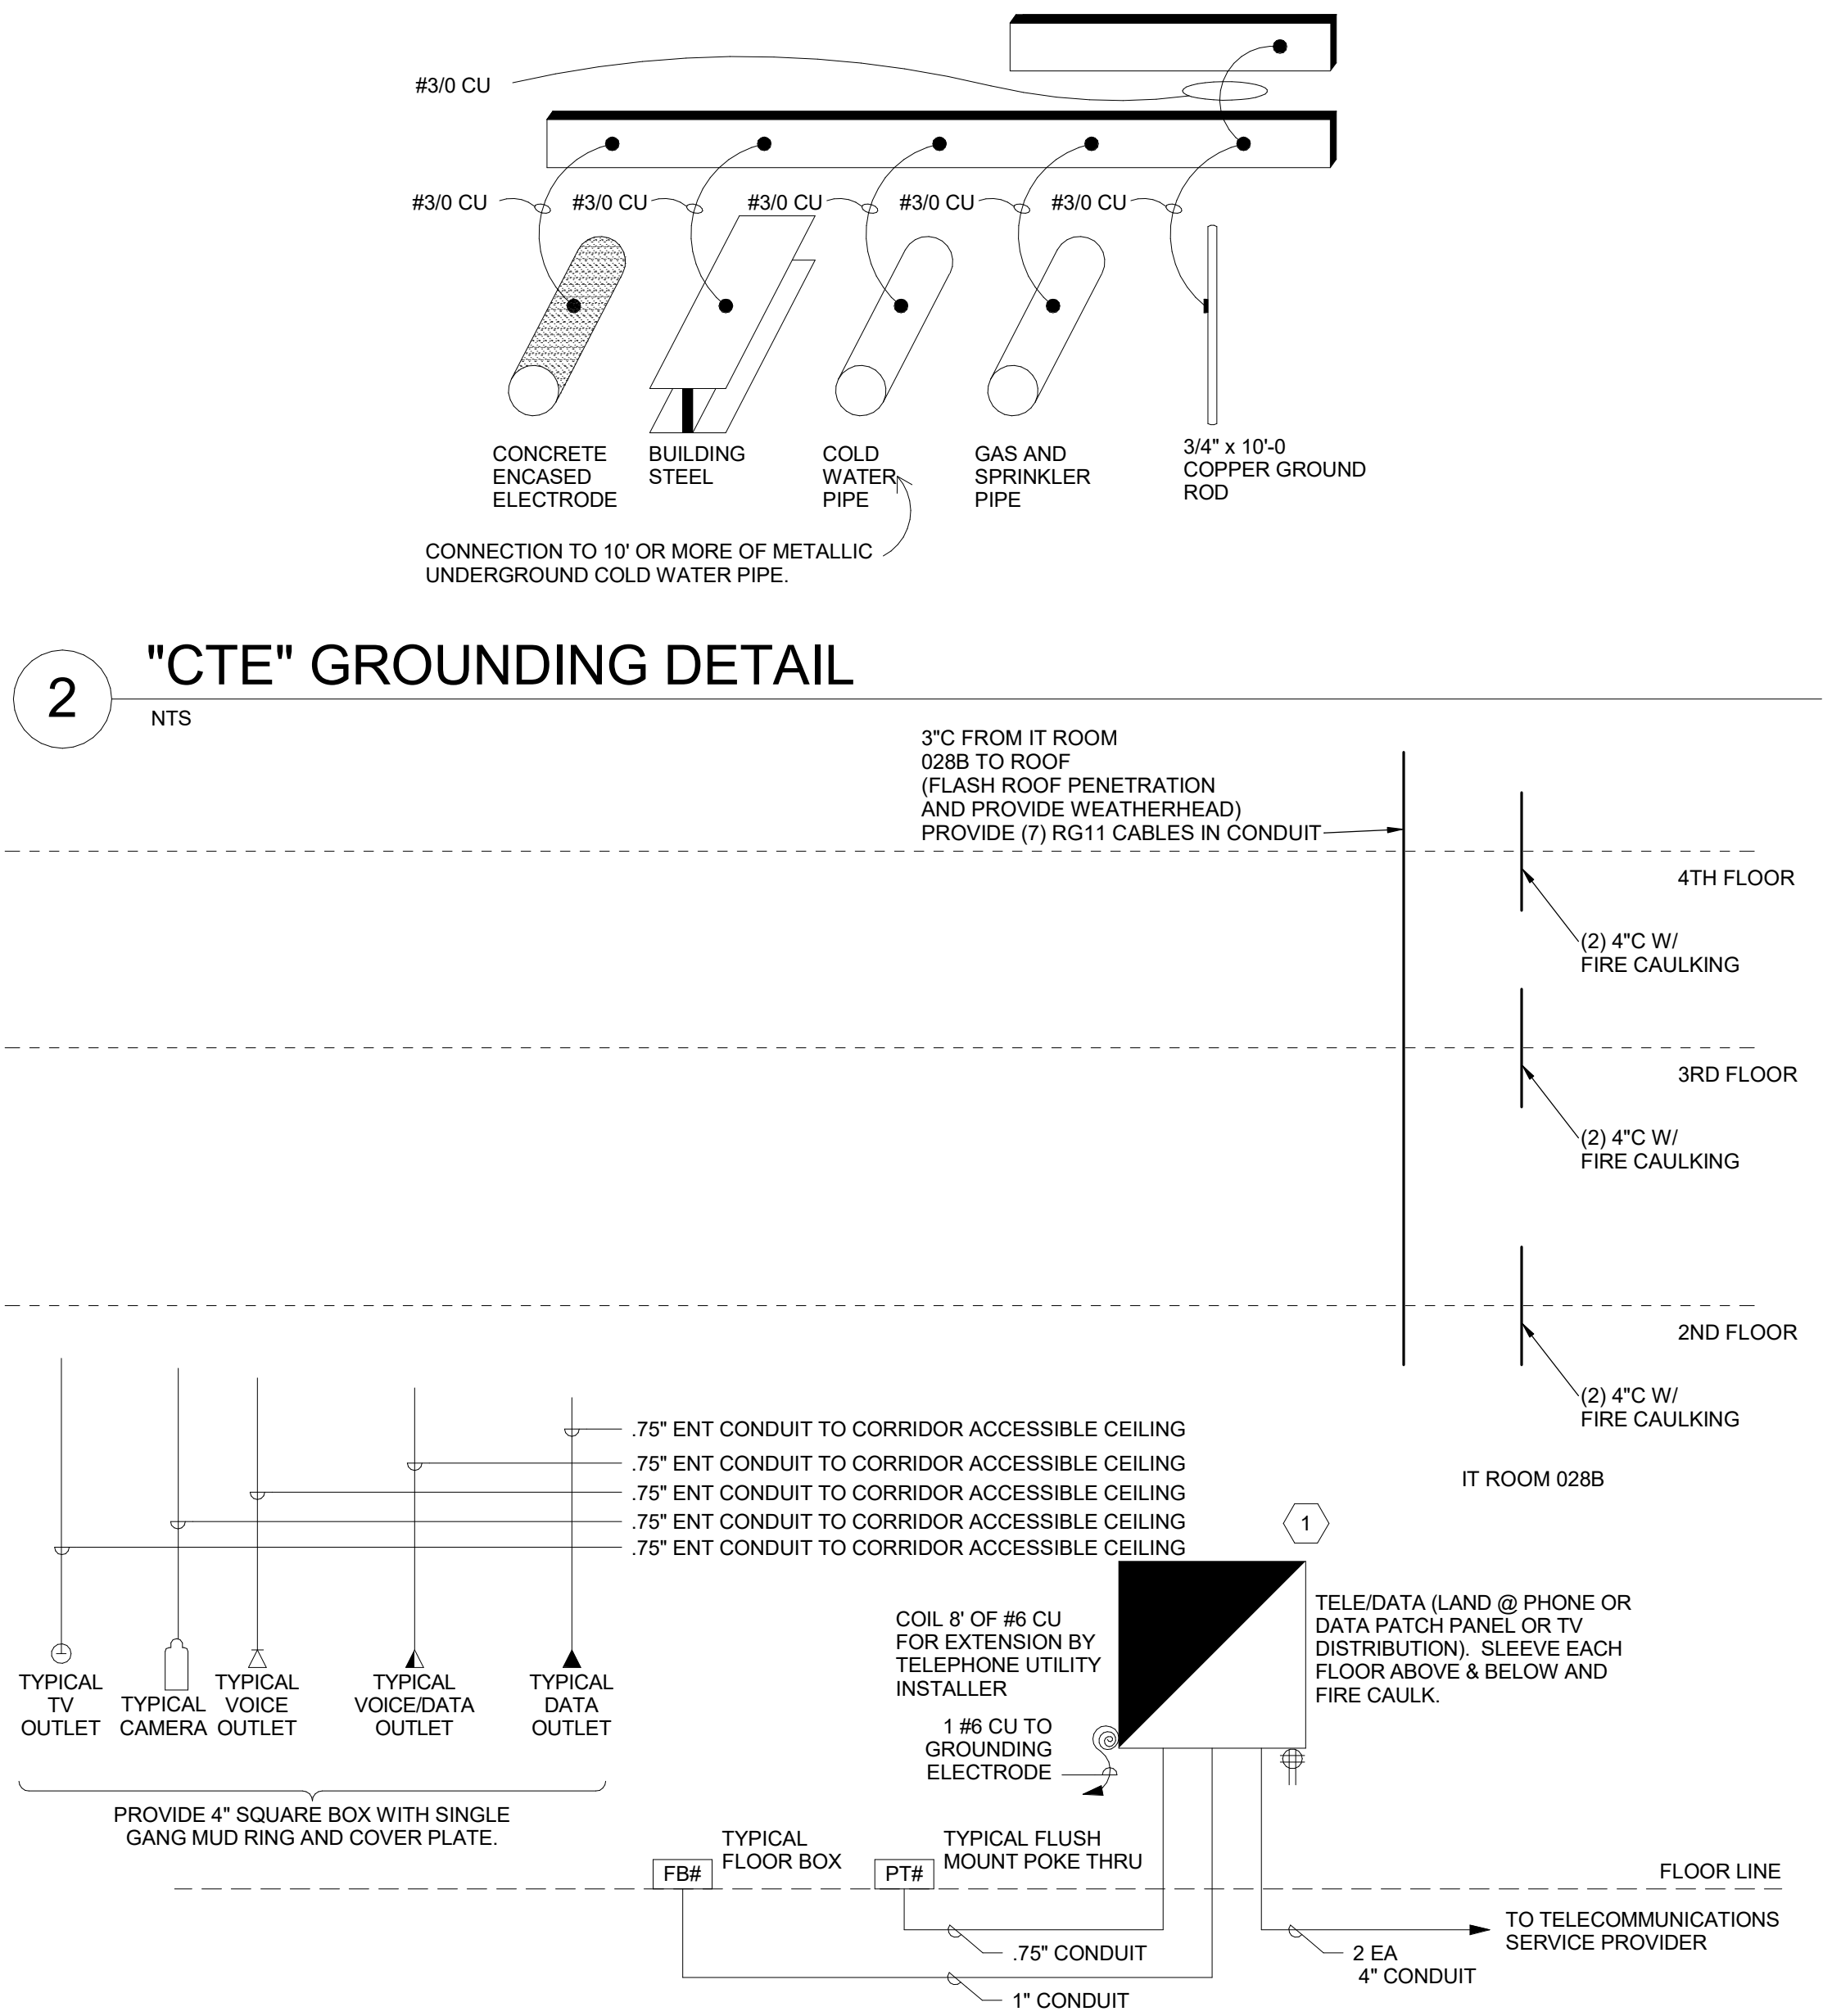

PERMIT SET

ELECTRICAL DETAILS

E501

CENTRAL PARK HOTEL

SERAC CAPITAL PARTNERS, LLC

5051 WESTEMER RD, SUITE 750
HOUSTON, TX 77066

1760 Central Park Dr.
Steamboat Springs, CO

#	ISSUE		DESCRIPTION
	DATE	PERMIT SET	
1	03/04/2024	PERMIT SET	
2			
3			
4			
5			
6			
7			
8			
9			
10			
11			
12			
13			
14			
15			
16			
17			
18			
19			
20			

PROJECT # 2103
DRAWN BY: R902H
CHECKED BY: DSH

SHEET #

OWNER:

CONSULTANT:

SPECTRUM
ENGINEERS
324 S. State St., Suite 400
Salt Lake City, UT 84111
801-678-7077
801-328-5151
fax: 801-328-5155
www.spectrum-engineers.com



THE
RICHARDSON
DESIGN
PARTNERSHIP,
L.L.C.
510 South 600 East
Salt Lake City, Utah 84102
P: 801.355.6886
F: 801.355.6880

PROVIDE HOMERUN FOR EACH PHONE, DATA, OR PHONE/DATA LOCATION SHOWN TO COMM ROOM "PBX" UNLESS OTHERWISE NOTED ON PLANS.

SHEET KEYNOTES