


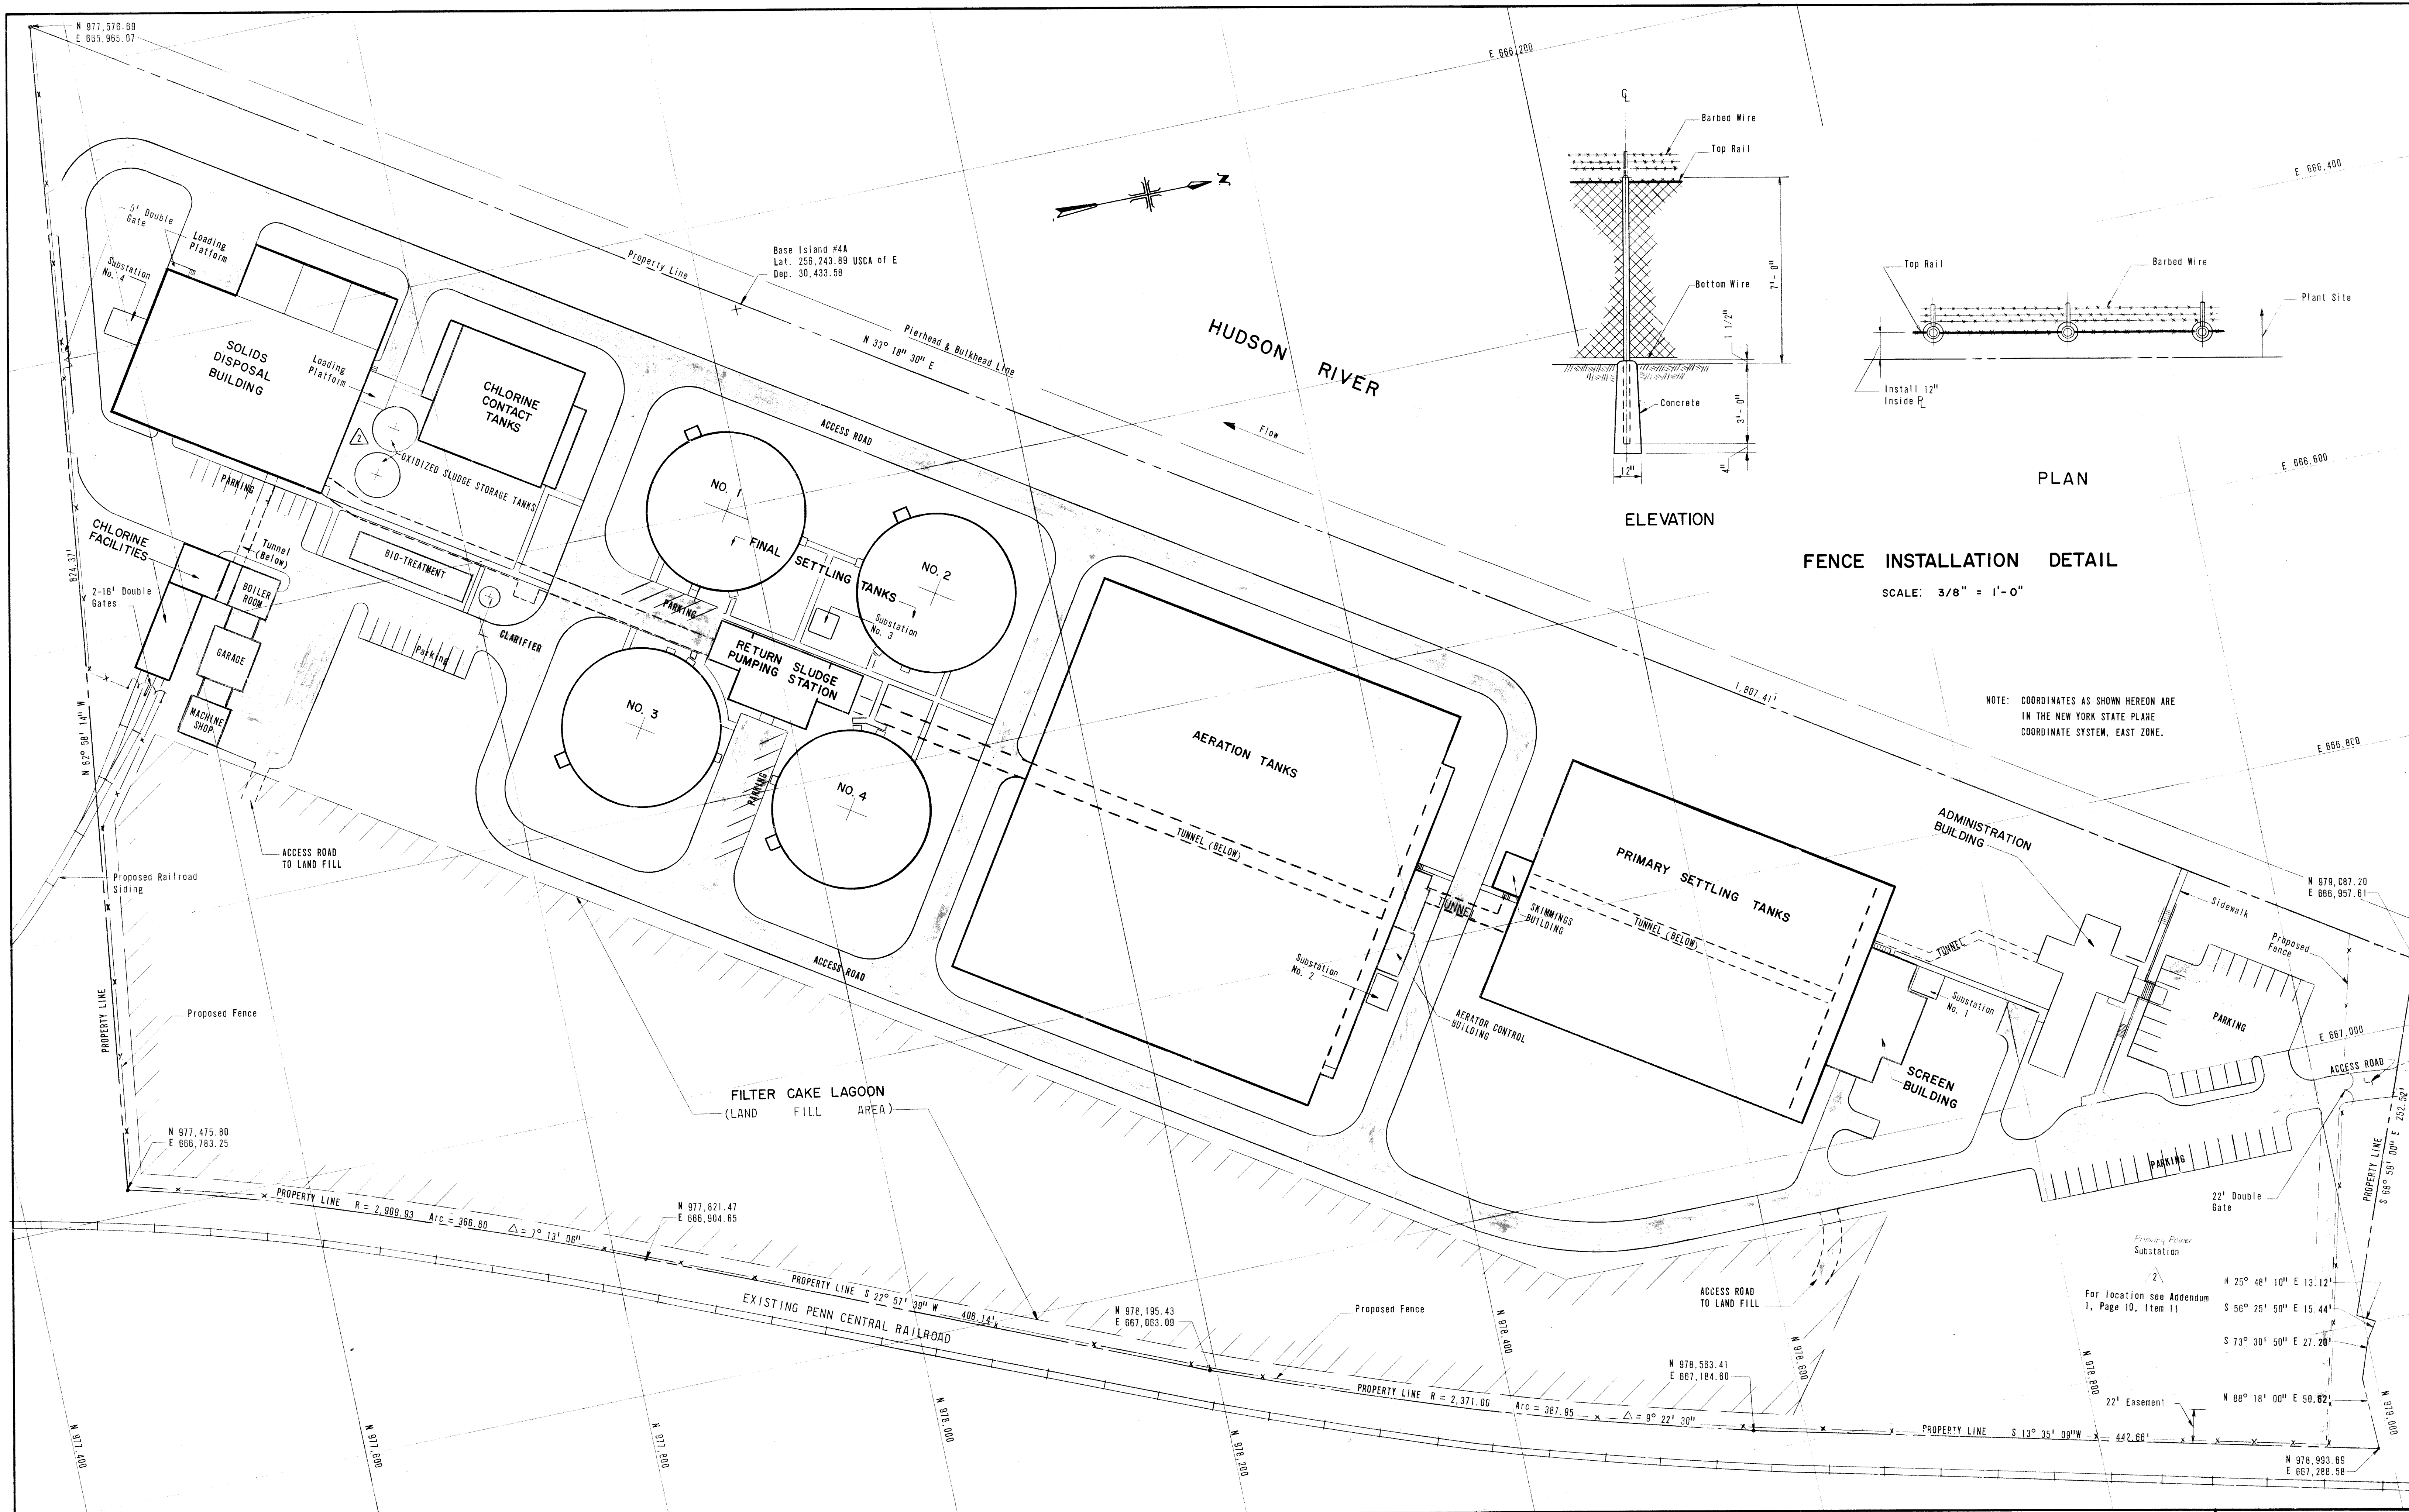

**MALCOLM
PIRNE,
INC.**

Robert C. Parnell

DESIGNED *JCM* DRAWN *FM* CHECKED *VB*
REVISIONS: Δ Bid Copy Δ April 18, 1973

**RENSSELAER COUNTY SEWER DISTRICT NO. 1
RENSSELAER COUNTY, NEW YORK
WASTEWATER TREATMENT FACILITIES**

CONTRACT NO. 1 GENERAL CONSTRUCTION

SITE PLAN

SCALE: 1" = 50'-0"

DATE: MARCH, 1973

C/S SHEET 1 OF 105

DWG. NO. 181 N-71.001-2