

DRAWING LIST	
SHEET NUMBER	SHEET NAME
A-800	ABBREVIATIONS, NOTES, & SYMBOLS
A-801-A	1ST FLOOR TEL/DATA PLAN - PART A
A-801-B	1ST FLOOR TEL/DATA PLAN - PART B
A-801-C	1ST FLOOR TEL/DATA PLAN - PART C
A-801-D	1ST FLOOR TEL/DATA PLAN - PART D
A-802-A	2ND FLOOR TEL/DATA PLAN - PART A
A-802-B	2ND FLOOR TEL/DATA PLAN - PART B
A-803	SERVER ROOM SCHEDULE

TEL/DATA PLAN GENERAL NOTES

1. ELECTRICAL ITEMS AND INFORMATION SHOWN ON THIS PLAN ARE FOR GENERAL REFERENCE AND COORDINATION ONLY. REFER TO ENGINEERED ELECTRICAL PLANS FOR SPECIFIC ELECTRICAL INFORMATION, INCLUDING TYPICAL MOUNTING HEIGHTS.

2. THE CONTRACT DOCUMENTS ARE COMPLIMENTARY TO EACH OTHER. WHAT IS REQUIRED FOR ONE DRAWING SHALL BE AS BINDING AS IF REQUIRED FOR ALL.

3. DO NOT SCALE DRAWINGS. CONTRACTOR SHALL FIELD VERIFY DIMENSIONS.

4. THIS PLAN SHALL BE USED FOR POWER, VOICE AND DATA LOCATIONS ONLY. REFER TO ELECTRICAL ENGINEERING DRAWINGS FOR CIRCUITING AND FIRE ALARM DETECTION DEVICES.

5. DIMENSIONS SHOWN ON PLAN FOR FLOOR-MOUNTED AND WALL-MOUNTED SYSTEMS
FURNITURE FEEDS AND CONFERENCE ROOM FLOOR-MOUNTS ARE TO CENTERLINE OF
ONE CORE OR JUNCTION BOX. TYPICAL DISTANCE BETWEEN ADJACENT POWER, VOICE OR
DATA OUTLETS SHALL NOT EXCEED 6", UNLESS OTHERWISE NOTED.

6. SECURITY EQUIPMENT, TELEPHONE AND DATA EQUIPMENT AND AV EQUIPMENT ARE TENANT FURNISHED, AND INSTALLED BY THE TENANT'S CONTRACTOR/CONSULTANT. THE GENERAL CONTRACTOR SHALL COORDINATE INSTALLATION WITH OWNER AND CONTRACTOR/CONSULTANTS AND WITH STATION CABLEING & COMMUNICATION SCOPE OF WORK. INDIVIDUAL FLOOR RECEPTACLES ARE DIMENSIONED TO CENTER LINE OF DEVICE, U.O.N.

7. FLOOR CORES ARE PERMISSIBLE UNLESS SPECIFICALLY NOTED IN THE DRAWINGS, COORDINATE ALL LOCATIONS WITH CONTRACTING OFFICER.

8. MOUNT ALL OUTLETS 18" ON CENTER ABOVE FINISHED FLOOR, U.O.N.

9. OUTLETS SHOWN BACK TO BACK SHALL BE STAGGERED.

10. WALL MOUNTED SYSTEMS FURNITURE BASE FEEDS AND VOICE/DATA INFEEDS SHALL BE MOUNTED AT 7" AFF.

11. EACH CLUSTER OF WORKSTATIONS OR SINGLE WORKSTATION SHALL INCLUDE: POWER INFEED AND SEPARATE VOICE/DATA INFEED. CONTRACTOR SHALL COORDINATE EXACT LOCATION OF OUTLETS WITH ARCHITECT FOR SYSTEM FURNITURE LOCATIONS AND MILLWORK.

12. POWER AND DATA/VOICE CABLING SHALL ALWAYS BE RUN SEPARATE FROM ONE ANOTHER TO ELIMINATE INTERFERENCE.

13. PLATES, DEVICES AND RECEPTACLES TO BE SELECTED BY CONTRACTING OFFICER.

ELECTRICAL SYMBOLS

NOTE: GENERIC DEVICE SYMBOLS SHOWN BELOW- SEE ELECTRICAL DRAWINGS FOR SPECIFIC DESCRIPTIONS AND ADDITIONAL ITEMS NOT SHOWN.

 DUPLEX RECEPTACLE, MOUNTED 18" AFF

 DUPLEX RECEPTACLE, MOUNTED 42" AFF OR 6" ABOVE COUNTERTOP

 QUAD RECEPTACLE, MOUNTED 18" AFF UNLESS OTHERWISE INDICATED

▶ TEL/DATA WALL OUTLET, MOUNTED 18" AFF UNLESS OTHERWISE INDICATED

▷ DATA WALL OUTLET, MOUNTED 18" AFF UNLESS OTHERWISE INDICATED

 FLOOR OUTLET BOX WITH DUPLEX RECEPTACLE

 FLOOR OUTLET BOX WITH QUAD RECEPTACLE

 FLOOR OUTLET BOX WITH TEL/DATA OUTLET

 FLOOR OUTLET BOX WITH TEL/DATA FEED

 POWER POLE

① JUNCTION BOX

[illegible]

DESIGNED BY:	DATE:
DRAWN BY: CKD BY:	06/24/2022
SUBMITTED BY:	SOLICITATION NO.:
SCALE:	CONTRACT NO.:
As indicated	MXRD 21-0004
SIZE:	OP NO.:
ANSI D	

DEPARTMENT OF THE AIR FORCE
**AIR FORCE MATERIEL
COMMAND**
66th AIR BASE GROUP/CECE
BASE CIVIL ENGINEER
DIVISION
HANSCOM AFB, MA 01731

REPAIR AFLCMC ACQ FAC, B1614


B1614
A-800

D

C

B

A

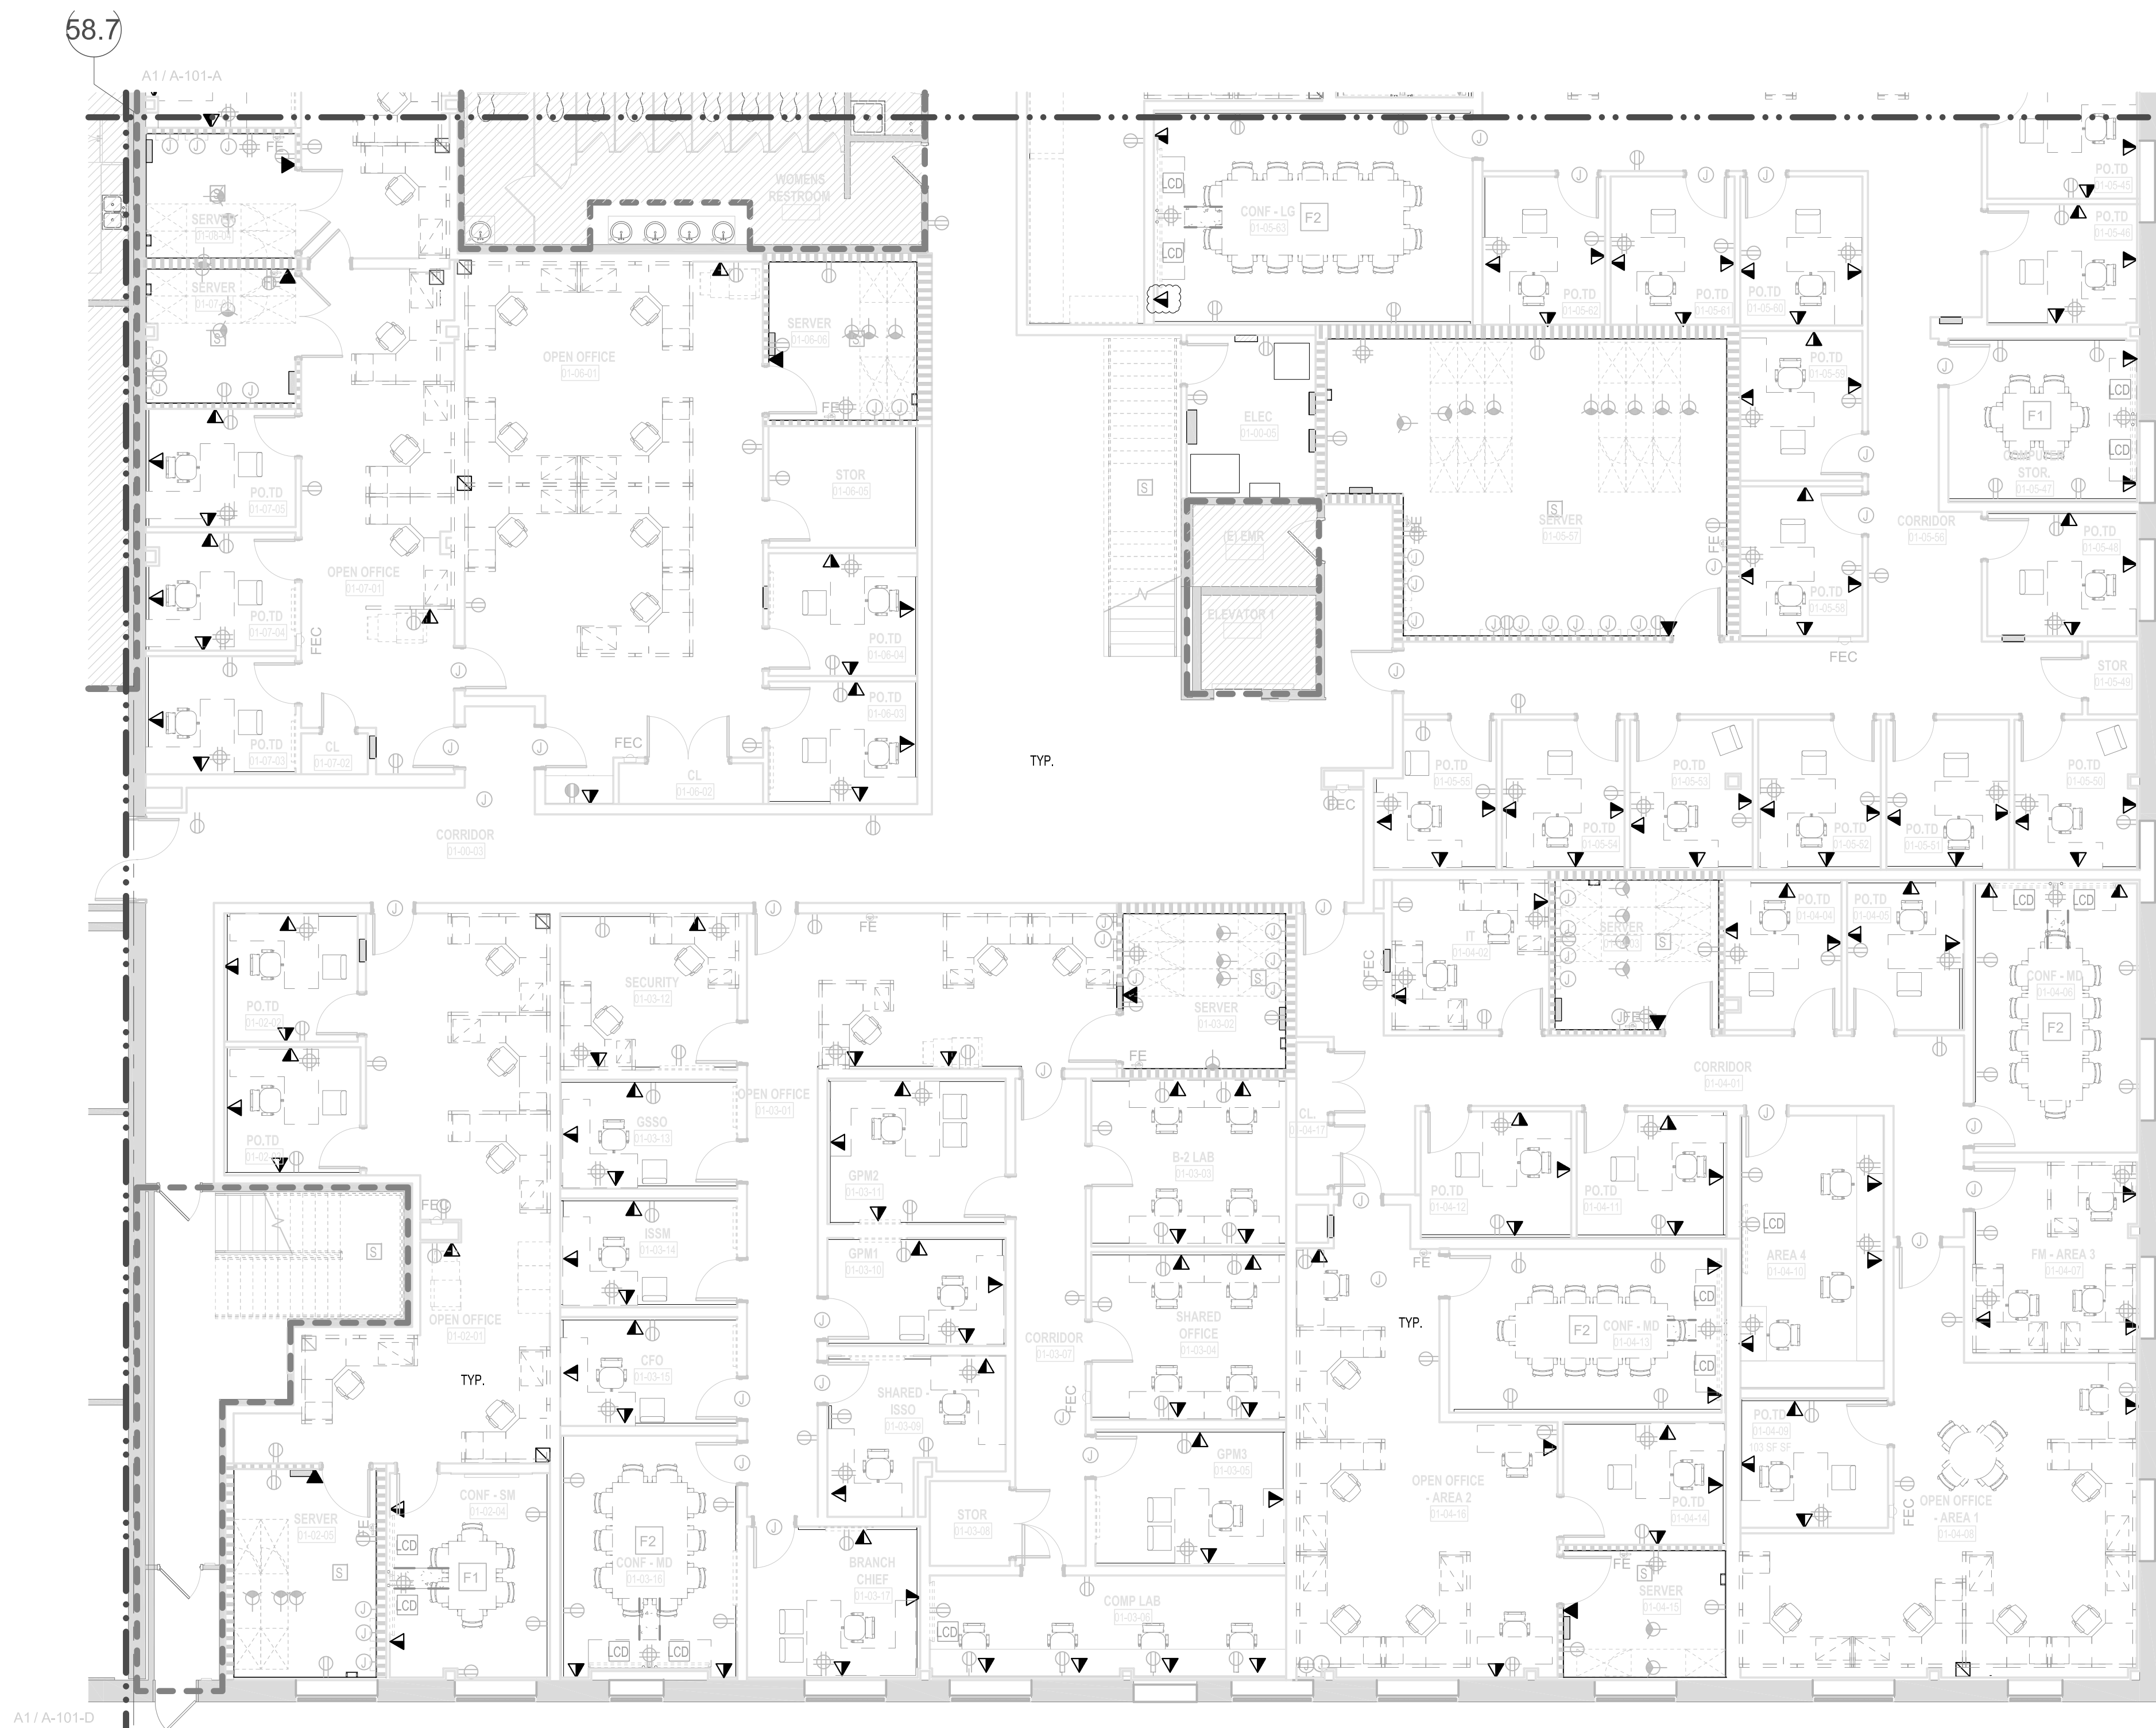

A1 1ST FLOOR TEL/DATA PLAN - PART B
SCALE: 1/8" = 1'-0"

LEGEND

DATA DROP LOCATION

GENERAL NOTES:
1. SPECIFIC DATA DROP LOCATIONS ARE NOT SHOWN FOR WORKSTATIONS. CABLING CONTRACTOR TO DETERMINE OPTIMAL PATHWAY.

[illegible]

DESIGNED BY:	DATE:
DRAWN BY: CKD BY:	08/30/2023
SUBMITTED BY:	SOLICITATION NO.:
SCALE:	CONTRACT NO.:
1/8" = 1'-0"	MXRD 21-0004
SIZE:	PLOT DATE: OP NO.:
ANSI D	

DEPARTMENT OF THE AIR FORCE

**AIR FORCE MATERIEL
COMMAND**


68TH AIR BASE GROUP/CECE
BASE CIVIL ENGINEER
DIVISION
HANSCOM AFB, MA 01731

REPAIR AFLCMC ACQ FAC, B1614

**1ST FLOOR
TEL/DATA PLAN -
PART B**

B1614
-801-B

ISSUE FOR BID

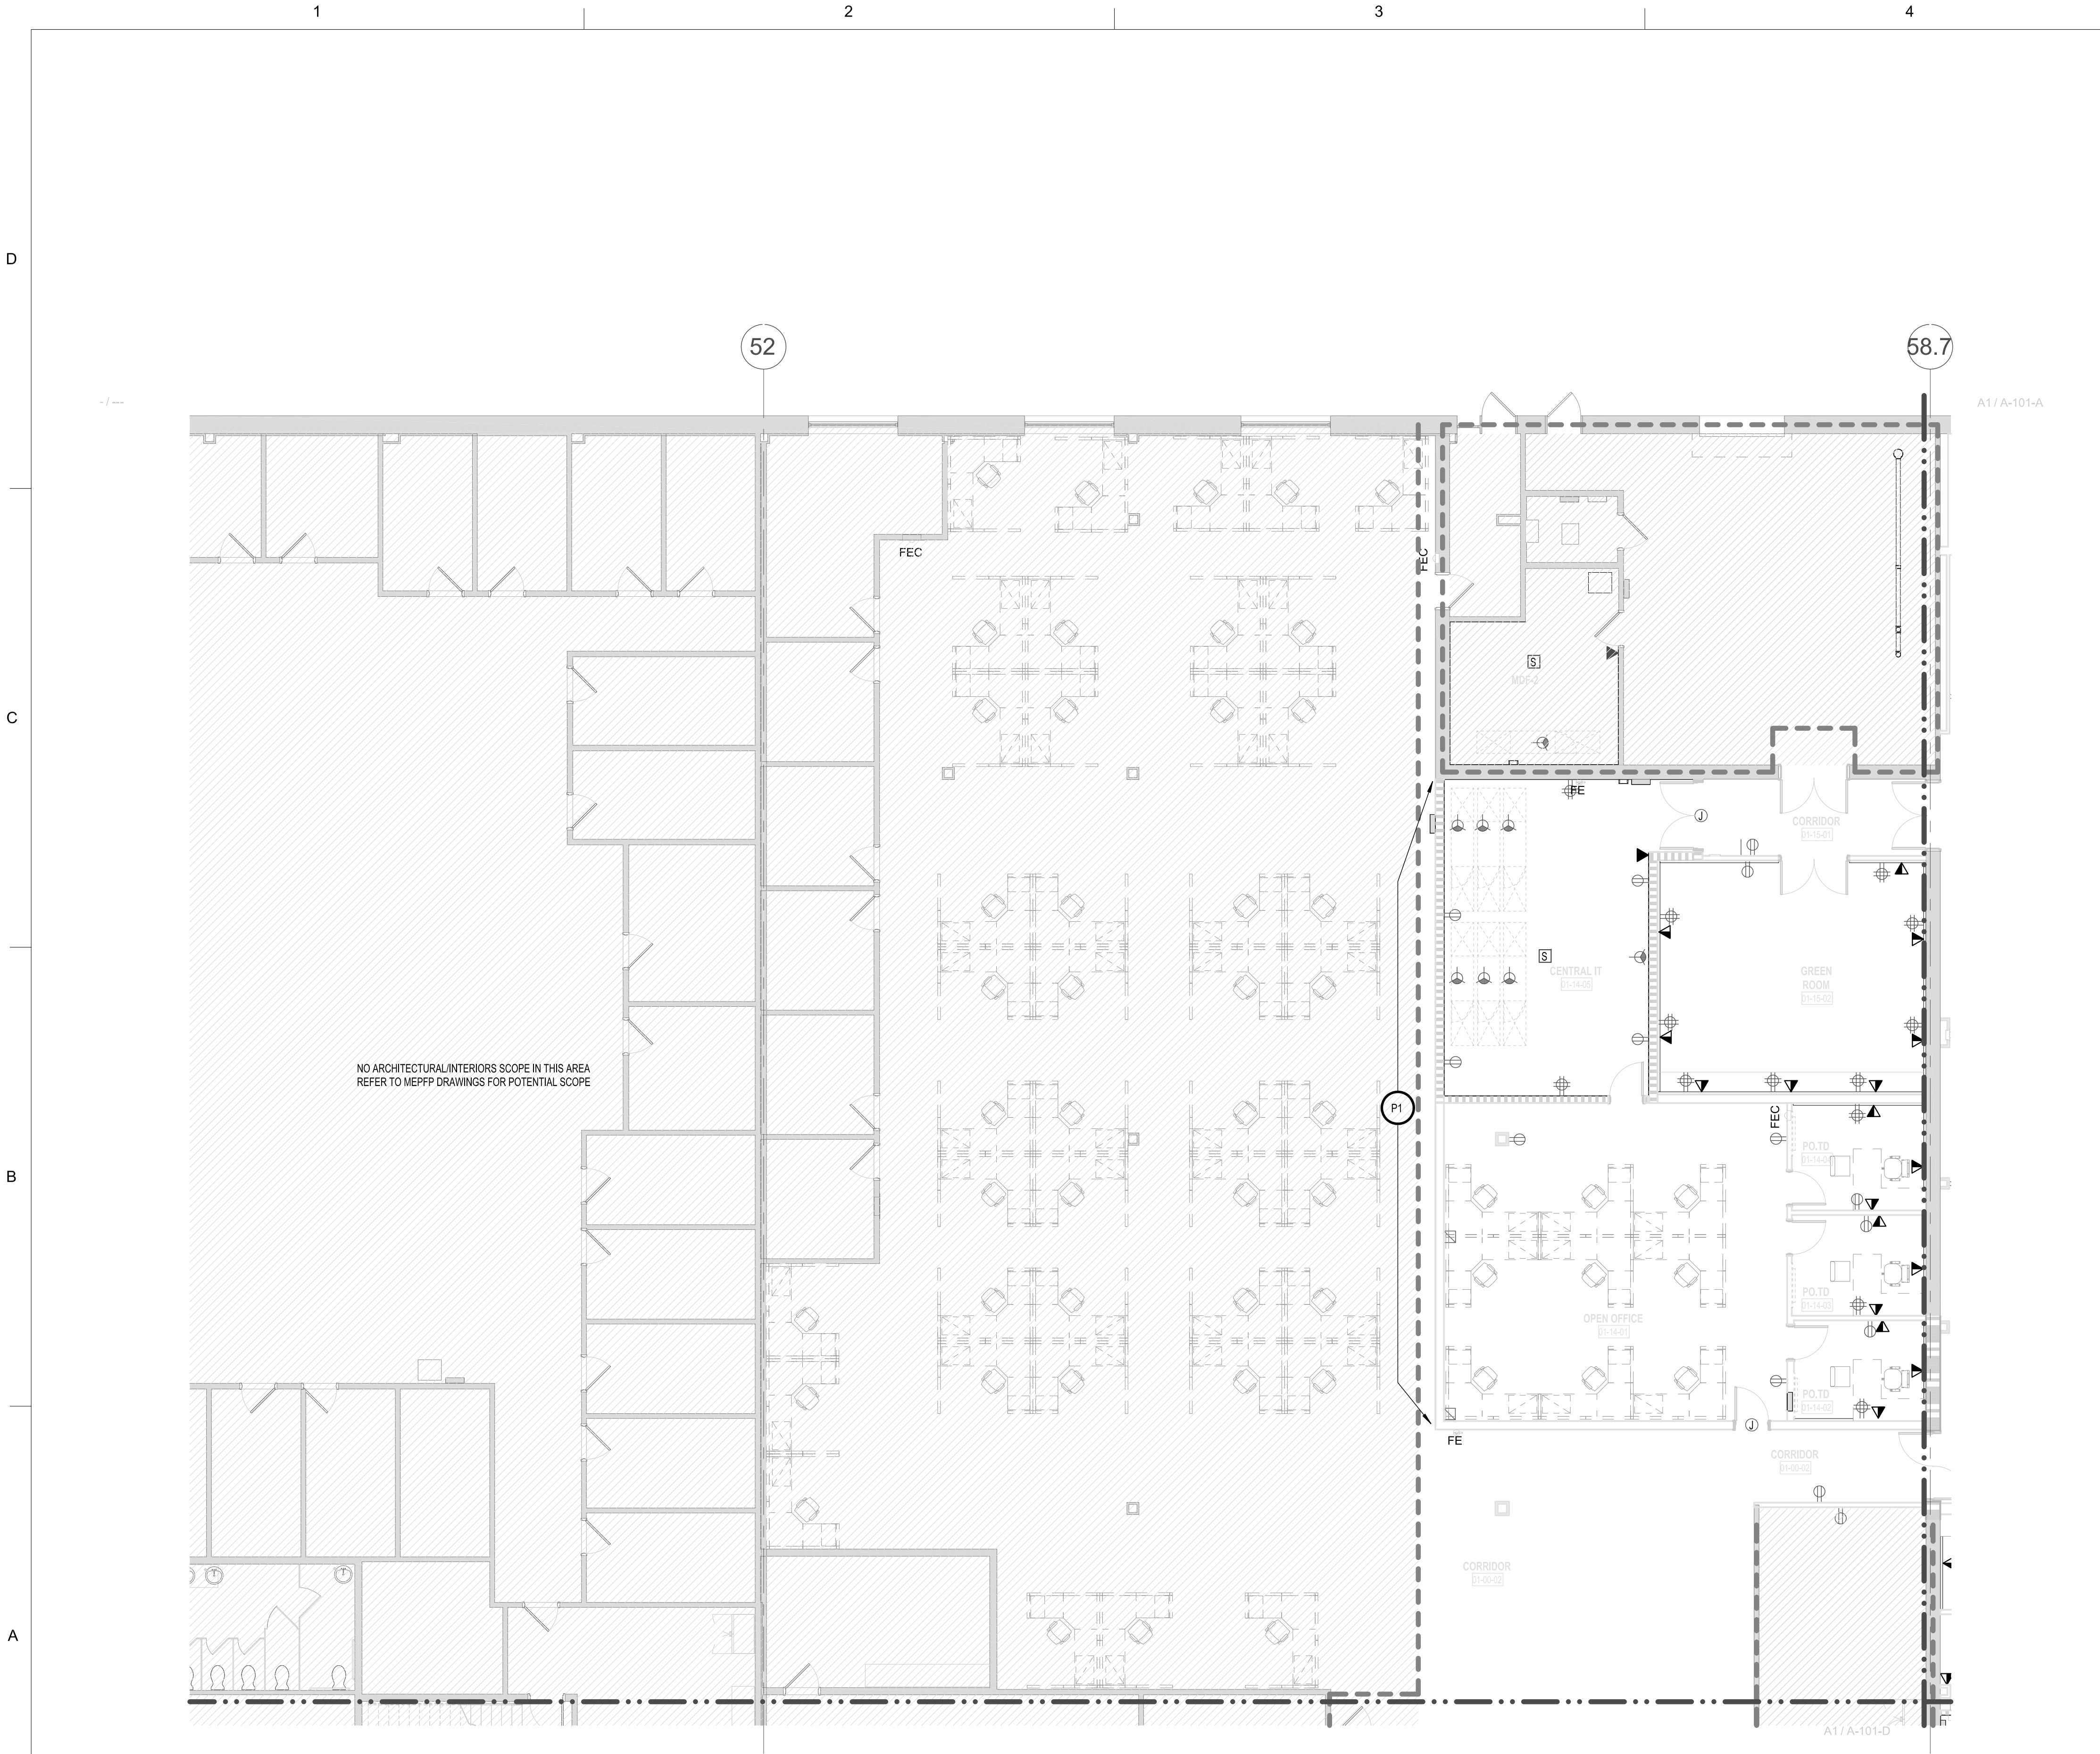


LEGEND

DATA DROP LOCATION



GENERAL NOTES:
1. SPECIFIC DATA DROP LOCATIONS ARE NOT SHOWN FOR WORKSTATIONS. CABLING CONTRACTOR TO DETERMINE OPTIMAL PATHWAY.

A1 1ST FLOOR TEL/DATA PLAN - PART C
SCALE: 1/8" = 1'-0"

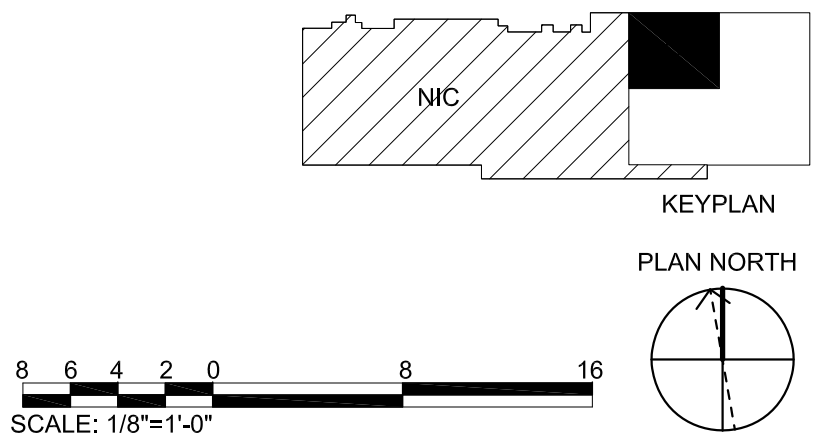



DESIGNED BY:	DATE:	SOLICITATION NO.:	APPR.
DRAWN BY: CKD BY:	08/30/2023		
SUBMITTED BY:		CONTRACT NO.:	
SCALE:	PLOT DATE:	CONTRACT NO.:	
1/8" = 1'-0"	OP NO.:	MAXD 21-0004	
SIZE:			
ANSI D			

DEPARTMENT OF THE AIR FORCE
**AIR FORCE MATERIEL
COMMAND**
68th AIR BASE GROUP/CECE
BASE CIVIL ENGINEER
HANSCOM AFB, MA 01731

REPAIR AFLCMC ACQ FAC, B1614
**1ST FLOOR
FURN, POWER &
TEL/DATA PLAN -
PART C**

B1614
A-801-C


ISSUE FOR BID

D

C

B

A

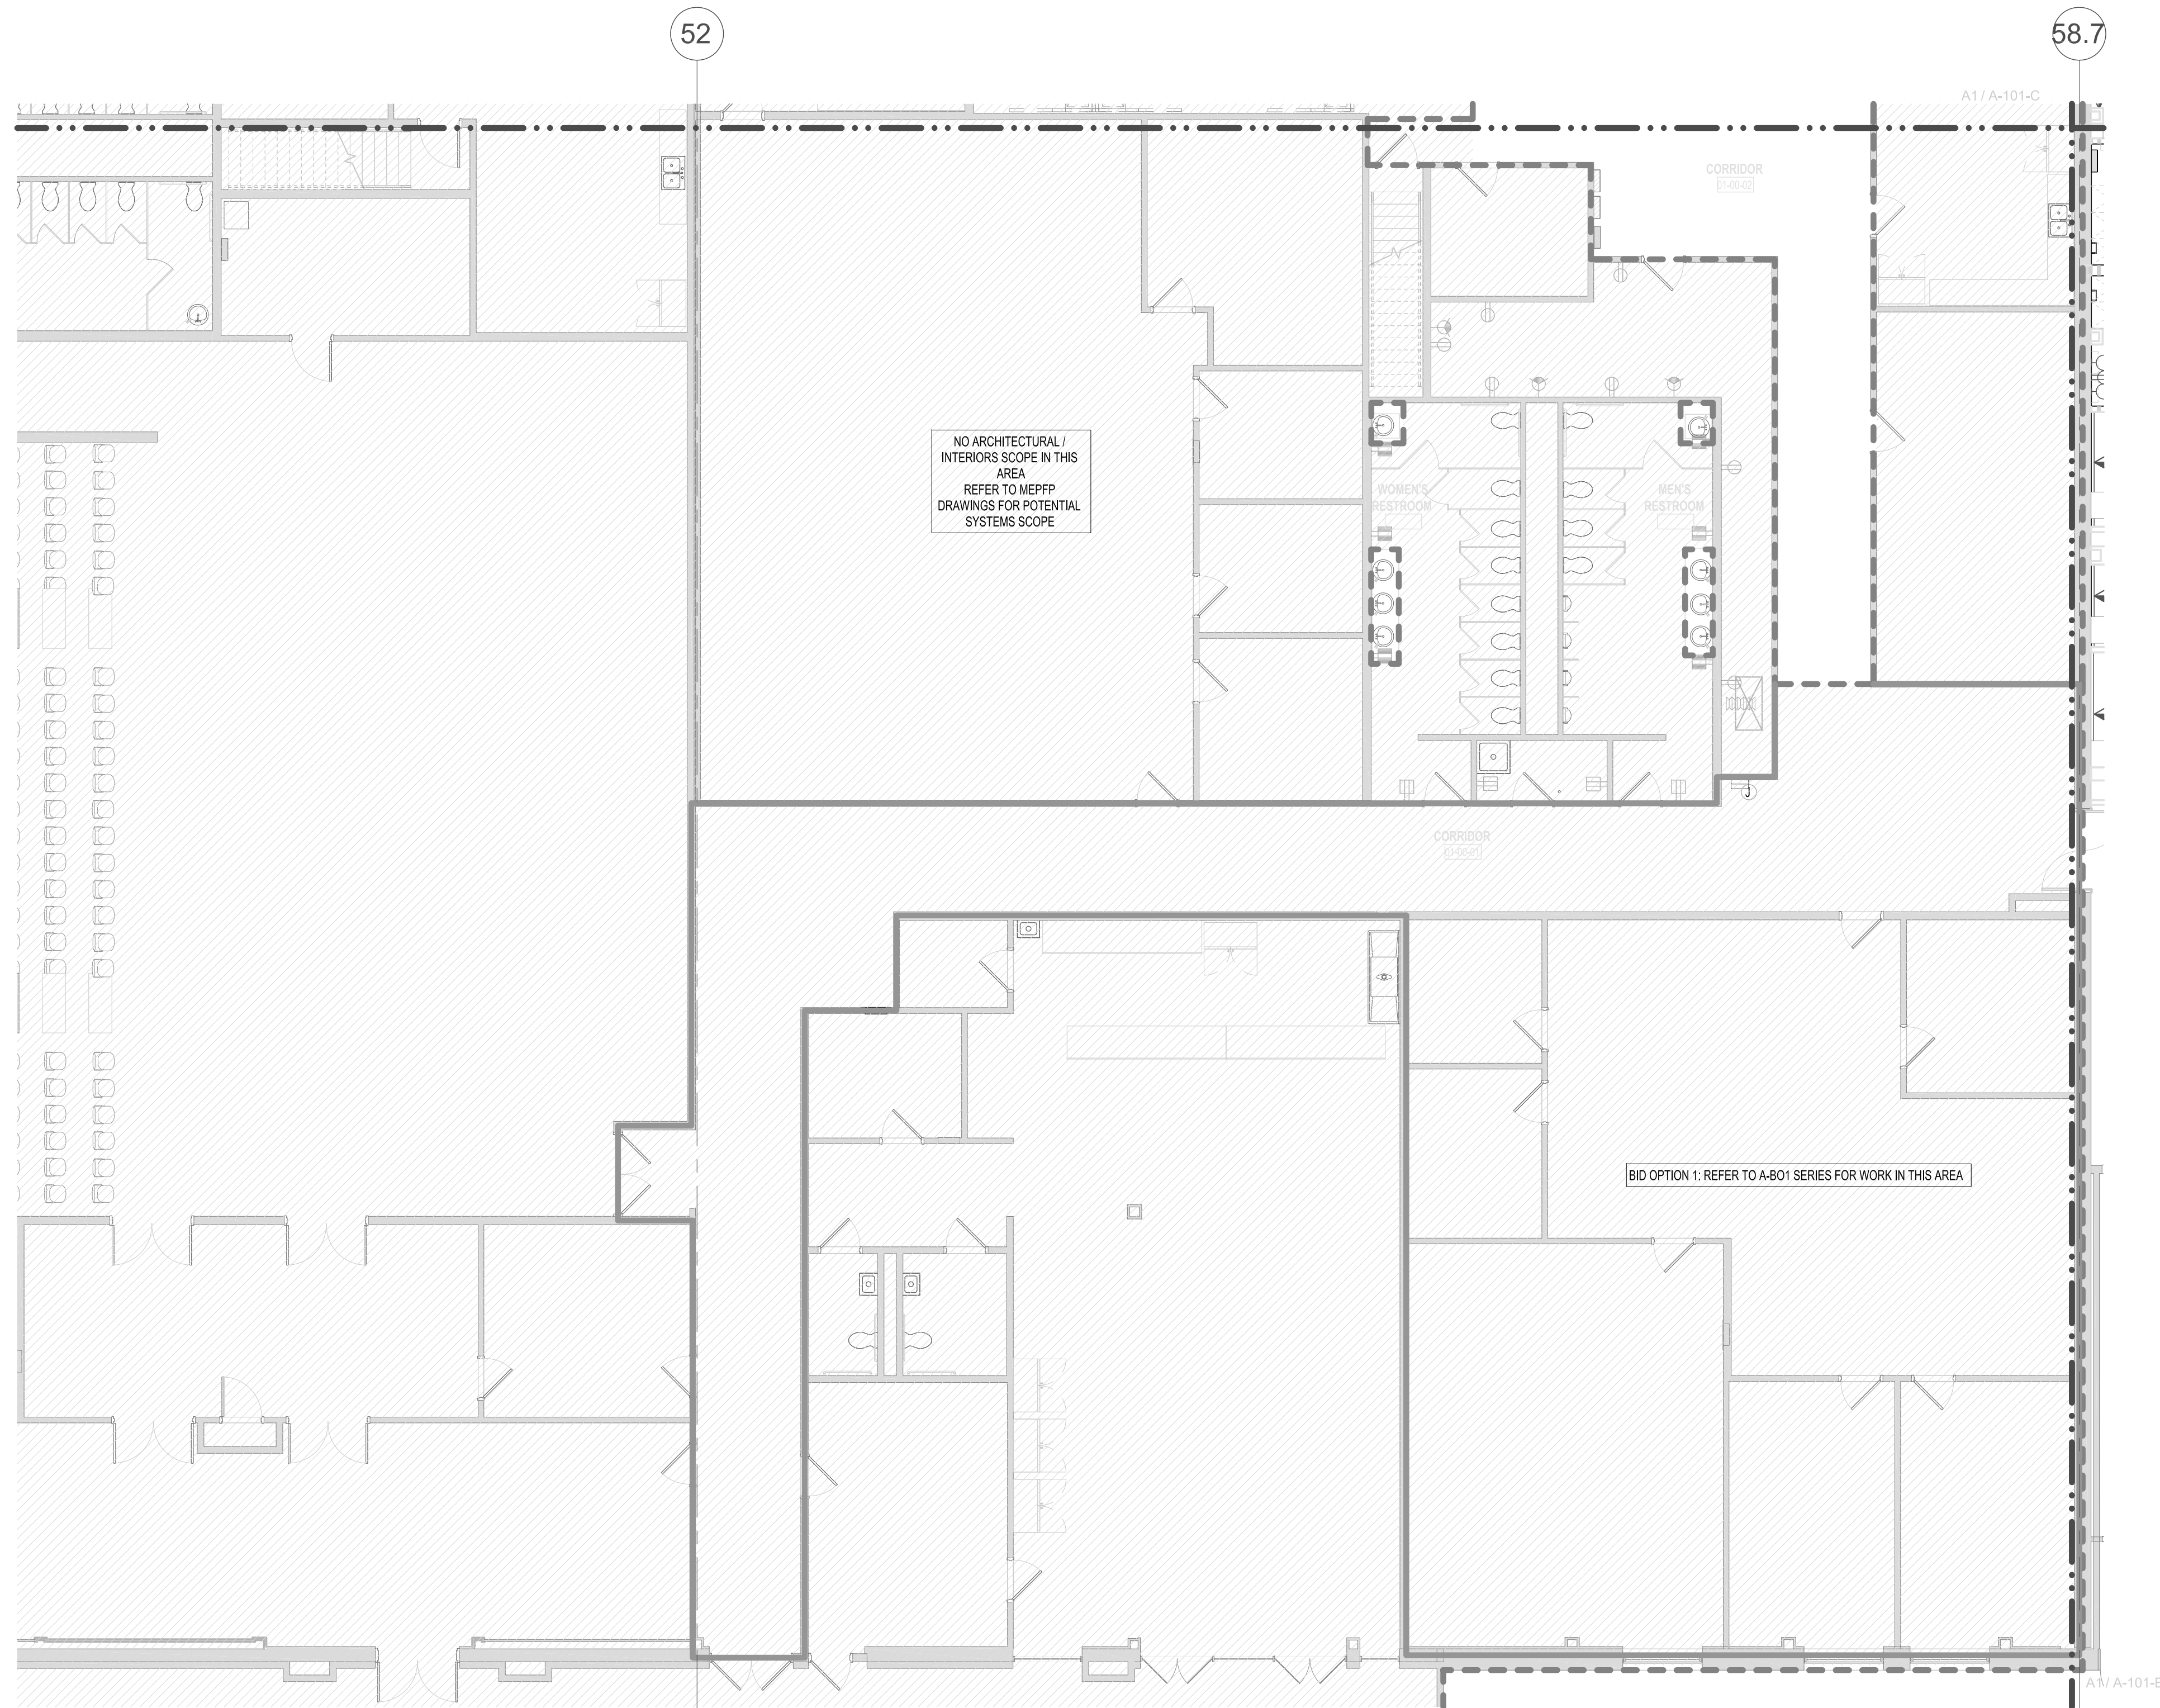


BID OPTION 1: REFER TO A-BO1 SERIES FOR WORK IN THIS AREA

L

A1V/ A-101-E

LEGEND

 DATA DROP LOCATION



GENERAL NOTES:

1. SPECIFIC DATA DROP LOCATIONS ARE NOT SHOWN FOR WORKSTATIONS. CABLING CONTRACTOR TO DETERMINE OPTIMAL PATHWAY.

[illegible]

DESIGNED BY:	DATE:
DRAWN BY: CKD BY:	06/24/2022
SUBMITTED BY:	SOLICITATION NO.:
	CONTRACT NO.:
	MXRD 21-0004
SCALE:	PLOT DATE: OF NO.:
1/8" = 1'-0"	
SIZE:	

DEPARTMENT OF THE AIR FORCE

AIR FORCE MATERIEL
COMMAND

66th AIR BASE GROUP/CECE
BASE CIVIL ENGINEER
DIVISION


REPAIR AFLCMC ACQ FAC, B1614

**1ST FLOOR
TEL/DATA PLAN
PART D**

B1614


A-801-D

ISSUE FOR BID

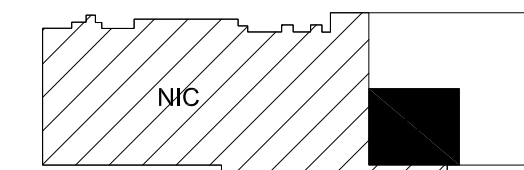

KEYPLAY

PLAN NORTH

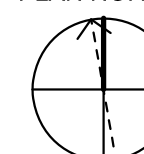

SCALE: 1/8"=1'-0"

A1

1ST FLOOR TEL/DATA PLAN - PART D

SCALE: 1/8" = 1'-0"

D

C


B

A

KEY NOTES
1. FURNITURE PANEL SHALL BE A MINIMUM OF 6 FEET IN HEIGHT.

FURNITURE PLAN LEGEND	
Plan Mark	Item Description
Private Office	
PO.TA	Type A Office Desk
PO.TB	Type B Office Desk
PO.TC	Type C Office Desk
PO.TD	Type D Office Desk
Open Office	
OO.TE.1	Type E Workstation (8'x8')
OO.TF.1	Type F Workstation (6'x8')
OO.TF.2	Type F Workstation (6'x7')
OO.TH.1	Type H Workstation (6'x5')
OO.TI.1	Type I Workstation (X'xX')
Other Office Furniture	
CONF.SM.1	60" Long x 42" Wide
CONF.SM.2	96" Long x 48" Wide
CONF.MD.1	134" Long x 48" Wide
CONF.MD.2	102" Long x 66" Wide
CONF.MD.3	126" Long x 48" Wide
CONF.LG.1	160" Long x 66" Wide
CONF.LG.2	264" Long x 60" Wide
CONF.LG.3	240" Long x 60" Wide
BR.1	Break Room Table
RT.42	42" Diameter Circular Table
CB.96	96" Wide Computer Workbench
BK.1	3 Shelf Bookcase
CR.9	Credenza
WB.48	48" Wide x 48" Tall Wall Mounted White Board
WB.60	60" Wide x 48" Tall Wall Mounted White Board
WB.72	72" Wide x 48" Tall Wall Mounted White Board
WB.96	96" Wide x 48" Tall Wall Mounted White Board
WB.120	120" Wide x 48" Tall Wall Mounted White Board
FC.2.1	GSA Security Container - 2 Drawer / 1 Lock (NIC)
FC.5.1	GSA Security Container - 5 Drawer / 1 Lock (NIC)
FC.5.5	GSA Security Container - 5 Drawer / 5 Lock (NIC)
Seating	
EX.UU	Office Chair - Private Office
T.MU	Office Chair - Workstation
GS.UU	Office Chair - Guest
CR.MU	Conference Room Chair
S.5	Break Room Chair
Office Equipment	
MF.1	Multi-Function Printer (NIC)
SCH.1	Paper Shredder (Up to CUI) (NIC)
SCH.2	Paper Shredder (NSA/CSS Approved) (NIC)

NIC = Not in Contract, items shown for reference only.

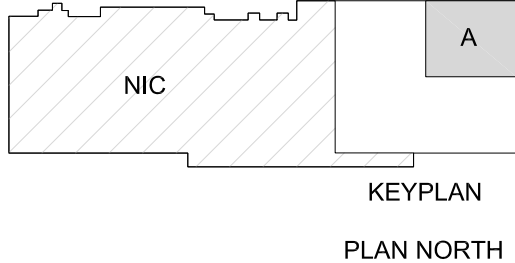

PLAN NORTH



A1

2ND FLOOR FURNITURE PLAN - PART A
SCALE: 1/8" = 1'-0"


DEPARTMENT OF THE AIR FORCE
AIR FORCE MATERIEL
COMMAND

2ND FLOOR
FURNITURE PLAN
PART A

REPAIR AFLCMC ACQ FAC. B1614

B1614
A-802-A

ISSUE FOR BID

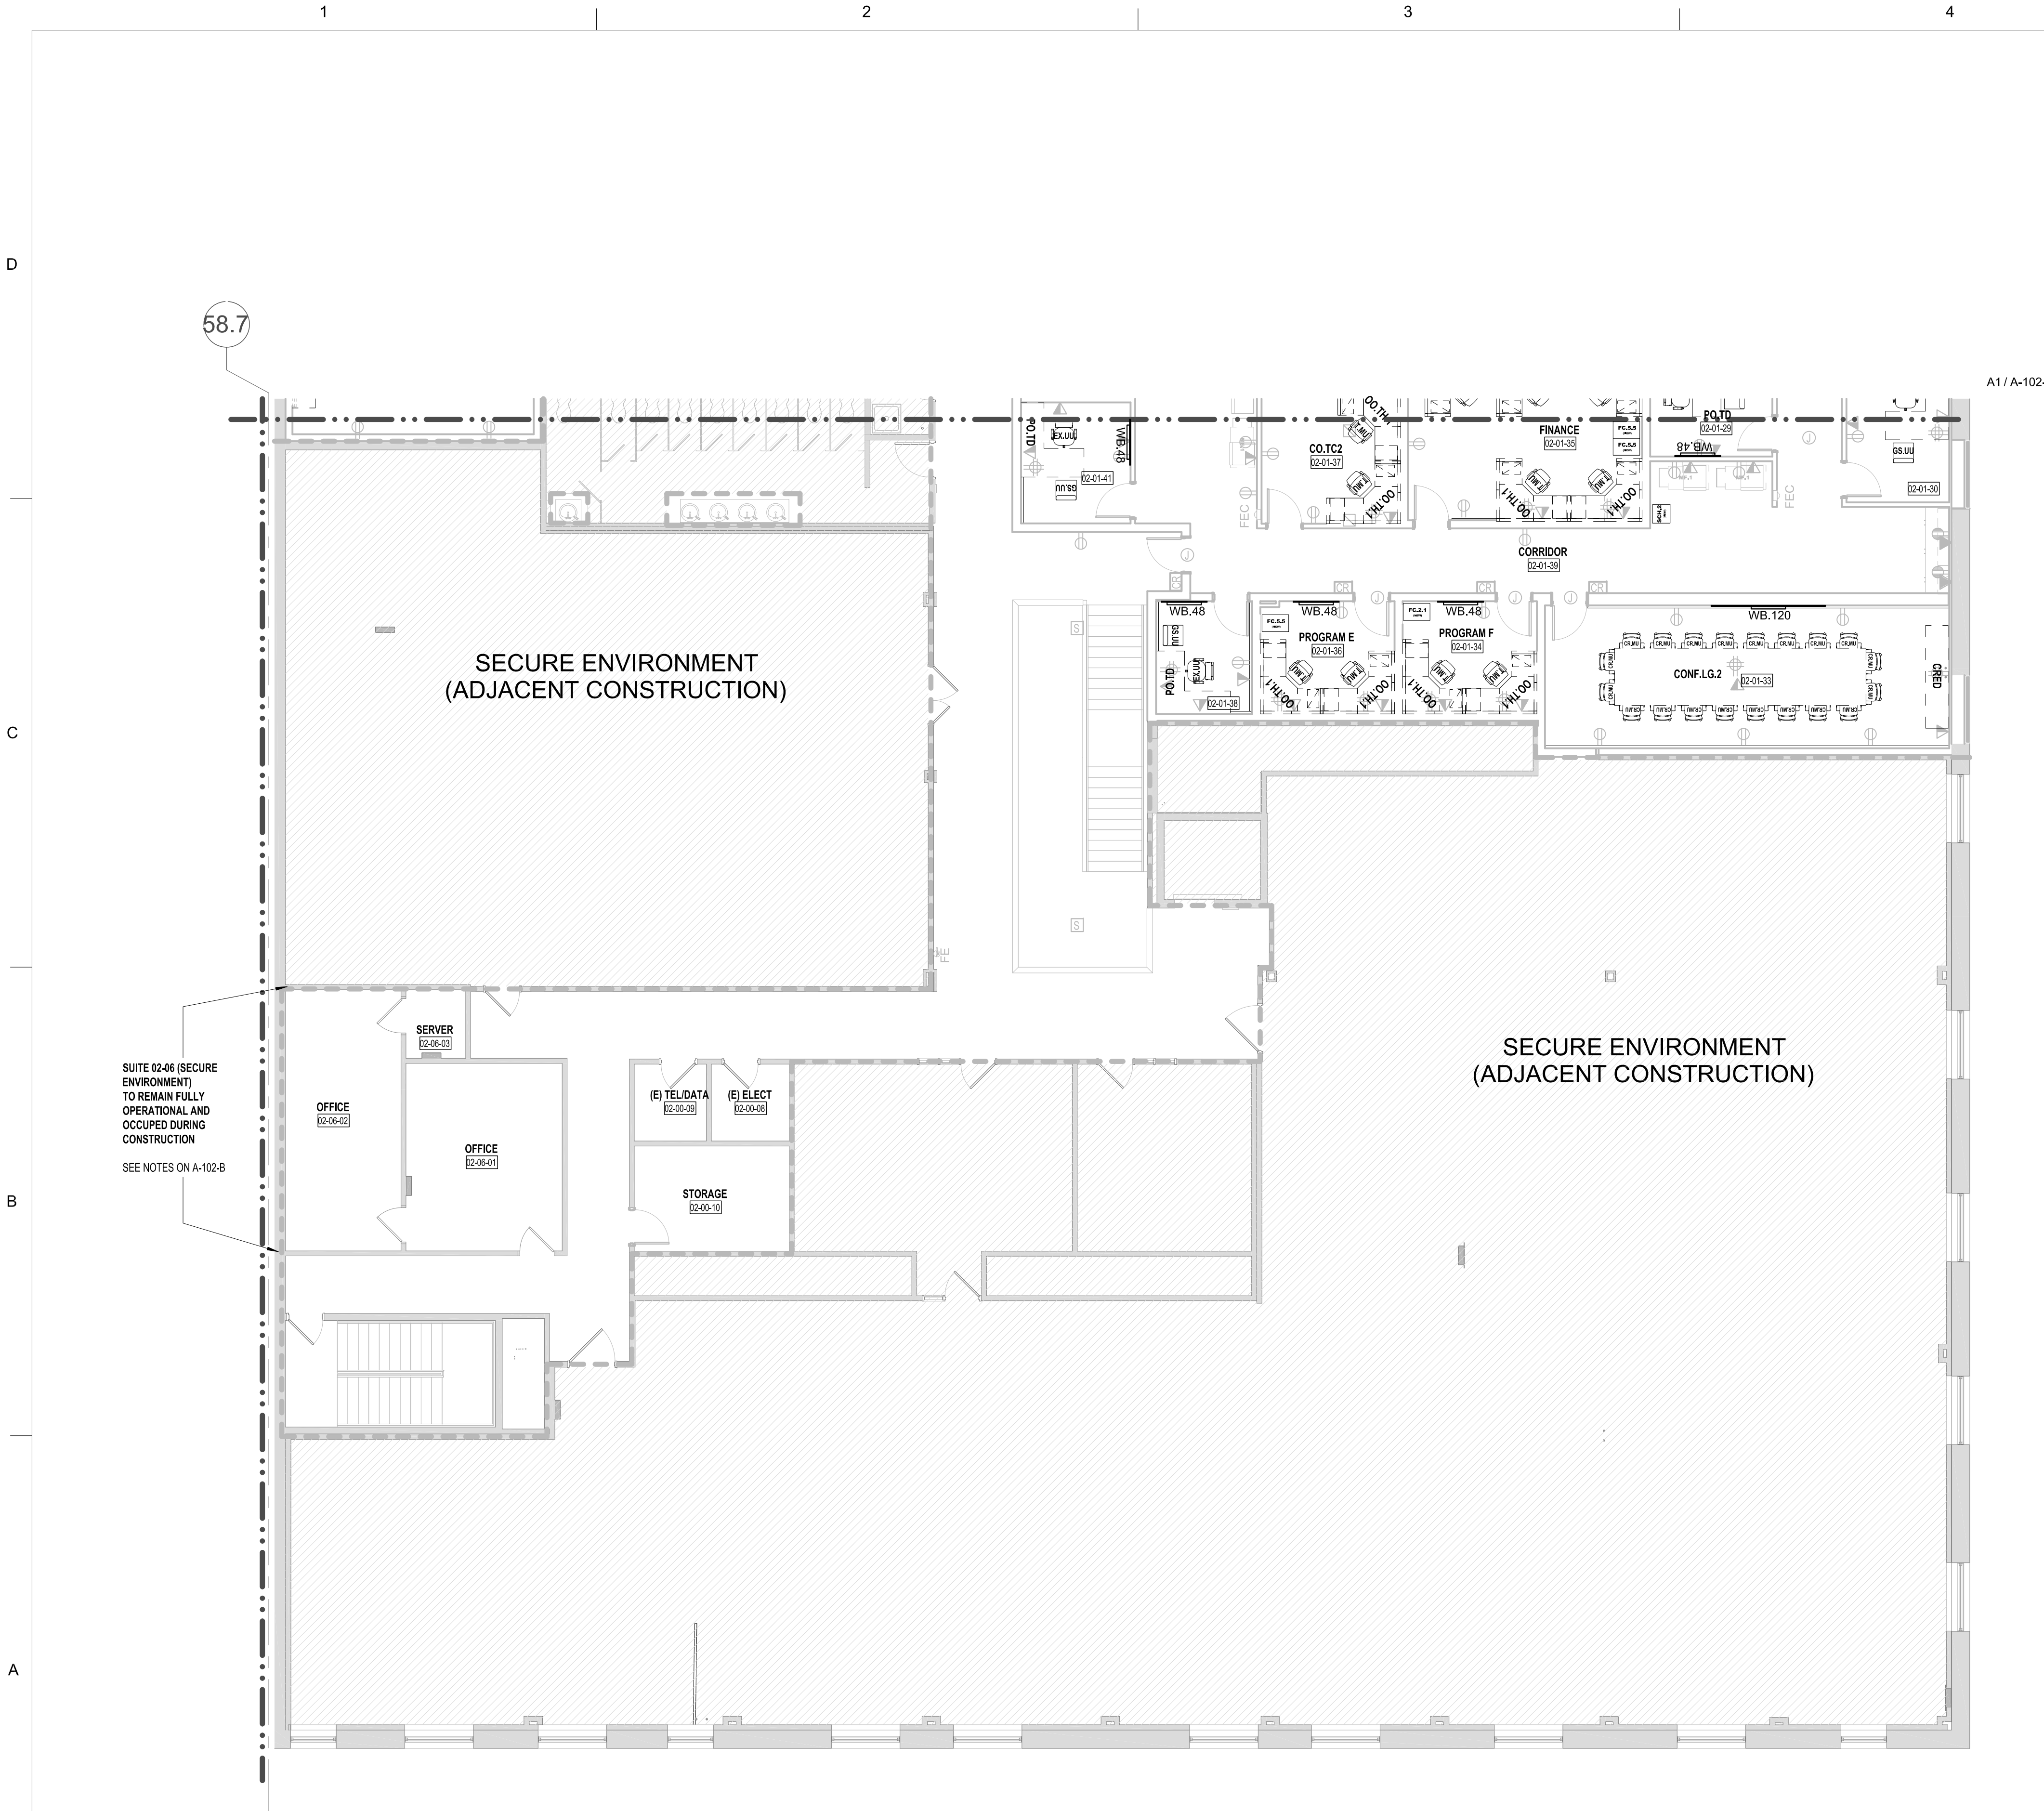


A1 2ND FLOOR FURNITURE PLAN - PART B
SCALE: 1/8" = 1'-0"

KEY NOTES
1. FURNITURE PANEL SHALL BE A MINIMUM OF 6 FEET IN HEIGHT.

FURNITURE PLAN LEGEND	
Plan Mark	Item Description
Private Office	
PO.TA	Type A Office Desk
PO.TB	Type B Office Desk
PO.TC	Type C Office Desk
PO.TD	Type D Office Desk
Open Office	
OO.TE.1	Type E Workstation (8'x8')
OO.TF.1	Type F Workstation (6'x8')
OO.TF.2	Type F Workstation (6'x7')
OO.TH.1	Type H Workstation (6'x5')
OO.TI.1	Type I Workstation (X'xX')
Other Office Furniture	
CONF.SM.1	60" Long x 42" Wide
CONF.SM.2	96" Long x 48" Wide
CONF.MD.1	134" Long x 48" Wide
CONF.MD.2	102" Long x 66" Wide
CONF.MD.3	126" Long x 48" Wide
CONF.LG.1	160" Long x 66" Wide
CONF.LG.2	264" Long x 60" Wide
CONF.LG.3	240" Long x 60" Wide
BR.1	Break Room Table
RT.42	42" Diameter Circular Table
CB.96	96" Wide Computer Workbench
BK.1	3 Shelf Bookcase
CR.9	Credenza
WB.48	48" Wide x 48" Tall Wall Mounted White Board
WB.60	60" Wide x 48" Tall Wall Mounted White Board
WB.72	72" Wide x 48" Tall Wall Mounted White Board
WB.96	96" Wide x 48" Tall Wall Mounted White Board
WB.120	120" Wide x 48" Tall Wall Mounted White Board
FC.2.1	GSA Security Container - 2 Drawer / 1 Lock (NIC)
FC.5.1	GSA Security Container - 5 Drawer / 1 Lock (NIC)
FC.5.5	GSA Security Container - 5 Drawer / 5 Lock (NIC)
Seating	
EX.UU	Office Chair - Private Office
T.MU	Office Chair - Workstation
GS.UU	Office Chair - Guest
CR.MU	Conference Room Chair
S.5	Break Room Chair
Office Equipment	
MF.1	Multi-Function Printer (NIC)
SCH.1	Paper Shredder (Up to CUI) (NIC)
SCH.2	Paper Shredder (NSA/CSS Approved) (NIC)

NIC = Not in Contract, items shown for reference only.

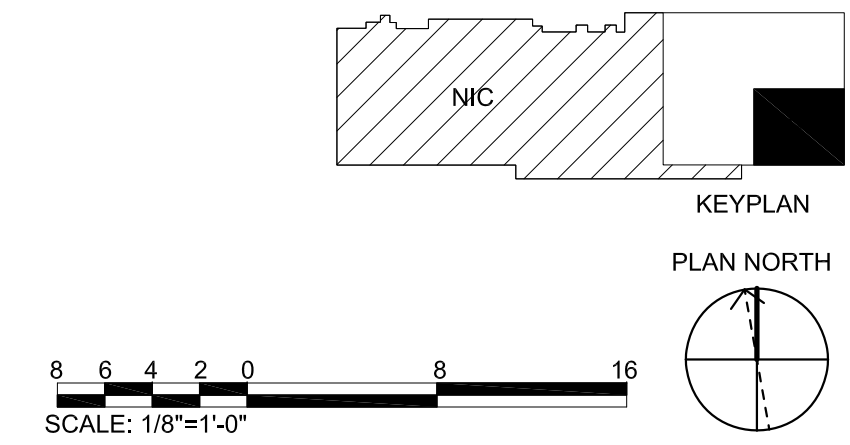



DESIGNED BY:	DATE:	SOLICITATION NO.:	CONTRACT NO.:
DRAWN BY: CKD BY:	08/24/2022	MXRD 21-0004	
SUBMITTED BY:	PLOT DATE:	OP NO.:	
SCALE:	1/8" = 1'-0"		
SIZE:	ANSI D		

DEPARTMENT OF THE AIR FORCE
**AIR FORCE MATERIEL
COMMAND**
66th AIR BASE GROUP/CECE
BASE CIVIL ENGINEER
DIVISION
HANSCOM AFB, MA 01731

**2ND FLOOR
FURNITURE PLAN
PART B**

B1614
A-802-B

ISSUE FOR BID

