


Hot Aisle Containment Room (HAC)
Main Communications Equipment Room (CER)

Solicitation FA461323Q0006
Attachment 5 - B333 Floor Plan with Scale


-  Duplex (130)
-  4 Plex (32)

RED current locations 130 (duplex - 112)
(4 Plex - 18)

ORANGE new installs (32) (duplex - 18)
(4 plex - 14)

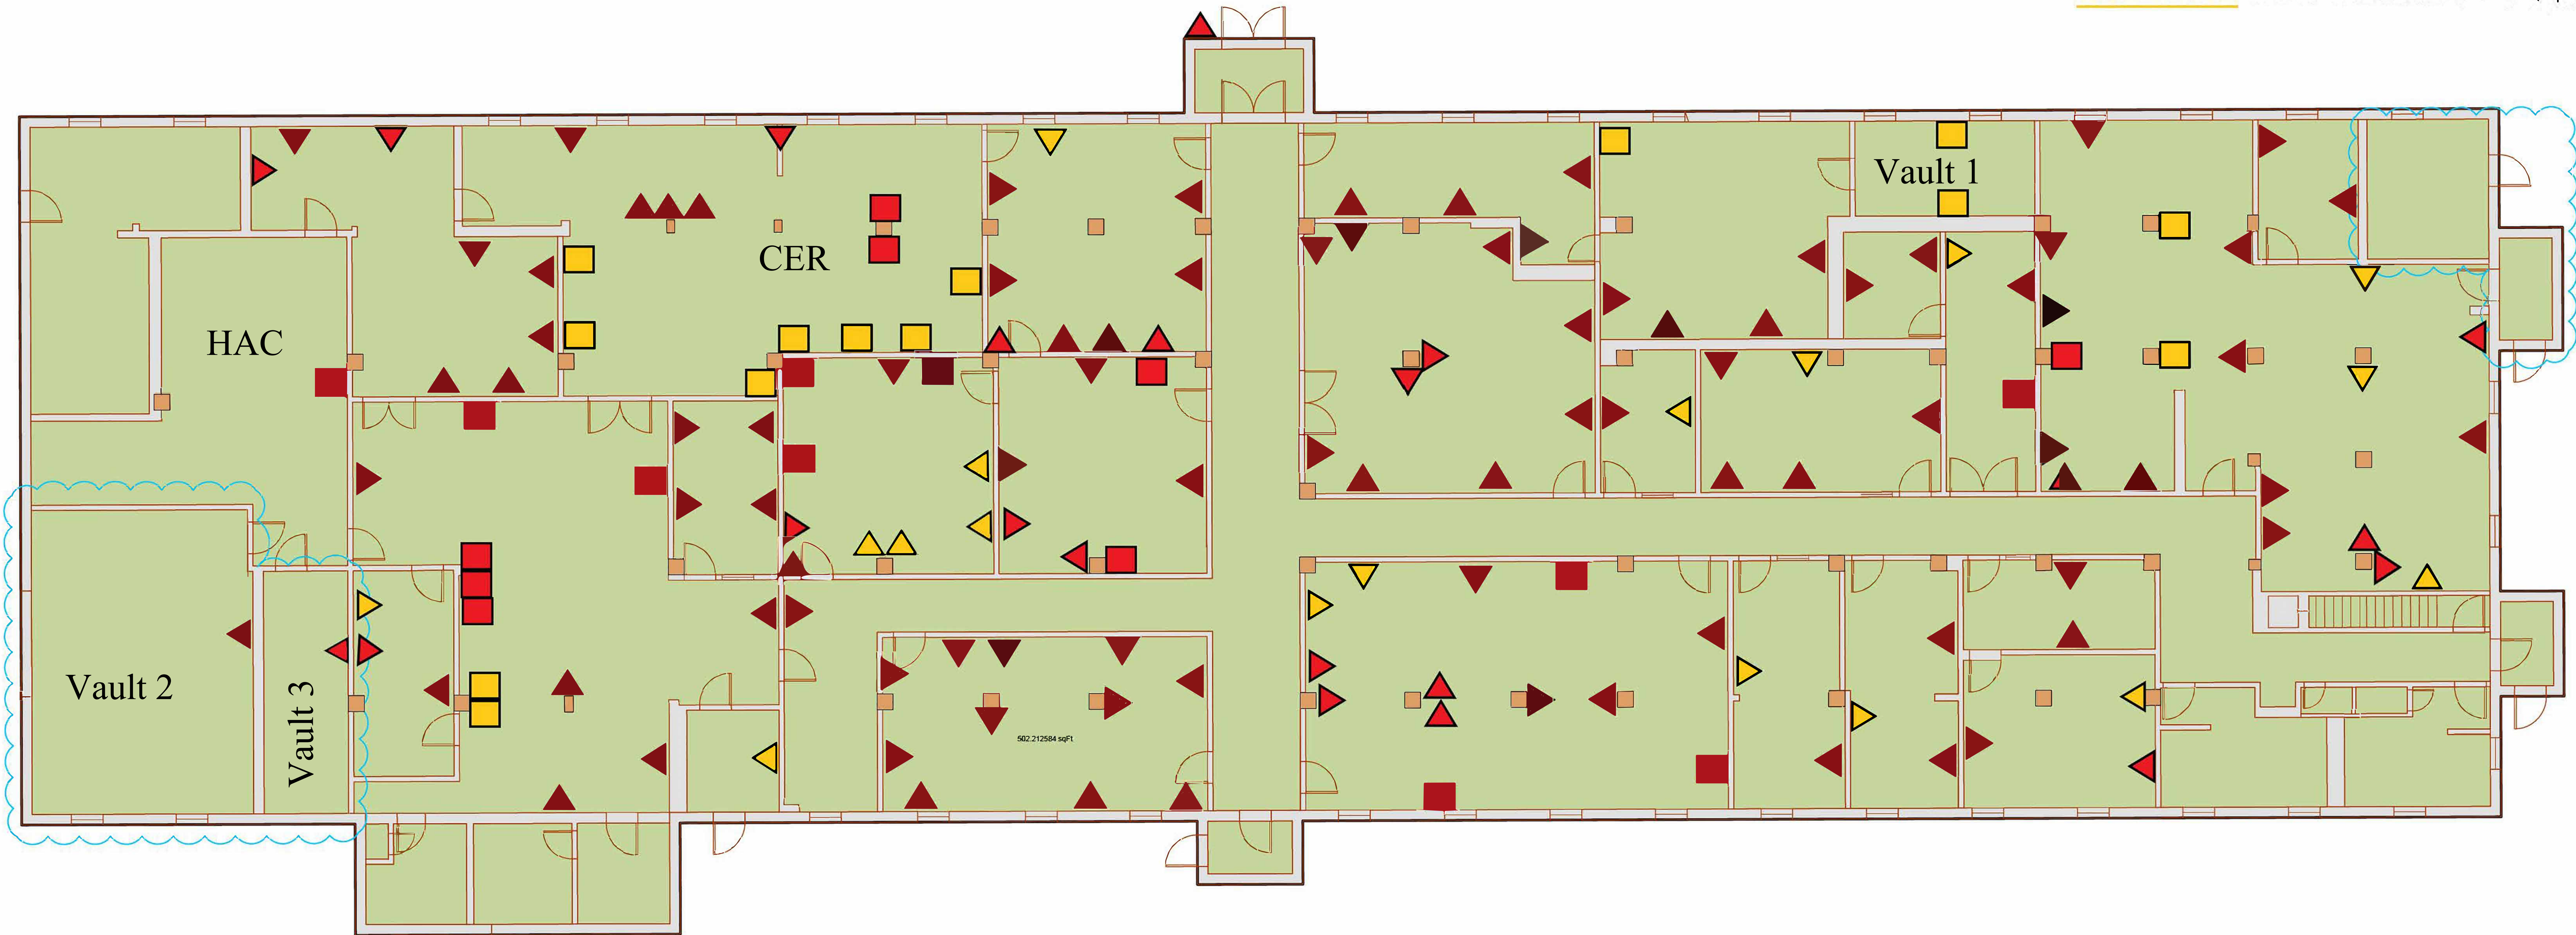

-  90CS
-  Obstruction
-  Unscanned Space

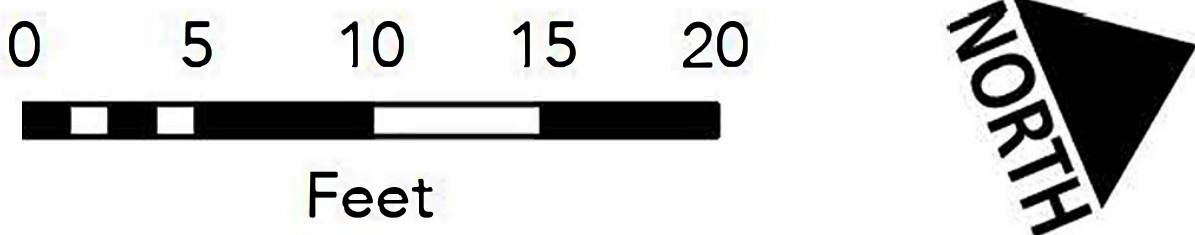

Scale 1:100 1 inch = 8 feet

Francis E. Warren Air Force Base
Cheyenne, Wyoming

BLDG 333
1F
COMM FACILITY
SHEET 1/1