



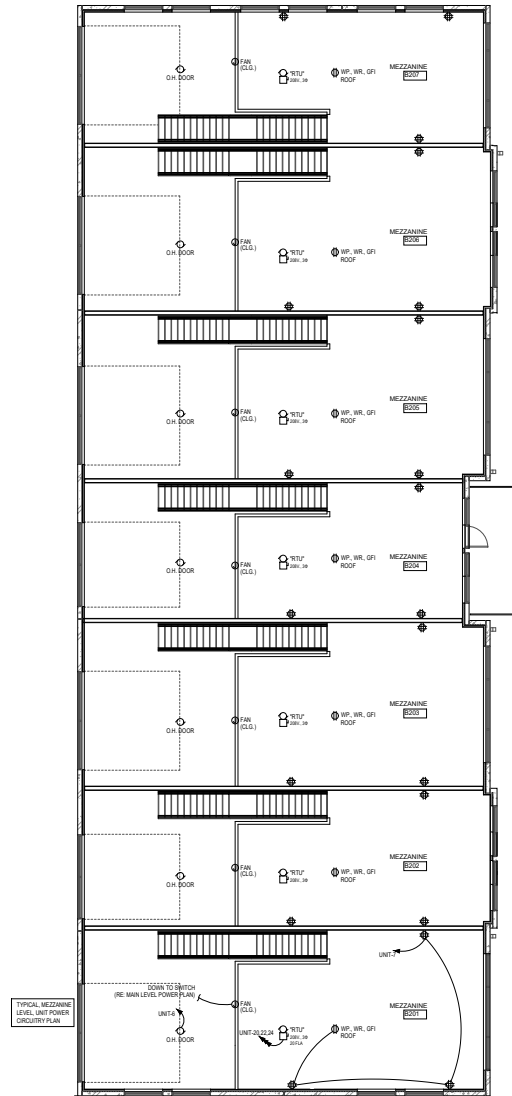

MEZZANINE LEVEL POWER PLAN  
SCALE: 1/8"=1'-0"

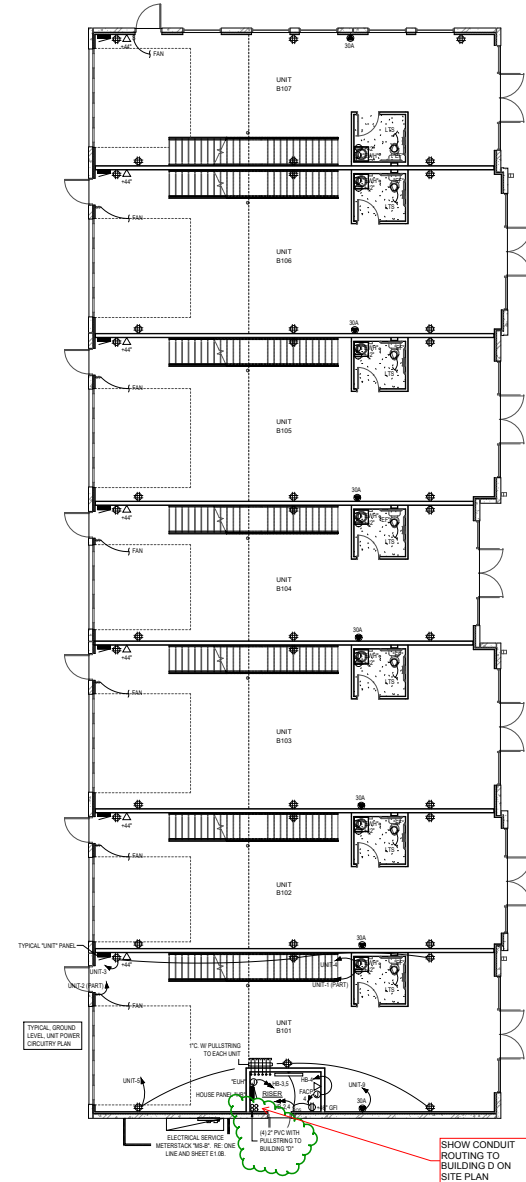

GROUND LEVEL POWER PLAN  
SCALE: 1/8"=1'-0"

|                                                                                                                                                                                                                 |                      |                        |
|-----------------------------------------------------------------------------------------------------------------------------------------------------------------------------------------------------------------|----------------------|------------------------|
| DATE                                                                                                                                                                                                            | 8/2/2021             | DESCRIPTION / REVISION |
| FOR                                                                                                                                                                                                             | CONSTRUCTION         |                        |
| <p><b>construction company, inc.</b><br/> <small>1000 East 10th Avenue • Denver, Colorado 80218 • Tel: 303.733.7333 • Fax: 303.733.7334 • www.cdb.com</small></p>                                               |                      |                        |
| <p><b>43330</b><br/> <small>REGISTERED PROFESSIONAL ENGINEER</small></p>                                                                                                                                        |                      |                        |
| <p><b>8/2/2021</b></p>                                                                                                                                                                                          |                      |                        |
| <p><b>UT-SCHEPPE</b><br/> <small>UT-SCHEPPE ELECTRICAL ENGINEERS<br/>         1000 W. 10TH AVE. SUITE 100 • DENVER, CO 80202<br/>         TEL: 303.733.7333 • FAX: 303.733.7334 • www.utscheppe.com</small></p> |                      |                        |
| <p>A NEW BUILDING FOR:<br/> <b>GARAGECONDOS at RACINE CIR.</b><br/> <b>SMALL BUSINESS SOLUTIONS</b><br/> <b>BUILDING B</b><br/>         6507 S. RACINE CIRCLE, CENTENNIAL, CO 80111</p>                         |                      |                        |
| Design Project No.                                                                                                                                                                                              | 19-907               |                        |
| Drawing Title                                                                                                                                                                                                   | BLDG "B" POWER PLANS |                        |
| Drawing No.                                                                                                                                                                                                     | E2.0B                |                        |