
 


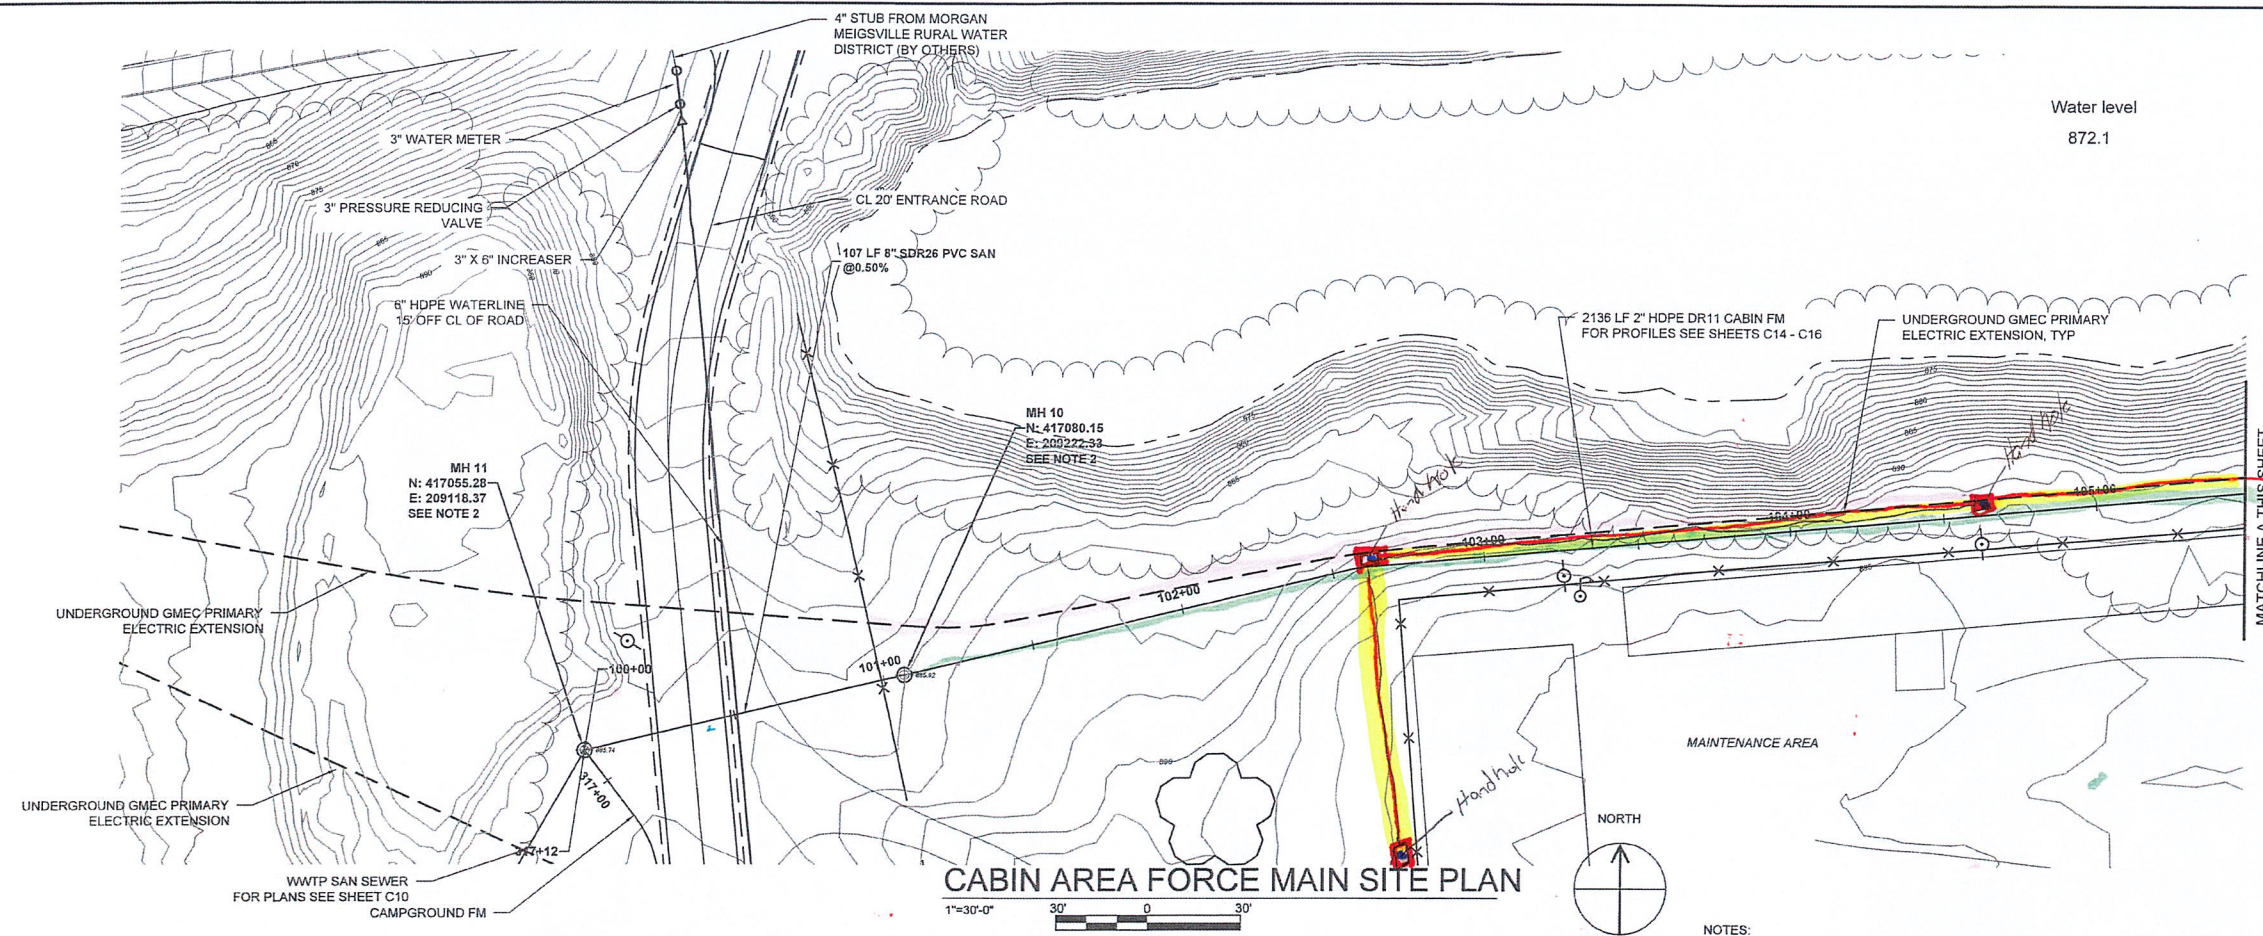


CABIN AREA FORCE MAIN SITE PLAN

1"=30'-0" 30' 0 30'



NOTES:

1. ALL WATER LINES, SANITARY SEWER FORCE MAINS AND ELECTRIC CONDUITS SHALL BE INSTALLED BY HORIZONTAL DIRECTIONAL DRILLING METHODS.
2. MANHOLES 10 AND 11 TO BE LINED WITH PROTECTIVE COATING IN THE INTERIOR OF THE MANHOLE.

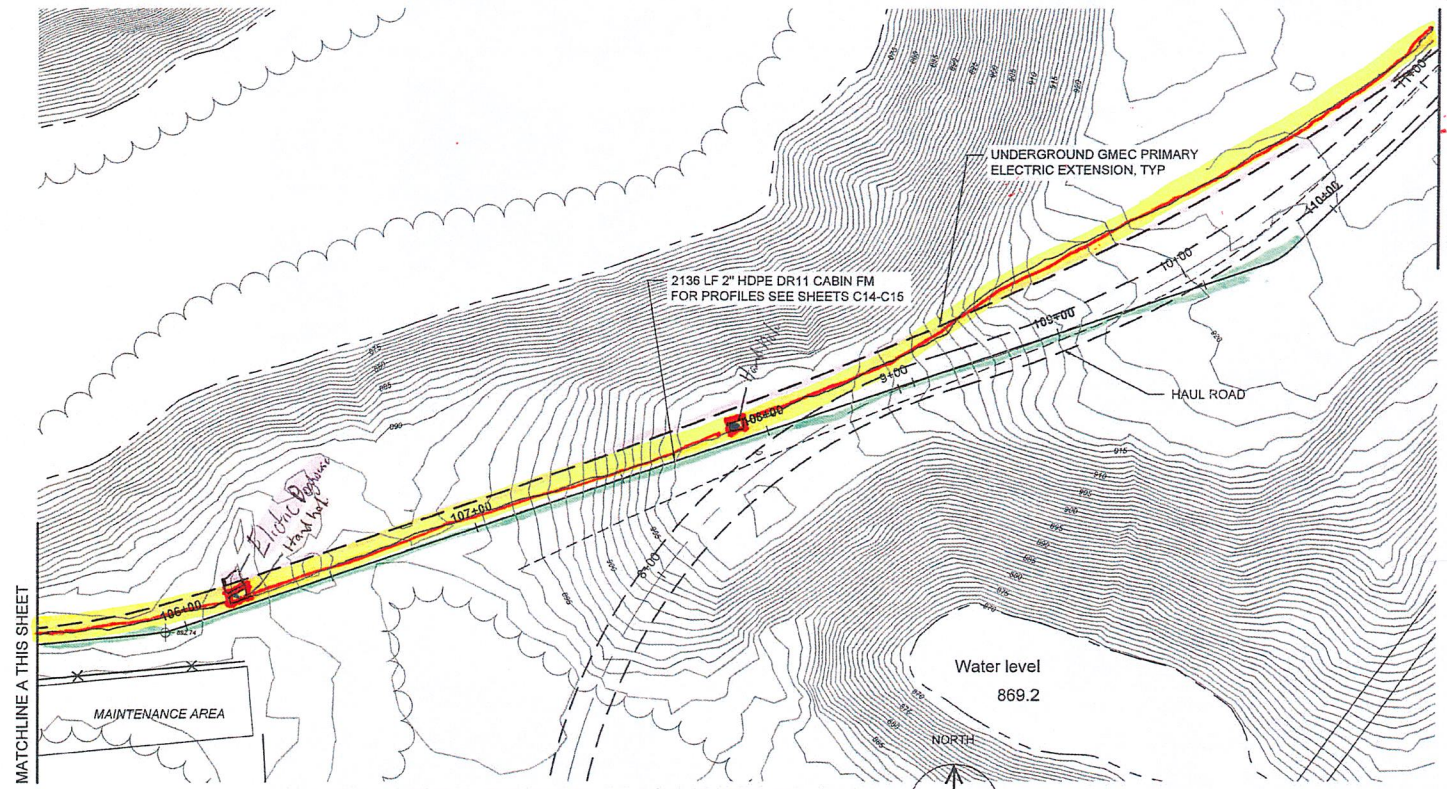

CABIN AREA FORCE MAIN SITE PLAN

1"=30'-0" 30' 0 30'



2" force main
Electric
DATA / Telephone

FIGURE 1-1: SEE OVERSIGHT CABIN AREA FM SITE PLAN C4



PLANS PREPARED BY:
17 SOUTH MAIN ST, SUITE 201
AKRON, OHIO 44308
330-294-5996



ENGINEERING
Ohio Department of Natural Resources

DESIGNED BY:	TMK			
DRAWN BY:	AJP			
CHECKED BY:	DBK			
APPROVED BY:	TMK	NO.	DATE	SUBJECT
		REVISION OR ISSUE		

AS SHOWN
SCALE
3/01/24
DATE

JESSE OWENS STATE PARK
CAMPGROUND IMPROVEMENTS
DNR-232001

CABIN AREA FM SITE PLAN 1

C4