



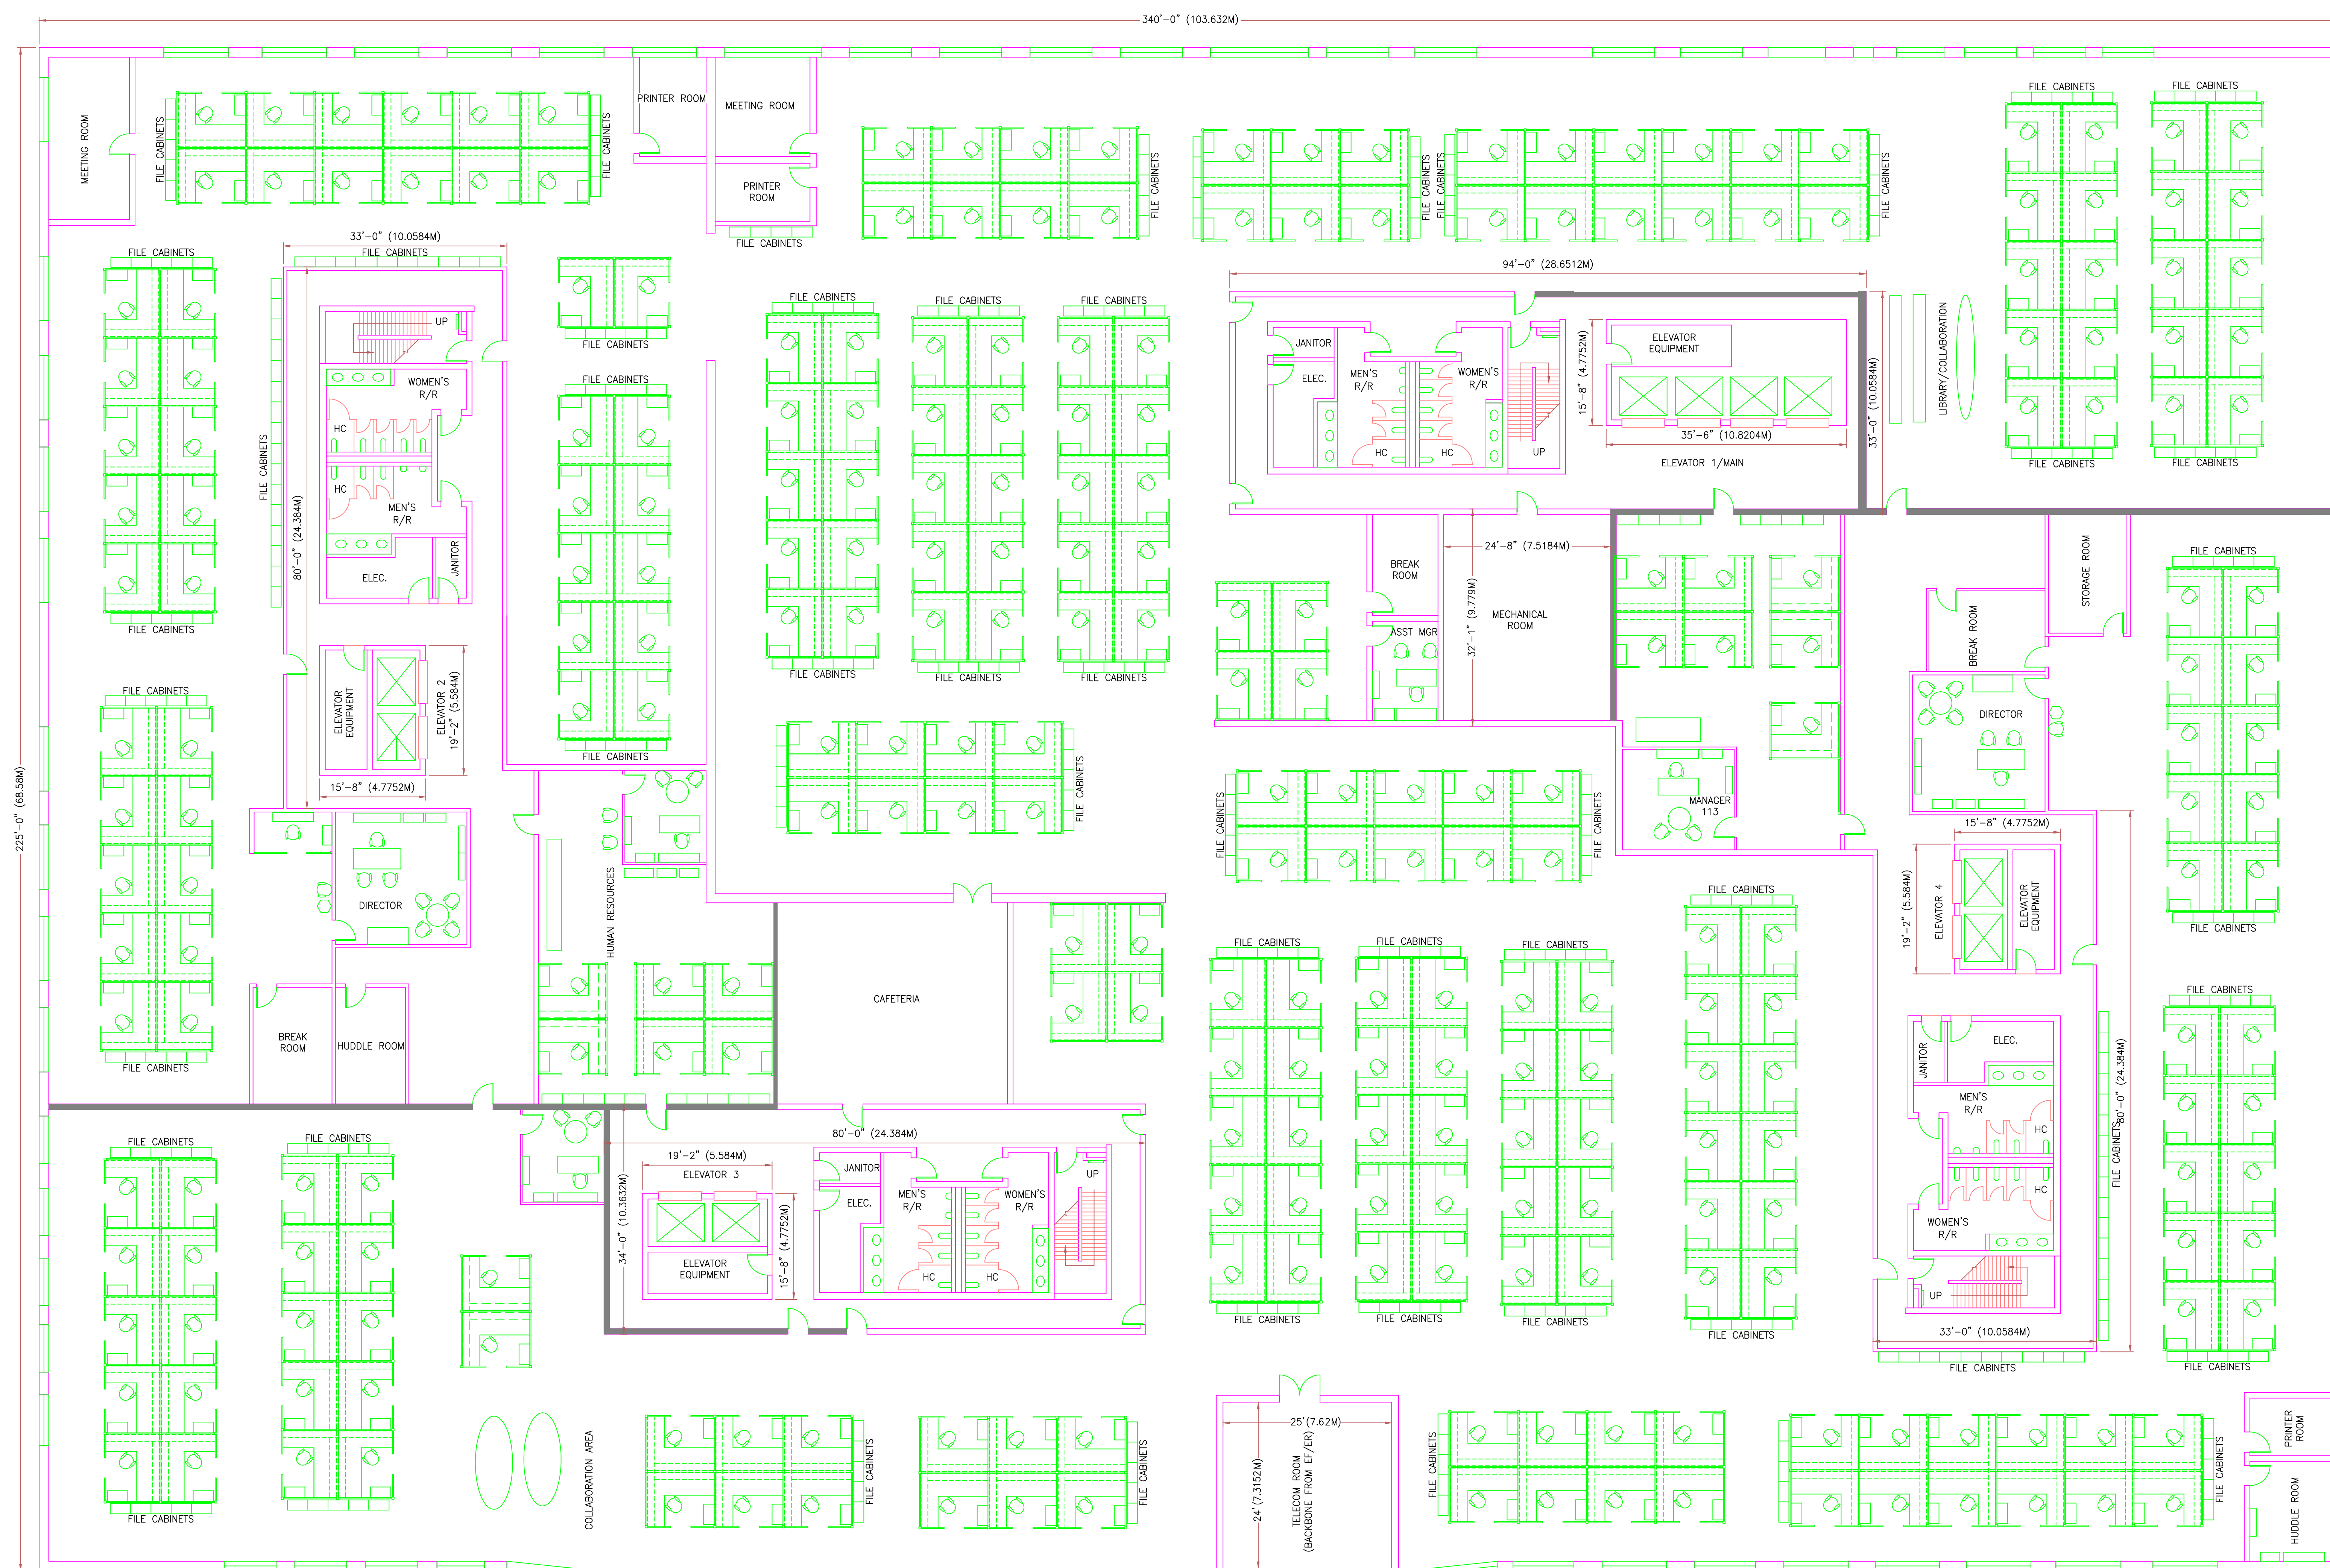

SECOND FLOOR PLAN

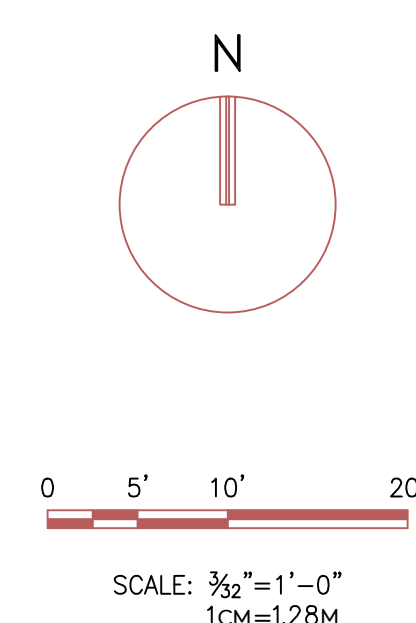

THIS DRAWING REPRESENTS TELECOMMUNICATIONS DIAGRAMS PROVIDED UNDER THE CONSULTING SERVICES OF INFORMATION TRANSPORT SYSTEMS DESIGN INTERNATIONAL. IT IS BASED UPON ARCHITECTURAL LAYOUTS, ELECTRICAL, MECHANICAL, AND OTHER PLANS THAT ARE DEVELOPED FOR CLASSROOM EXERCISES ONLY. NO OTHER FAULTS FOR ERRORS, OMISSIONS, ACCURACY OR ANY OTHER FAULTS SHALL BE ASSUMED BY INFORMATION TRANSPORT SYSTEMS DESIGNERS INTERNATIONAL FOR ITEMS OTHER THAN THE TELECOMMUNICATIONS DIAGRAMS PROVIDED; SUCH RESPONSIBILITY SHALL BE SUBJECT TO TERMS AND CONDITIONS OF THE CLIENT AGREEMENT.



8610 HIDDEN RIVER PARKWAY
TAMPA, FL 33637-1000
(800) 242-7405 FAX (813) 971-4311
www.bicsi.org

Taylorsville
Municipal Complex
DD102 Activities

DESCRIPTION	DATE	REV. No.
SHEET No.		
T-1.2		
PROJECT No.		1041
DRAWN BY:	MDH	CHECKED BY:
SCALE:	$\frac{3}{32}'' = 1' - 0''$	DATE: 1-21-2021
FILE:	DD102-T-1.2	

THIS DOCUMENT CONTAINS INFORMATION PROPRIETARY TO THE BUILDING INDUSTRY CONSULTING SERVICES, INC. AND IT IS FURNISHED FOR USE IN BICSI AUTHORIZED TRAINING COURSES. THIS DOCUMENT OR ITS CONTENTS MAY NOT BE USED FOR ANY OTHER PURPOSE AND MAY NOT BE REPRODUCED OR DISCLOSED TO OTHERS WITHOUT THE PRIOR WRITTEN CONSENT OF BICSI.