

THIS DRAWING REPRESENTS TELECOMMUNICATIONS DIAGRAM
PROVIDED UNDER THE CONSULTING SERVICES OF INFORMATION
TRANSPORT SYSTEMS DESIGNERS INTERNATIONAL, IT IS BASED UPON
ARCHITECTURAL LAYOUTS, ELECTRICAL, MECHANICAL & OTHER PLANS
THAT ARE DEVELOPED FOR CLASSROOM EXERCISES ONLY.
NO RESPONSIBILITY FOR ERRORS, OMISSIONS, ACCURACY OR
OTHER FAULTS SHALL BE ASSUMED BY INFORMATION TRANSPORT
SYSTEMS DESIGNERS INTERNATIONAL FOR ITEMS OTHER THAN THE
TELECOMMUNICATIONS DIAGRAMS PROVIDED. SUCH
RESPONSIBILITY SHALL BE SUBJECT TO TERMS AND CONDITIONS
OF THE CLIENT AGREEMENT.

Bicsi
RCDD
EXERCISE
PURPOSES

8610 HIDDEN RIVER PARKWAY
TAMPA, FL 33637-1000
PH (800) 242-7405 FAX (813) 971-4311
www.bicsi.org

Taylorsville
Municipal Complex
DD102 Activities

DESCRIPTION	DATE	REV. No.

SHEET No.

T-1.3


PROJECT No. 1041

DRAWN BY: MDH CHECKED BY:

SCALE: 1/32"=1'-0" DATE: 1-21-2021

FILE: DD102-T-1.3

THIS DOCUMENT CONTAINS INFORMATION PROPRIETARY TO
THE BUILDING INDUSTRY CONSULTING SERVICES, INC. AND
IT IS FURNISHED FOR USE IN BICS AUTHORIZED TRAINING COURSES.
THIS DOCUMENT OR ITS CONTENTS MAY NOT BE USED FOR
ANY OTHER PURPOSE AND MAY NOT BE REPRODUCED OR
DISCLOSED TO OTHERS WITHOUT THE PRIOR WRITTEN CONSENT
OF BICS.

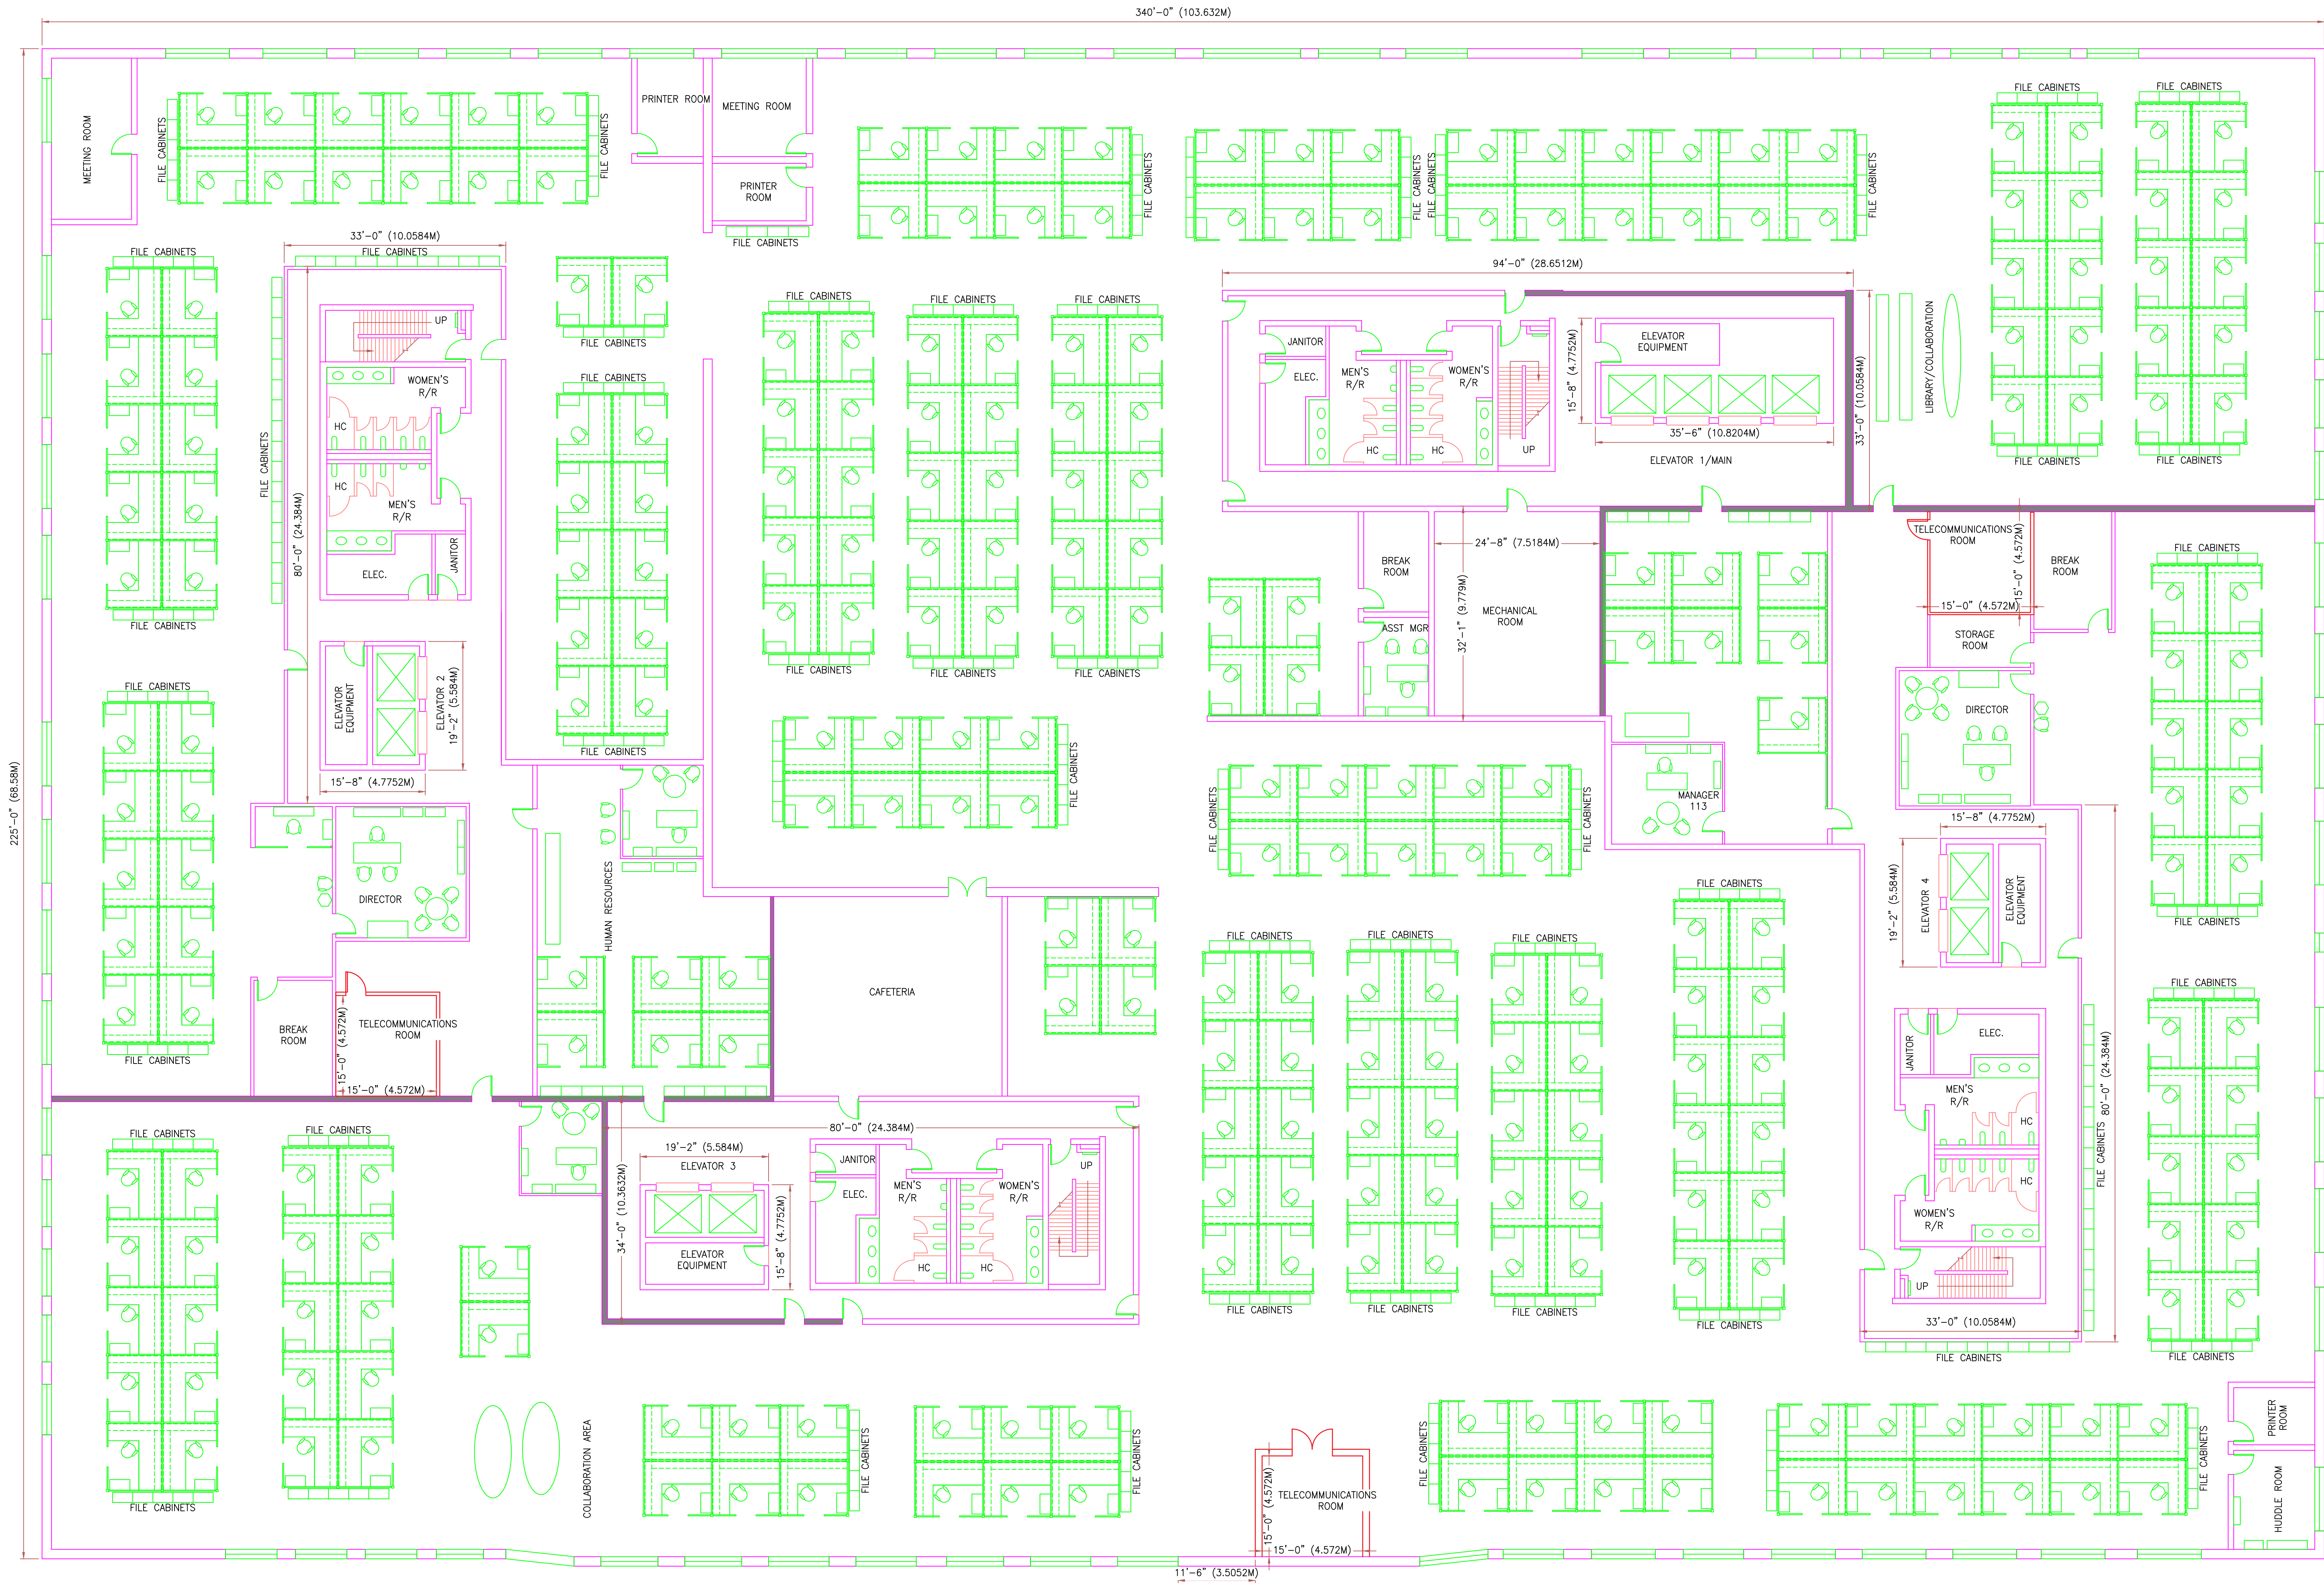

THIRD FLOOR PLAN