


SHEET KEYNOTES

- 1 ALL GUEST ROOM RECEPTACLES SHALL BE TAMPER RESISTANT.
- 2 PROVIDE PUTTY PACKS AROUND BOXES IN PARTY WALLS.
- 3 VERIFY PTAC OUTLET LOCATIONS WITH EQUIPMENT SHOP DRAWINGS.
- 4 ALL HORNS IN GUEST ROOMS SHALL BE LOW-FREQUENCY TYPE.
- 5 PROVIDE GUEST MANAGEMENT ROOM SYSTEM FOR ALL ROOMS. SEE DRAWINGS FROM MARRIOTT FOR REQUIREMENTS AND PROVIDE ALL PARTS AND WIRING AND SYSTEMS AND PROGRAMMING SHOWN IN THESE DOCUMENTS

- 1 PROVIDE CONNECTIONS TO SLIDING GLASS DOORS PER MANUFACTURER'S REQUIREMENTS.
- 2 PROVIDE 0.75" CONDUIT FROM J-BOX AT SWITCH HEIGHT TO DOOR HEADER AND A 0.75" CONDUIT FROM THE DOOR POWER SUPPLY TO THE FRONT DESK.
- 3 PROVIDE CONNECTIONS TO FIRE PIT. COORDINATE IGNITION SWITCH LOCATION WITH OWNER. PROVIDE EMERGENCY GAS SHUTOFF SWITCH AT LOCATION DETERMINED BY OWNER (WITHIN SIGHT OF THE FIREPLACE).
- 4 PROVIDE JUNCTION BOX WITH 0.75" CONDUIT STUB TO DOOR HEADER. COORDINATE WITH BUILDING SECURITY INSTALLER.
- 5 PROVIDE CONNECTIONS TO BUILDING SIGNAGE. COORDINATE ROUGH-IN LOCATION(S) WITH SIGNAGE INSTALLER.

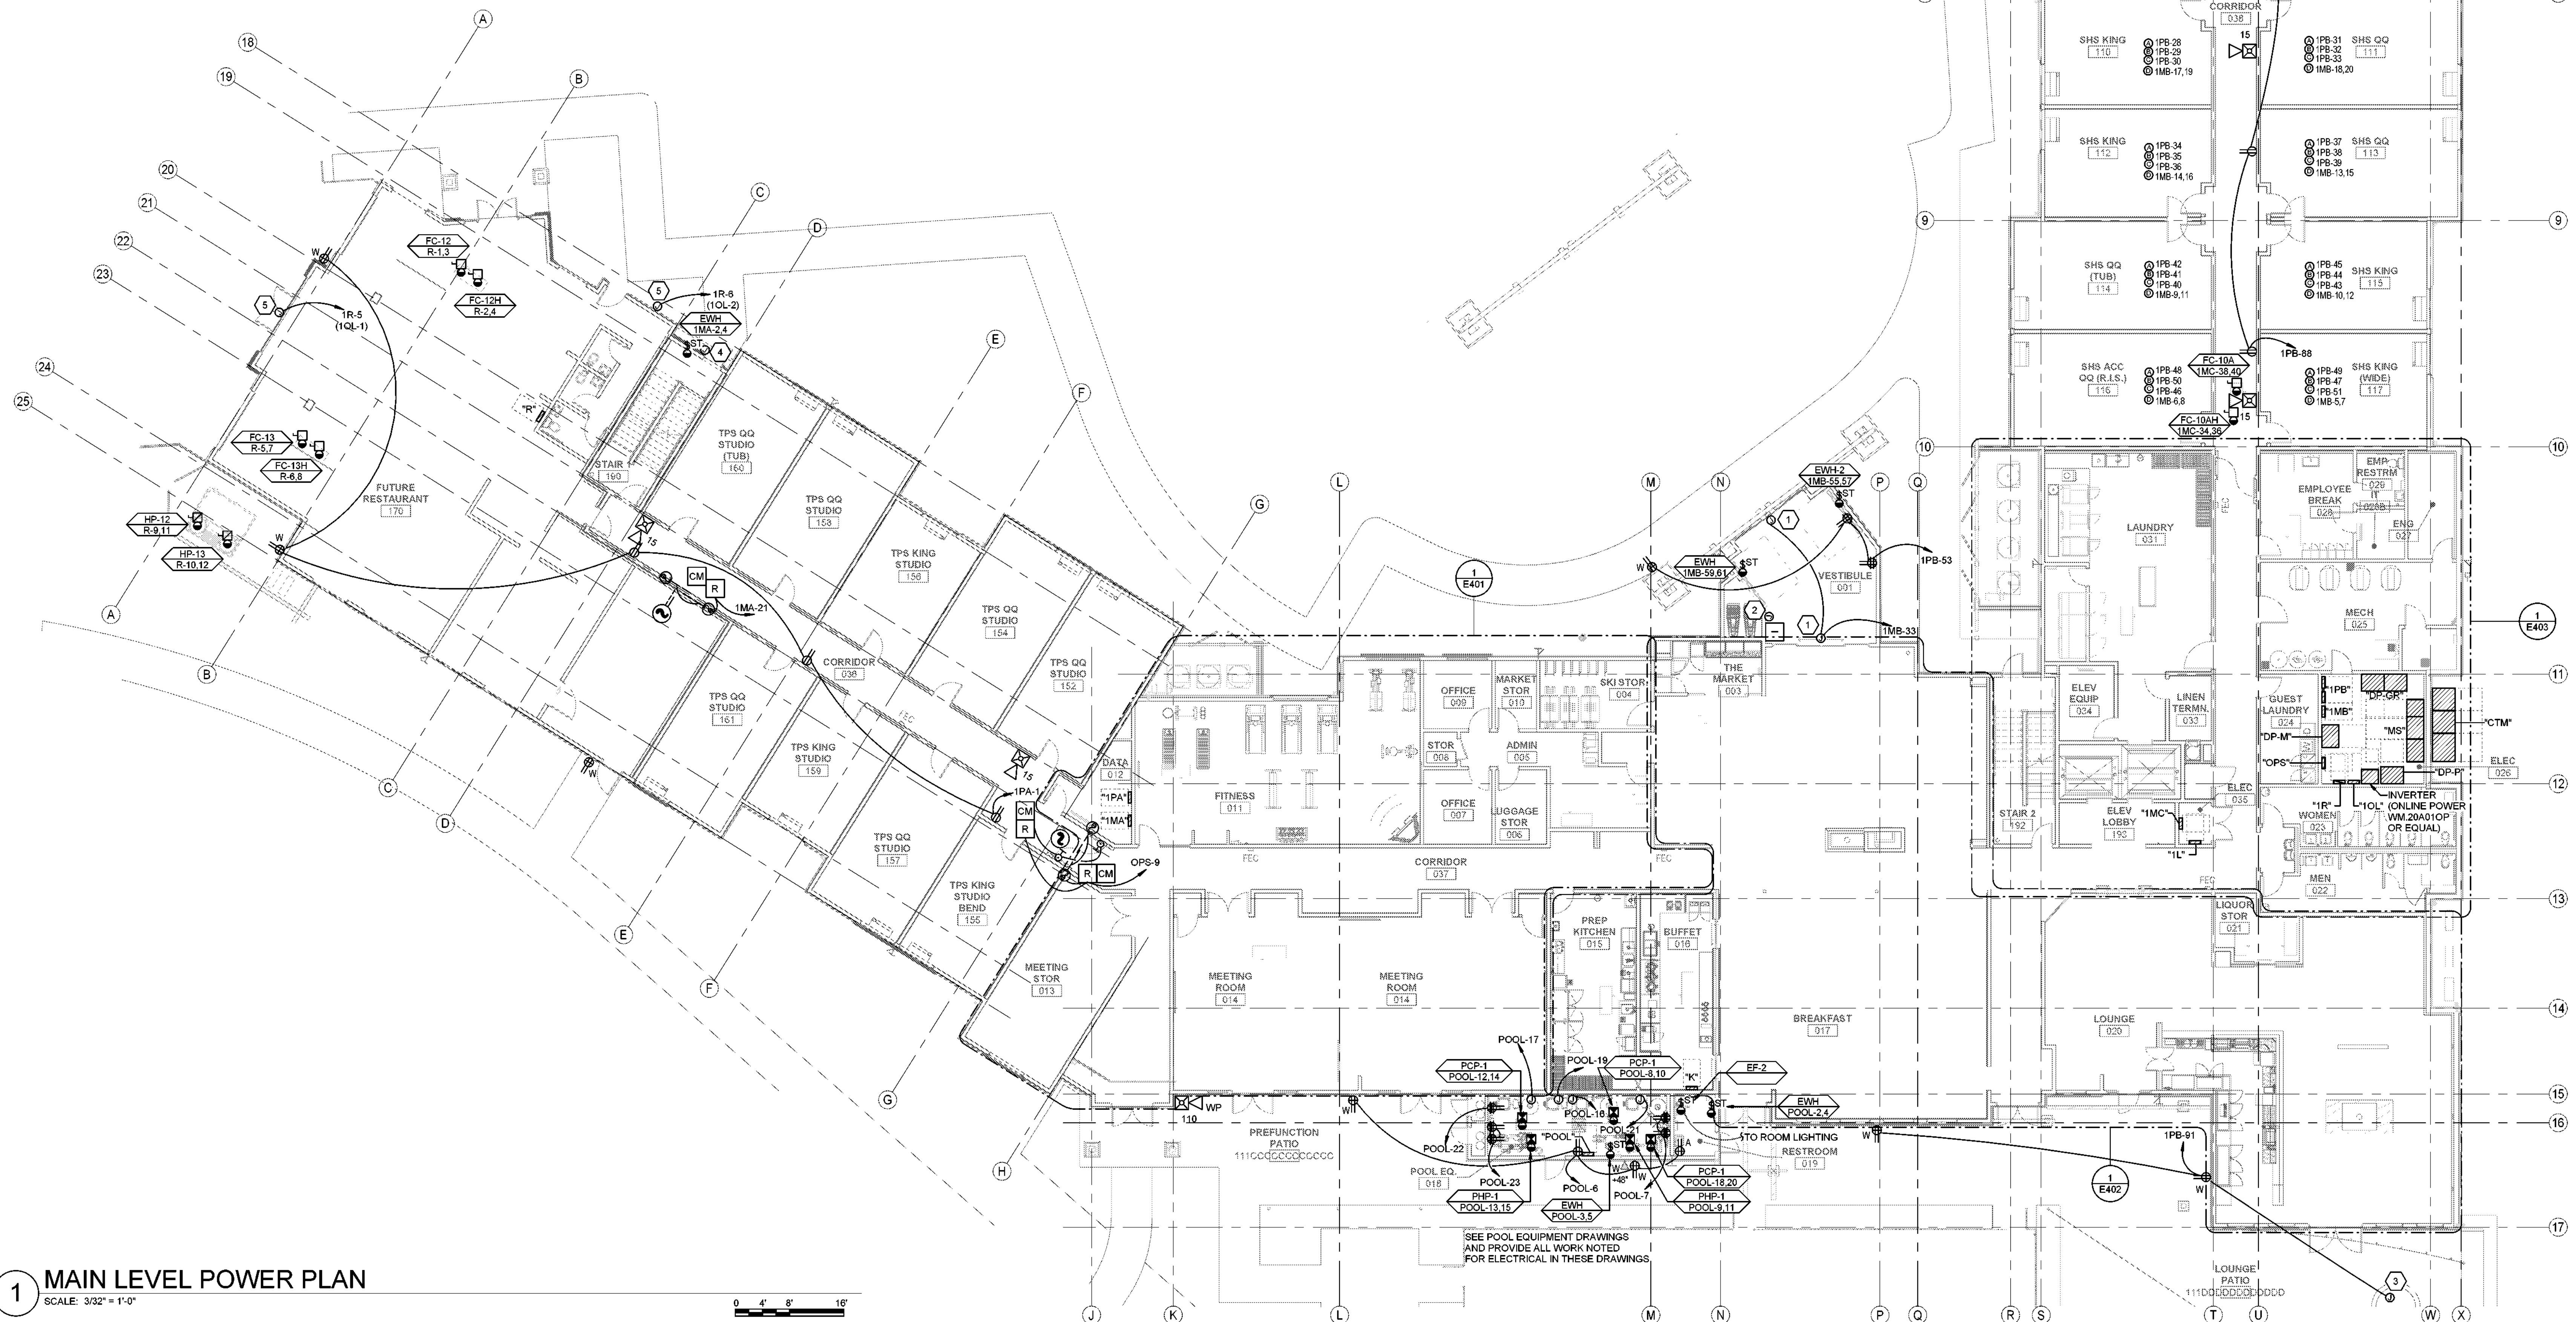


1 MAIN LEVEL POWER PLAN

SEE POOL EQUIPMENT DRAWINGS
AND PROVIDE ALL WORK NOTED
FOR ELECTRICAL IN THESE DRAWINGS



**THE
RICHARDSON
DESIGN
PARTNERSHIP,
L.L.C.**
510 South 600 East
Salt Lake City, Utah 84102
P: 801.355.6868
F: 801.355.6880

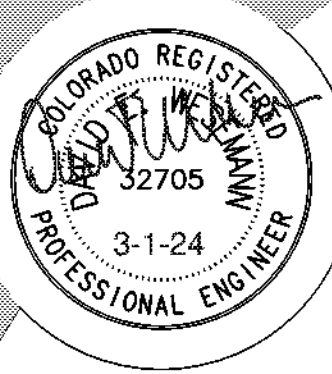

SPECTRUM
ENGINEERS
324 S. State St., Suite 400
Salt Lake City, UT 84111
800-678-7077
801-328-5151
fax: 801-328-5155
www.spectrum-engineers.com

CONSULTANT:

SERAC CAPITAL PARTNERS, LLC

5051 WESTHEIMER RD. SUITE 1750
HOUSTON, TX 77056

OWNER:

CENTRAL PARK HOTEL

1760 Central Park Dr.
Steamboat Springs, CO

PROJECT:

ISSUE DATE	DESCRIPTION
3/04/2024	PERMIT SET
EV. DATE	DESCRIPTION

PERMIT SET

MAIN LEVEL POWER PLAN

PROJECT #: 22-170
DRAWN BY: RRPDS
CHECKED BY: DGL

E101

3/1/2024 5:33:47 PM
Autodesk Docs://22-170 SHS - Steamboat Springs CO/230357-Elec Central.rvt

GENERAL SHEET NOTES		SHEET KEYNOTES	
1	ALL GUEST ROOM RECEPTACLES SHALL BE TAMPER RESISTANT.	1	PROVIDE ALPHA RCB2100SFR 2-WAY CALL BOX WITH INTERCONNECT WIRING TO THE MASTER STATION AT THE FRONT DESK ON LEVEL 1.
2	PROVIDE PUTTY PACKS AROUND BOXES IN PARTY WALLS.		
3	VERIFY PTAC OUTLET LOCATIONS WITH EQUIPMENT SHOP DRAWINGS.		
4	ALL HORNS IN GUEST ROOMS SHALL BE LOW-FREQUENCY TYPE.		
5	PROVIDE GUEST MANAGEMENT ROOM SYSTEM FOR ALL ROOMS. SEE DRAWINGS FROM MARRIOTT FOR REQUIREMENTS AND PROVIDE ALL PARTS AND WIRING AND SYSTEMS AND PROGRAMMING SHOWN IN THESE DOCUMENTS		



**THE
RICHARDSON
DESIGN
PARTNERSHIP,
L.L.C.**
510 South 600 East
Salt Lake City, Utah 84102
P: 801.355.6868
F: 801.355.6880



THE GRAPHIC MATERIAL AND DESIGN ON THIS SHEET ARE INSTRUMENTS OF SERVICE AND REMAIN AT ALL TIMES THE PROPERTY OF THE RICHARDSON/DESIGN PARTNERSHIP, L.L.C. REPRODUCTION OR USE OF THE MATERIAL AND DESIGN CONTAINED HEREIN IS PROHIBITED WITHOUT THE WRITTEN CONSENT OF THE RICHARDSON/DESIGN PARTNERSHIP, L.L.C.

© 2020 THE RICHARDSON/DESIGN PARTNERSHIP, L.L.C. ALL RIGHTS RESERVED

 **SPECTRUM**
ENGINEERS
324 S. State St., Suite 400
Salt Lake City, UT 84111
800-678-7077
801-328-5151
fax: 801-328-5155
www.spectrum-engineers.com

CONSULTANT:

SERAC CAPITAL PARTNERS, LLC
5051 WESTHEIMER RD. SUITE 1750
HOUSTON, TX 77056

OWNER:

CENTRAL PARK HOTEL

ISSUE DATE	DESCRIPTION
04/2024	PERMIT SET
REV. DATE	DESCRIPTION

[illegible]

PROJECT #: 22-170
DRAWN BY: RRRDGH
CHECKED BY: DGH


**SECOND LE
POWER PL**


E102

GENERAL SHEET NOTES	SHEET KEYNOTES
1 ALL GUEST ROOM RECEPTACLES SHALL BE TAMPER RESISTANT. 2 PROVIDE PUTTY PACKS AROUND BOXES IN PARTY WALLS. 3 VERIFY PTAC OUTLET LOCATIONS WITH EQUIPMENT SHOP DRAWINGS. 4 ALL HORNS IN GUEST ROOMS SHALL BE LOW-FREQUENCY TYPE. 5 PROVIDE GUEST MANAGEMENT ROOM SYSTEM FOR ALL ROOMS. SEE DRAWINGS FROM MARRIOTT FOR REQUIREMENTS AND PROVIDE ALL PARTS AND WIRING AND SYSTEMS AND PROGRAMMING SHOWN IN THESE DOCUMENTS	1 PROVIDE ALPHA RCB2100SFR 2-WAY CALL BOX WITH INTERCONNECT WIRING TO THE MASTER STATION AT THE FRONT DESK ON LEVEL 1. 2 PROVIDE CONNECTIONS TO BUILDING SIGNAGE. COORDINATE ROUGH-IN LOCATION(S) WITH SIGNAGE INSTALLER.



1 THIRD LEVEL POWER PLAN
SCALE: 3/32" = 1'-0"

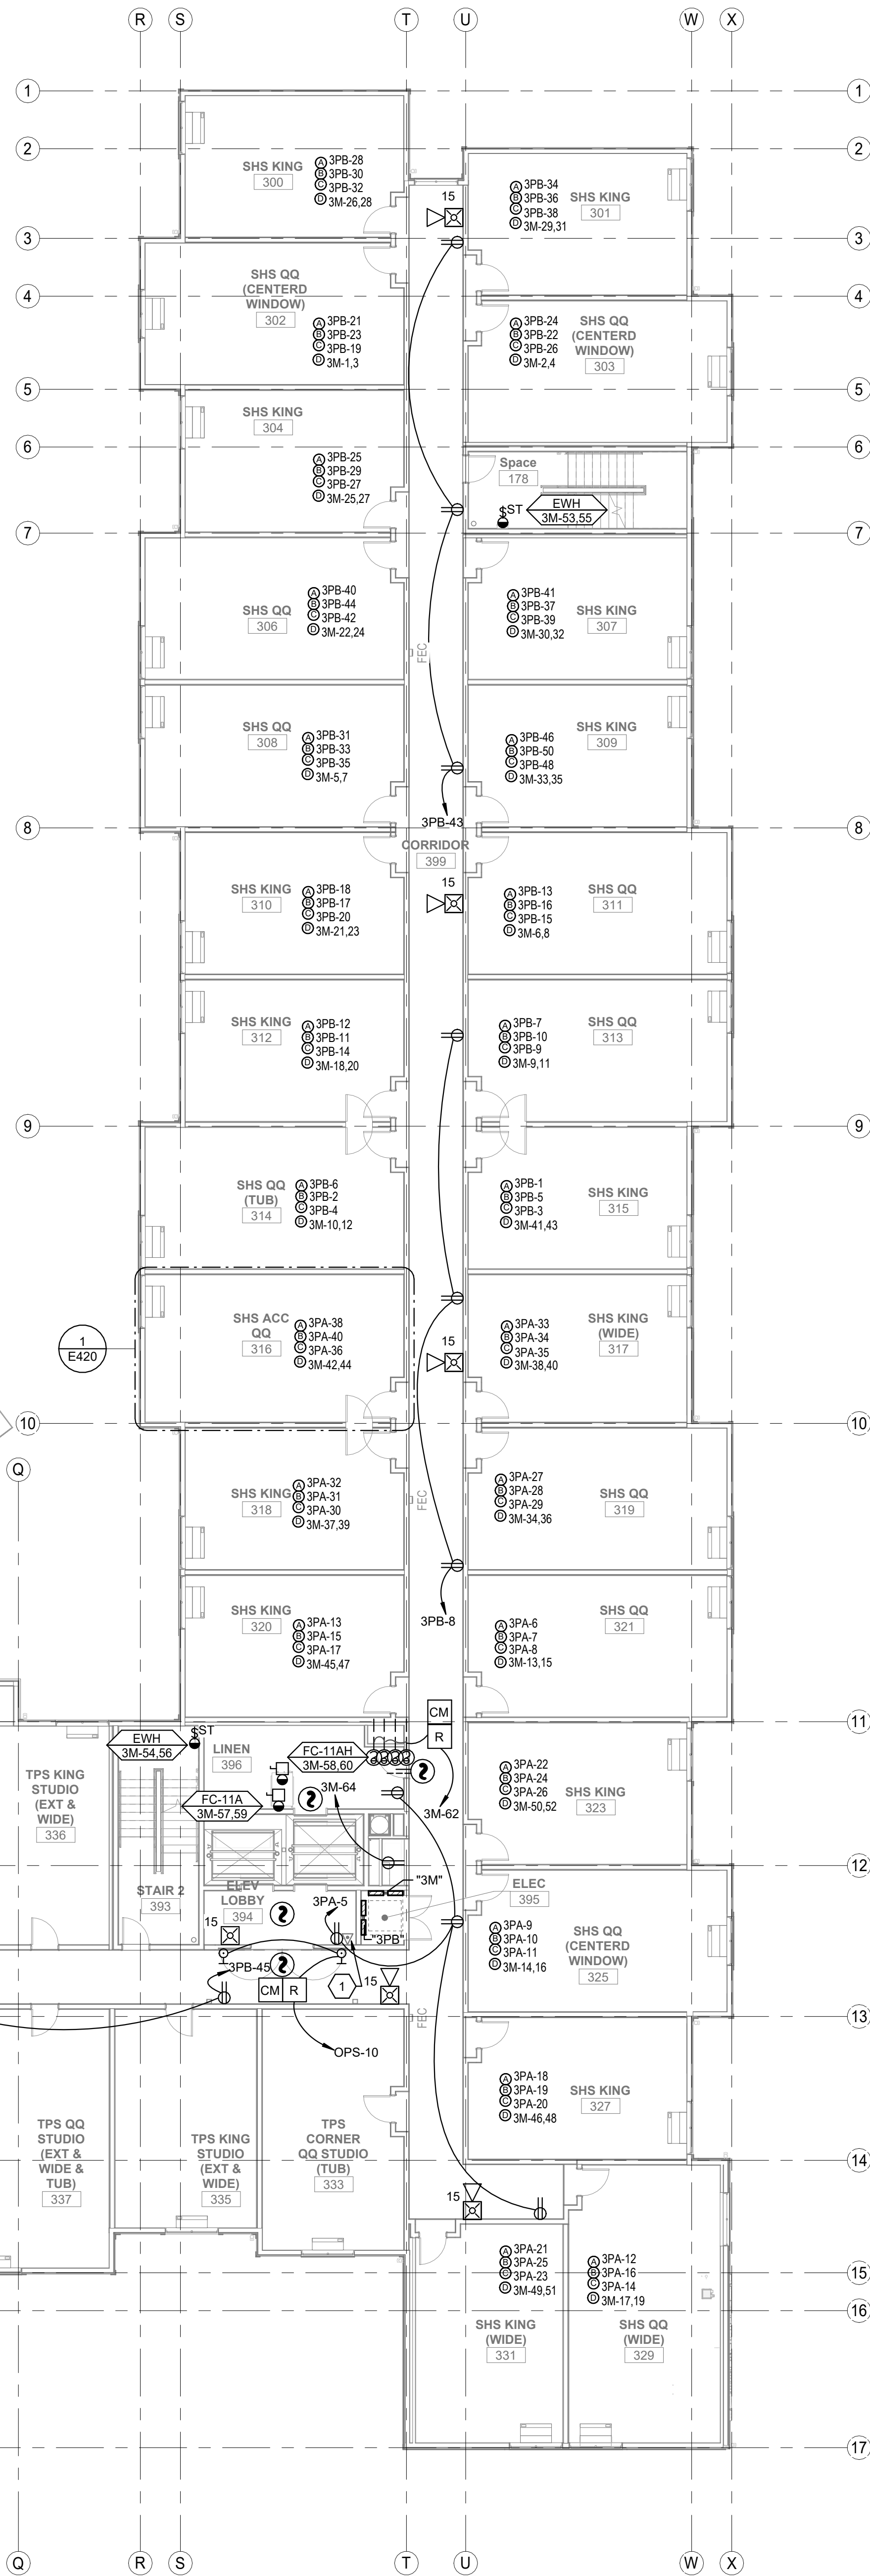

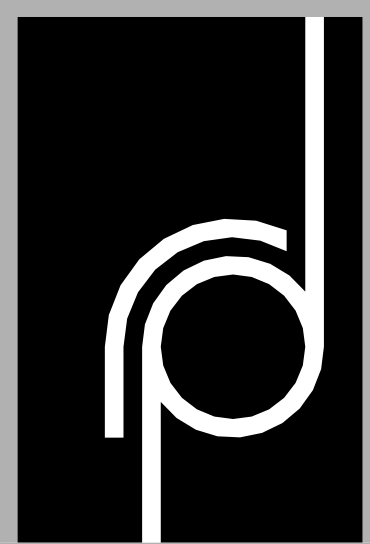

THE
RICHARDSON
DESIGN
PARTNERSHIP,
L.L.C.

510 South 600 East
Salt Lake City, Utah 84102
P: 801.355.6886
F: 801.355.6880



COLORADO REGISTERED
PROFESSIONAL ENGINEER
3-1-24
32705



SPECTRUM
ENGINEERS

324 S. State St., Suite 400
Salt Lake City, UT 84111
800-678-7077
801-328-5151
fax: 801-328-5155
www.spectrum-engineers.com

CONSULTANT:

SERAC CAPITAL PARTNERS, LLC

OWNER:

5051 WESTHEIMER RD. SUITE 1750
HOUSTON, TX 77056

PROJECT:

CENTRAL PARK HOTEL

1760 Central Park Dr.
Steamboat Springs, CO

ISSUE DATE 03/04/2024

DESCRIPTION PERMIT SET

REV. DATE DESCRIPTION

PERMIT SET

THIRD LEVEL POWER PLAN

E103

PROJECT # 2103

DRAWN BY: RRP028


CHECKED BY: DSB

SHEET #

SHEET KEYNOTES

- 1 ALL GUEST ROOM RECEPTACLES SHALL BE TAMPER RESISTANT.
2 PROVIDE PUTTY PACKS AROUND BOXES IN PARTY WALLS.
3 VERIFY PTAC OUTLET LOCATIONS WITH EQUIPMENT SHOP DRAWINGS.
4 ALL HORNS IN GUEST ROOMS SHALL BE LOW-FREQUENCY TYPE.
5 PROVIDE GUEST MANAGEMENT ROOM SYSTEM FOR ALL ROOMS. SEE
DRAWINGS FROM MARIOTT FOR REQUIREMENTS AND PROVIDE ALL PARTS
AND WIRING AND SYSTEMS AND PROGRAMMING SHOWN IN THESE
DOCUMENTS

- 1 PROVIDE ALPHA RCG2100SFR 2-WAY CALL BOX WITH INTERCONNECT WIRING TO THE MASTER STATION AT THE FRONT DESK ON LEVEL 1.
- 2 PROVIDE CONNECTIONS TO BUILDING SIGNAGE. COORDINATE ROUGH-IN LOCATION(S) WITH SIGNAGE INSTALLER.
- 3 PROVIDE 120V CIRCUIT TO JUNCTION BOX IN ROOF EAVE WITH 120V CIRCUIT FOR FUTURE HEAT TAPE.

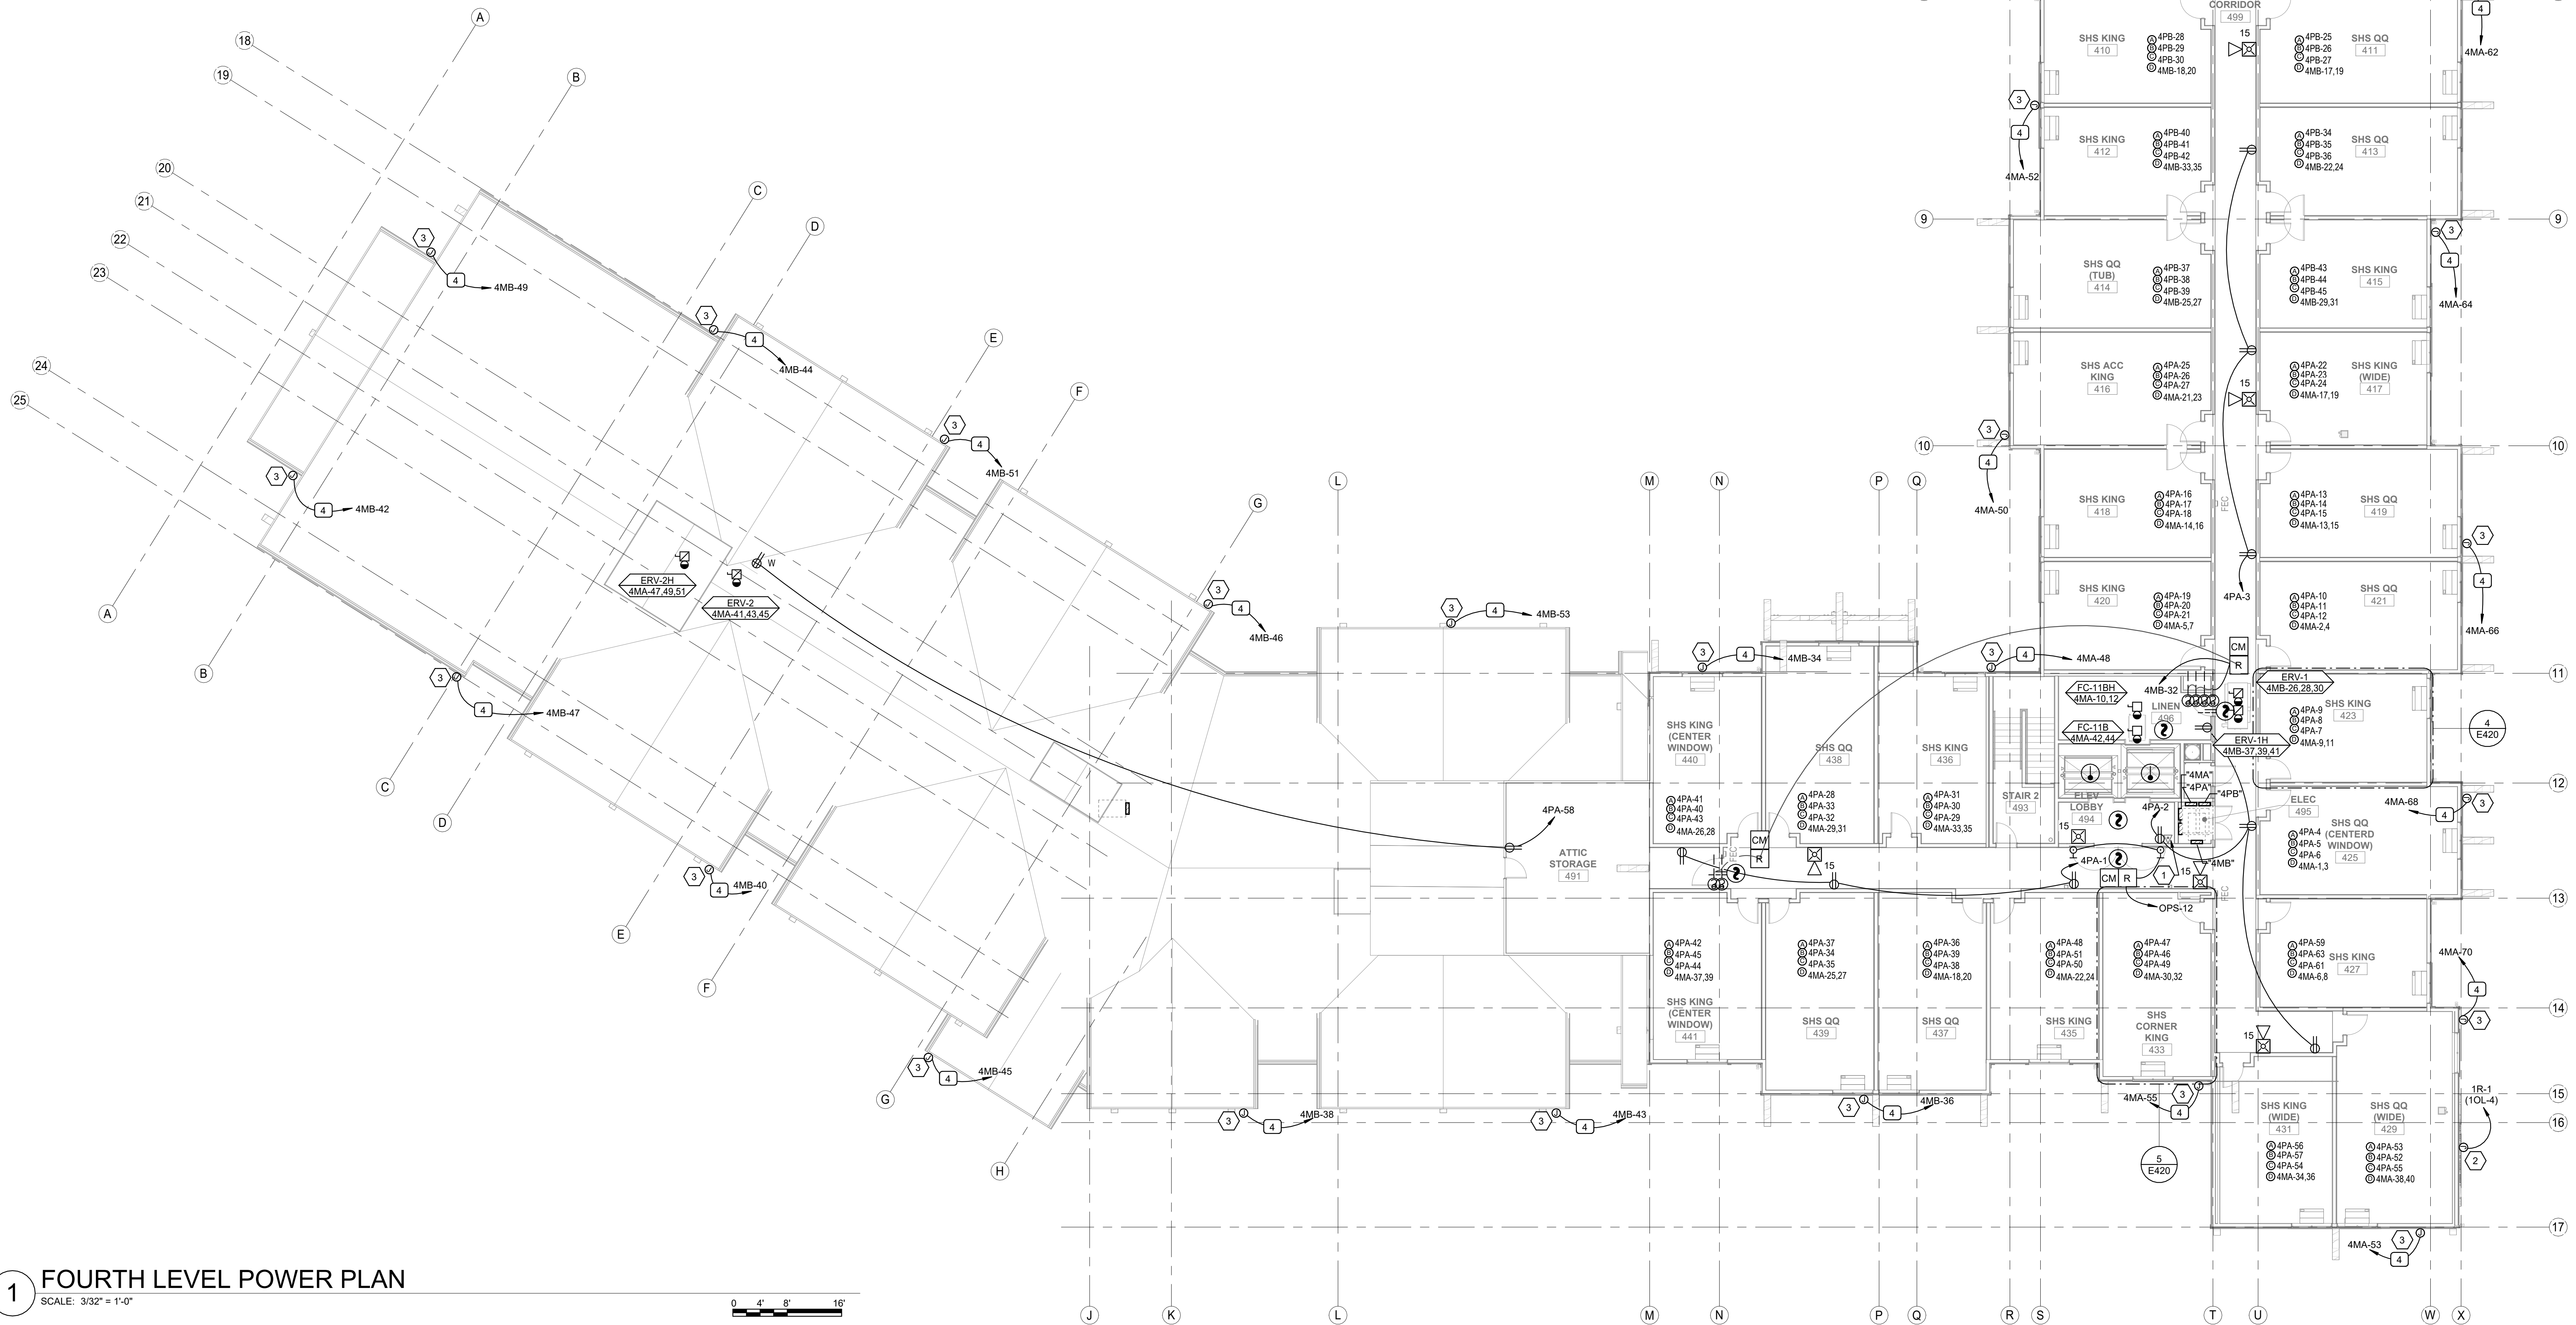

1 FOURTH LEVEL POWER PLAN

SCALE: 3/32" = 1'-0"

THE
RICHARDSON
DESIGN
PARTNERSHIP,
L.L.C.

510 South 600 East
Salt Lake City, Utah 84102
P: 801.355.6868
F: 801.355.6880

THE GRAPHIC MATERIAL AND DESIGN ON THIS SHEET ARE
 INSTRUMENTS OF SERVICE AND REMAIN AT ALL TIMES THE PROPERTY
 OF THE RICHARDSON DESIGN PARTNERSHIP, L.L.C. REPRODUCTION
 OR USE OF THE MATERIAL AND DESIGN CONTAINED HEREIN IS
 PROHIBITED WITHOUT THE WRITTEN CONSENT OF THE RICHARDSON
 DESIGN PARTNERSHIP, L.L.C.
 © 2008 THE RICHARDSON DESIGN PARTNERSHIP, L.L.C. ALL RIGHTS
 RESERVED



SPECTRUM
ENGINEERS

324 S. State St., Suite 400
Salt Lake City, UT 84111
800-678-7077
801-328-5151
fax: 801-328-5155
www.spectrum-engineers.com

CONSULTANT:

SERAC CAPITAL PARTNERS, LLC

5051 WESTHEIMER RD. SUITE 1750
HOUSTON, TX 77056

OWNER:

CENTRAL PARK HOTEL

1760 Central Park Dr.
Steamboat Springs, CO

PROJECT:

ISSUE DATE	DESCRIPTION
04/2024	PERMIT SET
W. DATE	DESCRIPTION

PERMIT SET

FOURTH LEVEL POWER PLAN

PROJECT #: 22-170
DRAWN BY: RRP/DSH
CHECKED BY: DGH

DRAWN BY: RRP/DGH
CHECKED BY: DGH

LIFT 3