


S:\PROJ\SMALL PROJECTS\2021 PROJECTS\Name Architecture\Providence Hall Addition\REVIT\PROVIDENCE HALL MEP.rvt

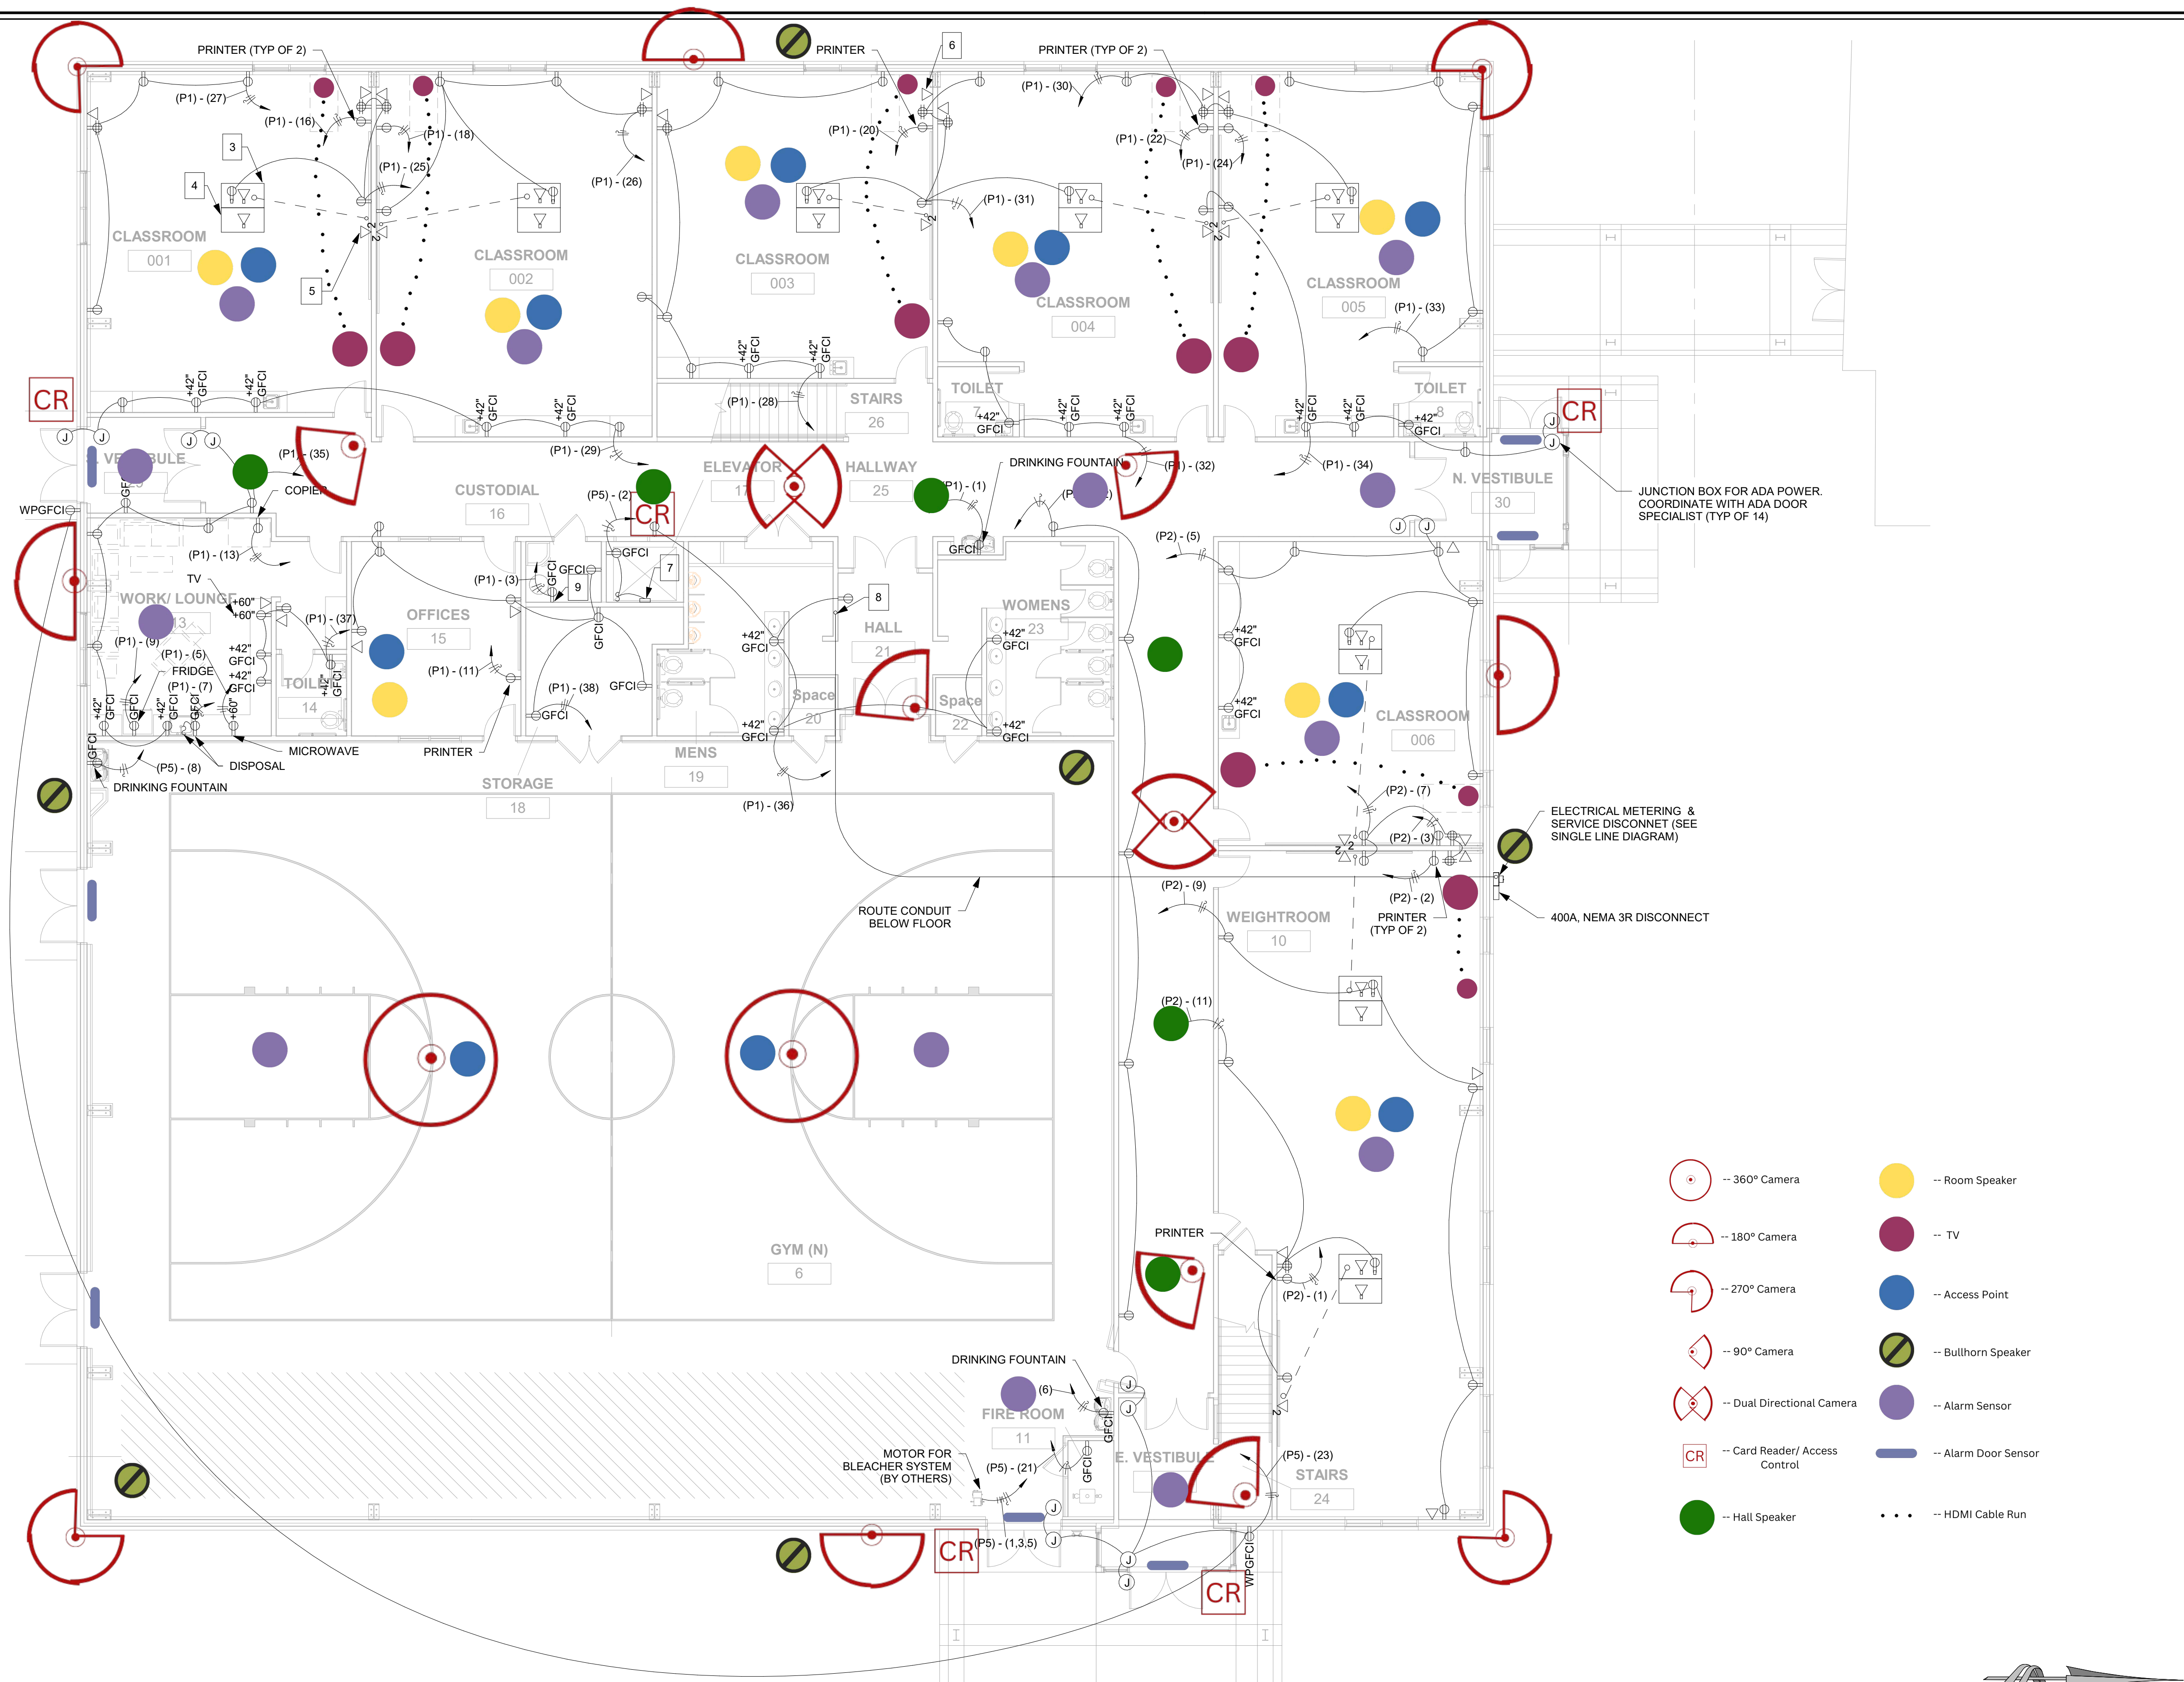

CONSTRUCTION NOTES

1. FIRE ALARM SYSTEM SHALL BE DESIGN-BUILD BY CONTRACTOR AND EQUIPMENT SUPPLIER.
2. LOW VOLTAGE SYSTEMS SHALL BE DESIGN-BUILD BY CONTRACTOR. CONFIRM ALL FIXTURE LOCATIONS SHOWN WITH OWNER.
3. POWER DATA & CONDUIT DROP AT CEILING FOR PROJECTOR/MEDIA (TYP EACH CLASSROOM)
4. ACCESS POINT IN CEILING (TYP EACH CLASSROOM)
5. DUAL DATA RECEPTACLE ABOVE WHITE BOARD (2 CABLE RUNS, TYP)
6. DATA RECEPTACLE (SEE DATA/ COMM RISER DETAIL) (TYP ALL)
7. ELEV PIT LIGHT W/ PROTECTIVE COVER PER MANUFACTURER REQUIREMENTS.
8. ROUTE CONDUIT UP TO LEVEL ABOVE.
9. POWER TO WATER HEATER & CIRCULATION PUMP.

DATE

JULY 2022




REVISIONS

MARK	DATE	DESCRIPTION

DRAWN: TMA
DESIGNER: TMA
REVIEWED: DIO


PROJECT #

00-00-000

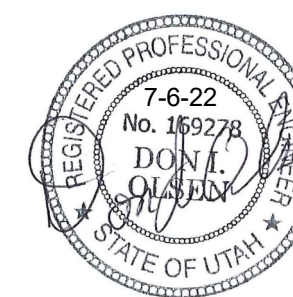

SCALES

As Indicated

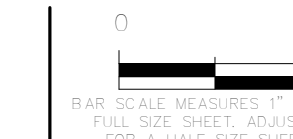

PROJECT NAME:

PROVIDENCE HALL - ADDITION

PROJECT LOCATION:

**4795 W PATRIOT RIDGE DR.
HERRIMAN UT, 84096**

SHEET TITLE:

**FIRST LEVEL
ELECTRICAL PLAN**

PLAN SET:

PERMIT

SHEET

E2.1

1 FIRST LEVEL ELECTRICAL PLAN
1/8" = 1'-0"