

# LOUISA COUNTY MIDDLE SCHOOL ADDITION

LOUISA COUNTY PUBLIC SCHOOLS

RRMM ARCHITECTS, PC

ARCHITECTURE / PLANNING / INTERIORS

2900 South Quincy Street, Suite 710  
Arlington, VA 22206  
(703) 998-0101

1317 Executive Boulevard, Suite 200  
Chesapeake, VA 23320  
(757) 622-2828


115 South 15th Street, Suite 502  
Richmond, VA 23219  
(804) 277-8987

28 Church Avenue SW  
Roanoke, VA 24011  
(540) 344-1212

1 Research Court, Suite 450  
Rockville, MD 20850  
(240) 403-4101

VOLUME 1 OF 1

VIRGINIA DEPARTMENT OF EDUCATION  
# 054-60-01-101

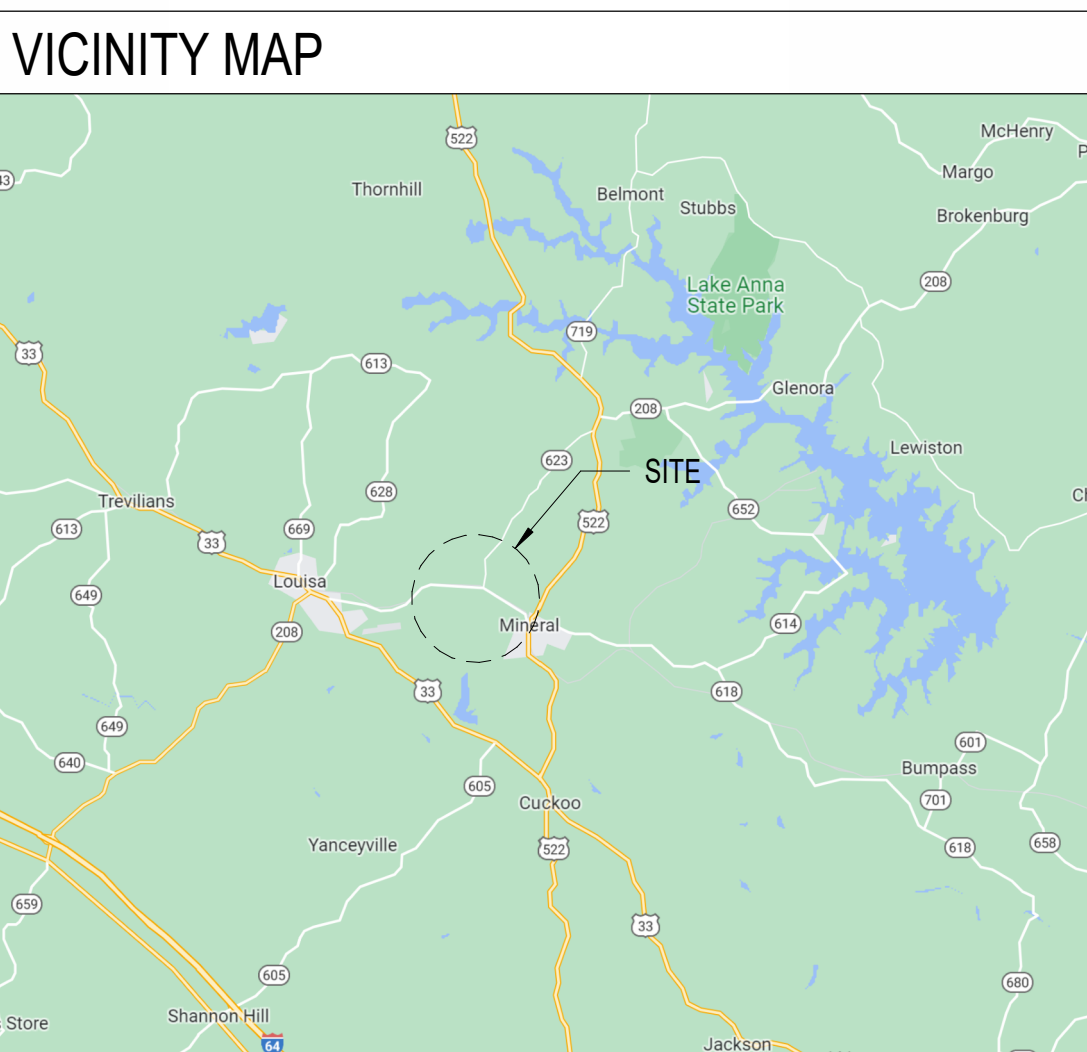

## CONSULTANTS

Timmons Group  
**CIVIL ENGINEERING**  
608 Preston Avenue, Suite 200  
Charlottesville, VA 22903  
Phone: (434) 295-5624


Speight Marshall Francis  
**STRUCTURAL ENGINEERING**  
2821 Emerywood Parkway, Suite 300  
Henrico, VA 23294  
Phone: (804) 464-4111

Simmons, Rockecharlie & Prince, Inc.  
**MEP ENGINEERING**  
10150 Staples Mill Road, Suite A  
Glen Allen, VA 23060  
Phone: (804) 262-7323

## OWNER


LOUISA COUNTY PUBLIC SCHOOLS  
Louisa County School Board  
953 Davis Highway  
Mineral, Virginia 23117

## LOCATION MAP

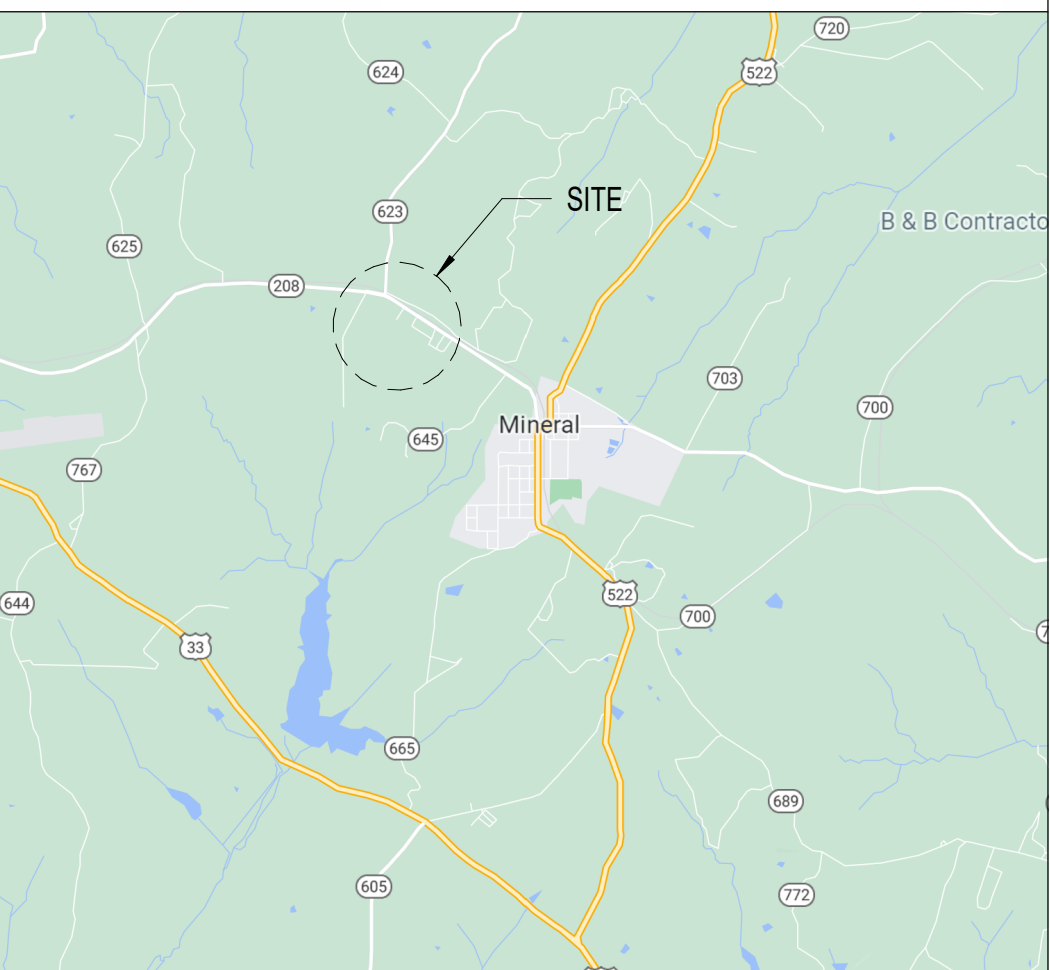

| DESCRIPTION |
|-------------|
| BY          |
| MARK DATE   |
| REVISIONS   |

|          |            |         |          |     |
|----------|------------|---------|----------|-----|
| DATE     | 8 APR 2024 | PROJECT | 23143-00 | JSC |
| DESIGNED |            | DRAWN   |          | JAS |
| CHECKED  |            |         |          | DJW |

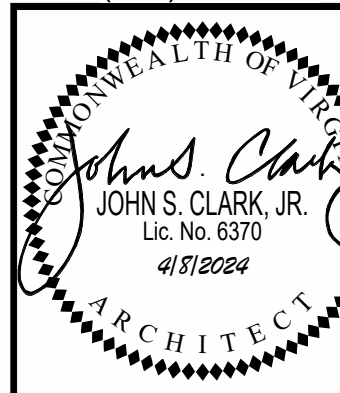

PROJECT LOUISA COUNTY PUBLIC SCHOOLS  
LOUISA COUNTY MIDDLE SCHOOL ADDITION  
1009 DAVIS HIGHWAY  
MINERAL, VIRGINIA  
DRAWING TITLE SHEET  
VIRGINIA DEPARTMENT OF EDUCATION 054-60-01-101

SHEET  
G-001





Autodesk Docs/23143-001 Louisa County MS Addition/23143-00 23 Louisa County MS Addition - ARCH-14

04/05/2024 14:15:31

# FIRST FLOOR REFLECTED CEILING PLAN - AREA A

 SCALE: 1/8" = 1'-0"

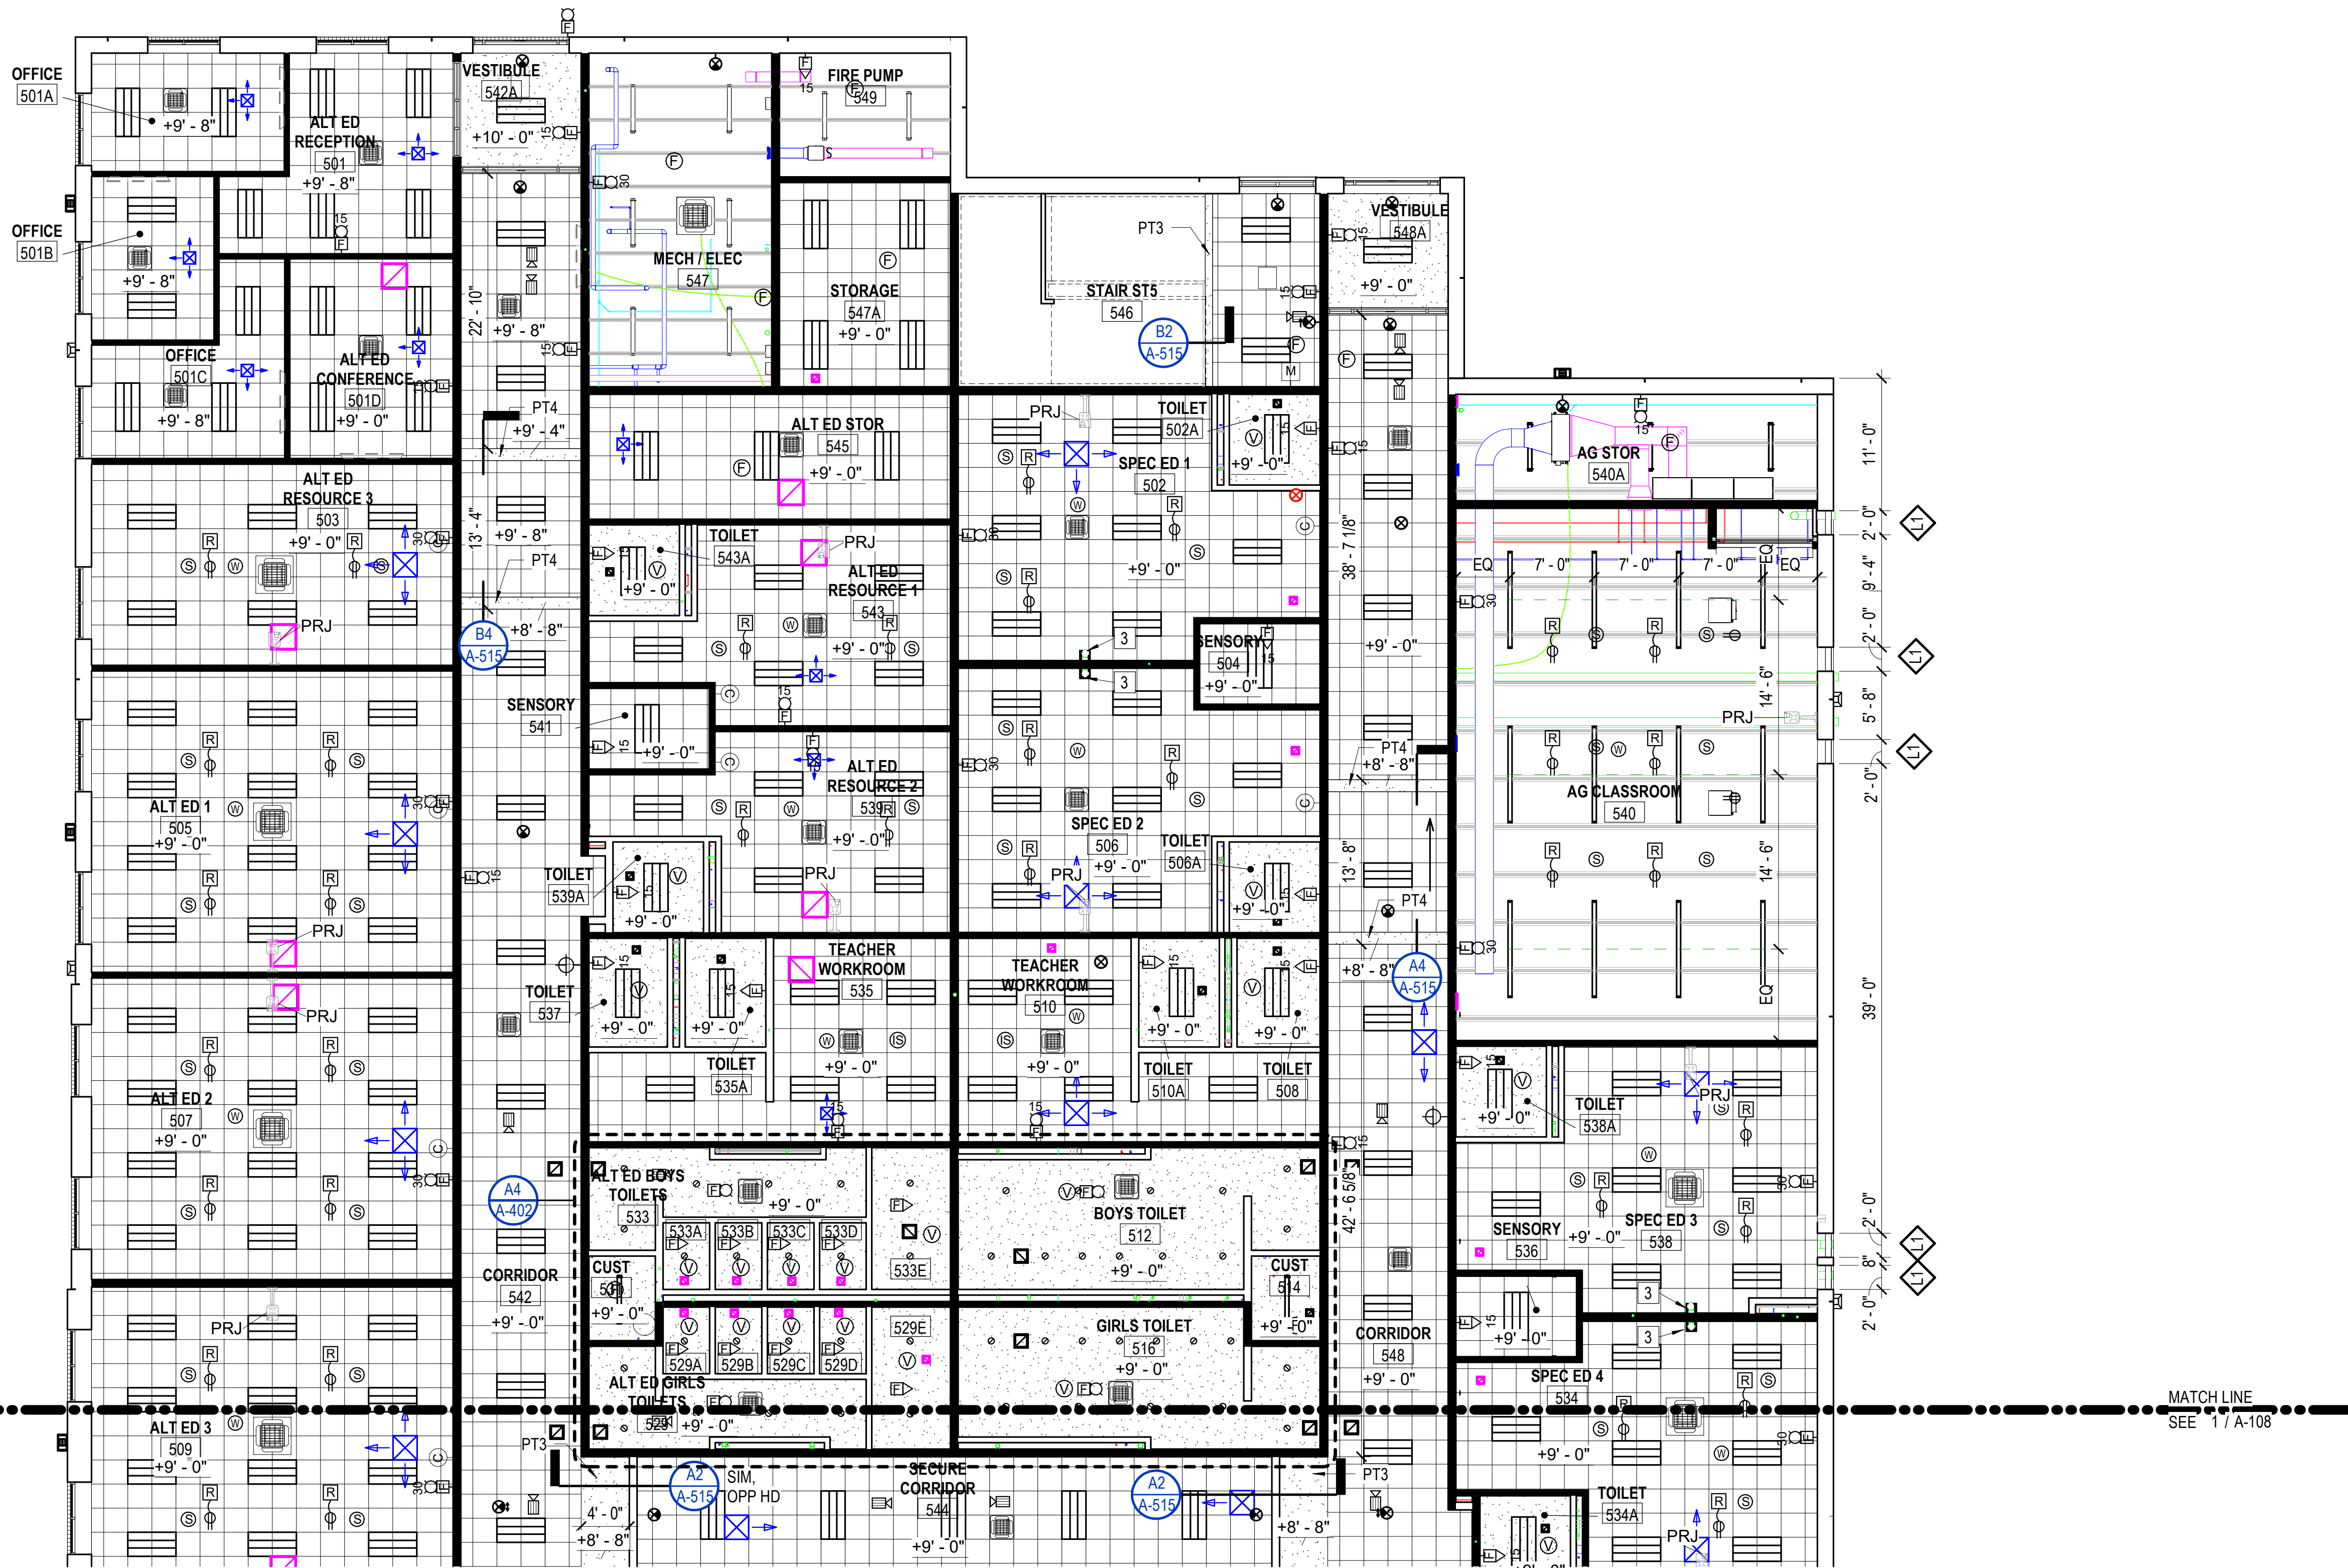

## REFLECTED CEILING PLAN LEGEND

|  |                                                                 |  |                                                    |
|--|-----------------------------------------------------------------|--|----------------------------------------------------|
|  | GYPSUM BOARD CEILING OR BULKHEAD                                |  | SUPPLY AIR - REF MECHANICAL DWGS                   |
|  | 2'-0" x 2'-0" LAY-IN ACOUSTICAL PANEL CEILING IN SUSPENDED GRID |  | RETURN AIR - REF MECHANICAL DWGS                   |
|  | CEILING HEIGHT - MEASURED FROM FINISHED FLOOR IN ROOM           |  | VRF SPLIT SYSTEM UNIT - REF MECHANICAL DWGS        |
|  | SLOPED CEILING                                                  |  | CORD REEL - REF ELECTRICAL DWGS                    |
|  | WALL MOUNTED SHORT THROW PROJECTOR (PRJ)                        |  | WIRELESS ACCESS POINT DEVICE - REF ELECTRICAL DWGS |
|  | CEILING PROJECTOR MOUNT                                         |  | INTERCOM SPEAKER - REF ELECTRICAL DWGS             |
|  | EXIT LIGHT                                                      |  | REINFORCEMENT SPEAKER - REF ELECTRICAL DWGS        |
|  | LIGHT FIXTURES                                                  |  | FIRE ALARM - REF ELECTRICAL DWGS                   |
|  | DOWN LIGHT                                                      |  | SECURITY CAMERA - REF ELECTRICAL DWGS              |
|  |                                                                 |  | CLOCK - REF ELECTRICAL DWGS                        |

## PARTITION TERMINATION LEGEND

|  |                                                                                                                                                                                                                                                                                                                         |
|--|-------------------------------------------------------------------------------------------------------------------------------------------------------------------------------------------------------------------------------------------------------------------------------------------------------------------------|
|  | PARTITION WHICH PENETRATES THE CLG & TERMINATES 12" ABOVE FINISHED CLG UON                                                                                                                                                                                                                                              |
|  | PARTITION WHICH CONTINUES THROUGH CLG TO BOTTOM OF ROOF DECK ABV (UNLESS NOTED OTHERWISE). AT GWB PARTITION, PROVIDE BATT INSUL IN VOIDS IN DECK FOR SOUND TRANSMISSION BLOCKING OR CONT SEALANT. REF SHEET A-002 FOR PARTITION TYPE LEGEND AND SHEET A-003 FOR TYPICAL TERMINATION DETAILS FOR ADDITIONAL INFORMATION. |


## REF CLG PLAN GENERAL NOTES

- REFER TO FLOOR PLANS AND WALL SECTIONS FOR ADDITIONAL INFORMATION.
- REFER TO ELECTRICAL LIGHTING PLANS FOR WALL MOUNTED AND UNDER-CABINET FIXTURES NOT INDICATED.
- SPRINKLER HEADS (NOT INDICATED) TO BE CENTERED IN SAPC OR WITHIN SPACE IN GYPSUM BOARD CEILING.
- REFER TO MECHANICAL AND ELECTRICAL DRAWINGS FOR CEILING-MOUNTED FIXTURE TYPES AND DIFFUSER LOCATIONS. NOTIFY ARCHITECT (PRIOR TO INSTALLATION) OF CONFLICTS WITH LOCATIONS INDICATED ON DRAWINGS. ADDITIONAL FIXTURES OR OTHER CEILING MATERIALS SHOWN ON ELECTRICAL OR MECHANICAL DRAWINGS, BUT NOT SHOWN ON RCP'S, ARE INCLUDED IN THE BASE BID.
- SUPPLY AND DIFFUSER GRILLES ARE INDICATED DIAGRAMMATICALLY IN RCP FOR LOCATION ONLY. REFER TO MECHANICAL DWGS FOR ACTUAL SIZE AND TYPE TO BE PROVIDED.
- 24"x24" ACOUSTICAL CEILING PANELS (SAPC) WILL BE THROUGHOUT.
- REFER TO SHEET A-003 FOR TYPICAL PARTITION TERMINATIONS AT STRUCTURAL ELEMENTS WITH ALL EXTENSIONS OF FINISHES AND SOUND ATTENUATION.
- PAINT ALL EXPOSED STRUCTURE. WORK TO INCLUDE, BUT NO LIMITED TO: JOISTS, BEAMS, COLUMNS, METAL DECK. REFER TO FINISH SCHEDULE FOR ADDITIONAL NOTES.
- PROVIDE ACCESS DOOR AND FRAME IN GYPSUM BOARD CEILINGS WHERE REQUIRED FOR CONCEALED EQUIPMENT, VALVES, AND OTHER ITEMS REQUIRING ACCESS FOR SERVICE AND MAINTENANCE. ACCESS DOOR SIZE AS REQUIRED PER EQUIPMENT MANUFACTURER'S REQUIREMENTS AND CLEARANCES. CONTRACTOR TO COORDINATE INSTALLATION LOCATION AND CLEARANCES WITH OTHER CEILING MOUNTED EQUIPMENT, FIXTURES, SPRINKLER HEADS, ETC.

## KEY NOTES - REF CLG PLAN

(APPLIES TO SHEETS A-107 THRU A-110)

- APPROXIMATE LOCATION OF CEILING PROJECTOR AND MOUNTS. ALL HARDWARE AND MOUNTING EQUIPMENT TO BE PROVIDED BY CONTRACTOR. PROJECTOR TO BE PROVIDED BY OWNER AND INSTALLED BY CONTRACTOR. COORDINATE FINAL LOCATION WITH ELECTRICAL DRAWINGS AND PROJECTION SCREEN MANUFACTURER
- RECESSED MOTORIZED PROJECTION SCREEN - REF DETAIL C1/A-515 AND SPECIFICATION 115213 FOR ADDITIONAL INFO
- PLAM DUCT ENCLOSURE. BEGIN AT TOP OF CASEWORK CABINET AND TERMINATE AT BOTTOM OF CEILING - COORDINATE WITH RANGE HOOD, ARCHITECTURAL CASEWORK DIMENSIONS, AND MECHANICAL DRAWINGS. REFER TO DETAIL A5/A-801
- ROOF HATCH AND SAFETY RAILS - REFER TO SECTION C3/A-522 COORDINATE EXACT LOCATION WITH ROOF JOISTS.
- EFS SOFFIT

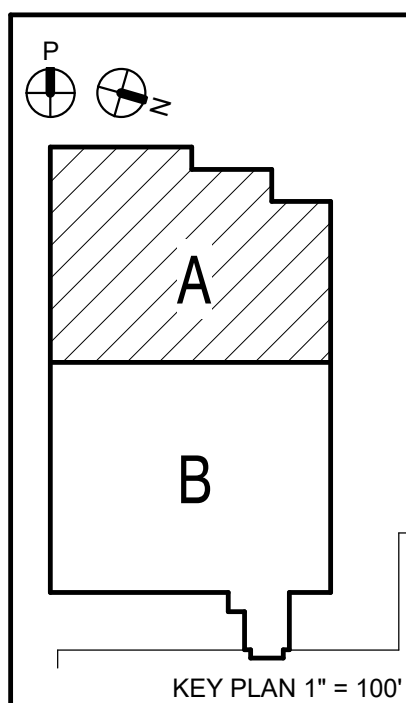

LOUISA COUNTY PUBLIC SCHOOLS  
LOUISA COUNTY MIDDLE SCHOOL ADDITION  
1009 DAVIS HIGHWAY  
MINERAL, VIRGINIA  
DRAWING FIRST FLOOR REFLECTED CEILING PLAN - AREA A

SHEET

A-107

**RRMM**  
ARCHITECTS, P.C.  
115 South 15th Street, Suite 502  
Richmond, Virginia 23219  
(804)277-8987

JOHN S. CLARK, JR.  
LE No. 6370  
4/15/2024  
ARCHITECT

| DATE       | PROJECT  | DESIGNED | DRAWN | CHECKED |
|------------|----------|----------|-------|---------|
| 8 APR 2024 | 23143-00 | JSC      | JAS   | DJW     |



REF CLG GENERAL WORK NOTES

REFER TO SHEET A-107

KEY NOTES - REF CLG PLAN


REFER TO SHEET A-107

REF CLG PLAN LEGEND


REFER TO SHEET A-107

| DESCRIPTION |
|-------------|
| BY          |
| DATE        |
| REVISIONS   |

|          |            |         |          |     |     |     |
|----------|------------|---------|----------|-----|-----|-----|
| DATE     | 8 APR 2024 | PROJECT | 23143-00 | JSC | JAS | DJW |
| DESIGNED |            | DRAWN   |          |     |     |     |
| CHECKED  |            |         |          |     |     |     |

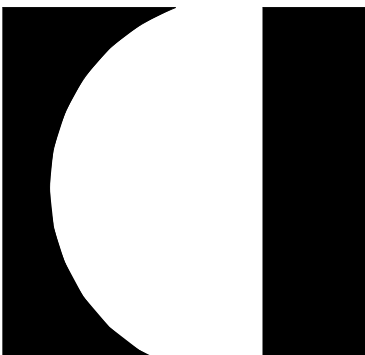

**RRMM**  
ARCHITECTS, PC  
115 South 15<sup>th</sup> Street, Suite 502  
Richmond, Virginia 23219  
(804)277-8987

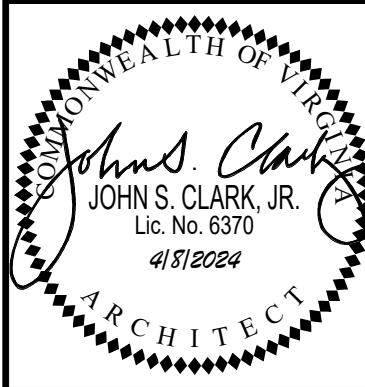

JOHN S. CLARK, JR.  
LE No. 6370  
4/15/2024  
ARCHITECT


LOUISA COUNTY PUBLIC SCHOOLS  
LOUISA COUNTY MIDDLE SCHOOL ADDITION  
1009 DAVIS HIGHWAY  
MINERAL, VIRGINIA

VIRGINIA DEPARTMENT OF EDUCATION 054-6001-101

FIRST FLOOR REFLECTED CEILING PLAN - AREA B


SHEET

**A-108**

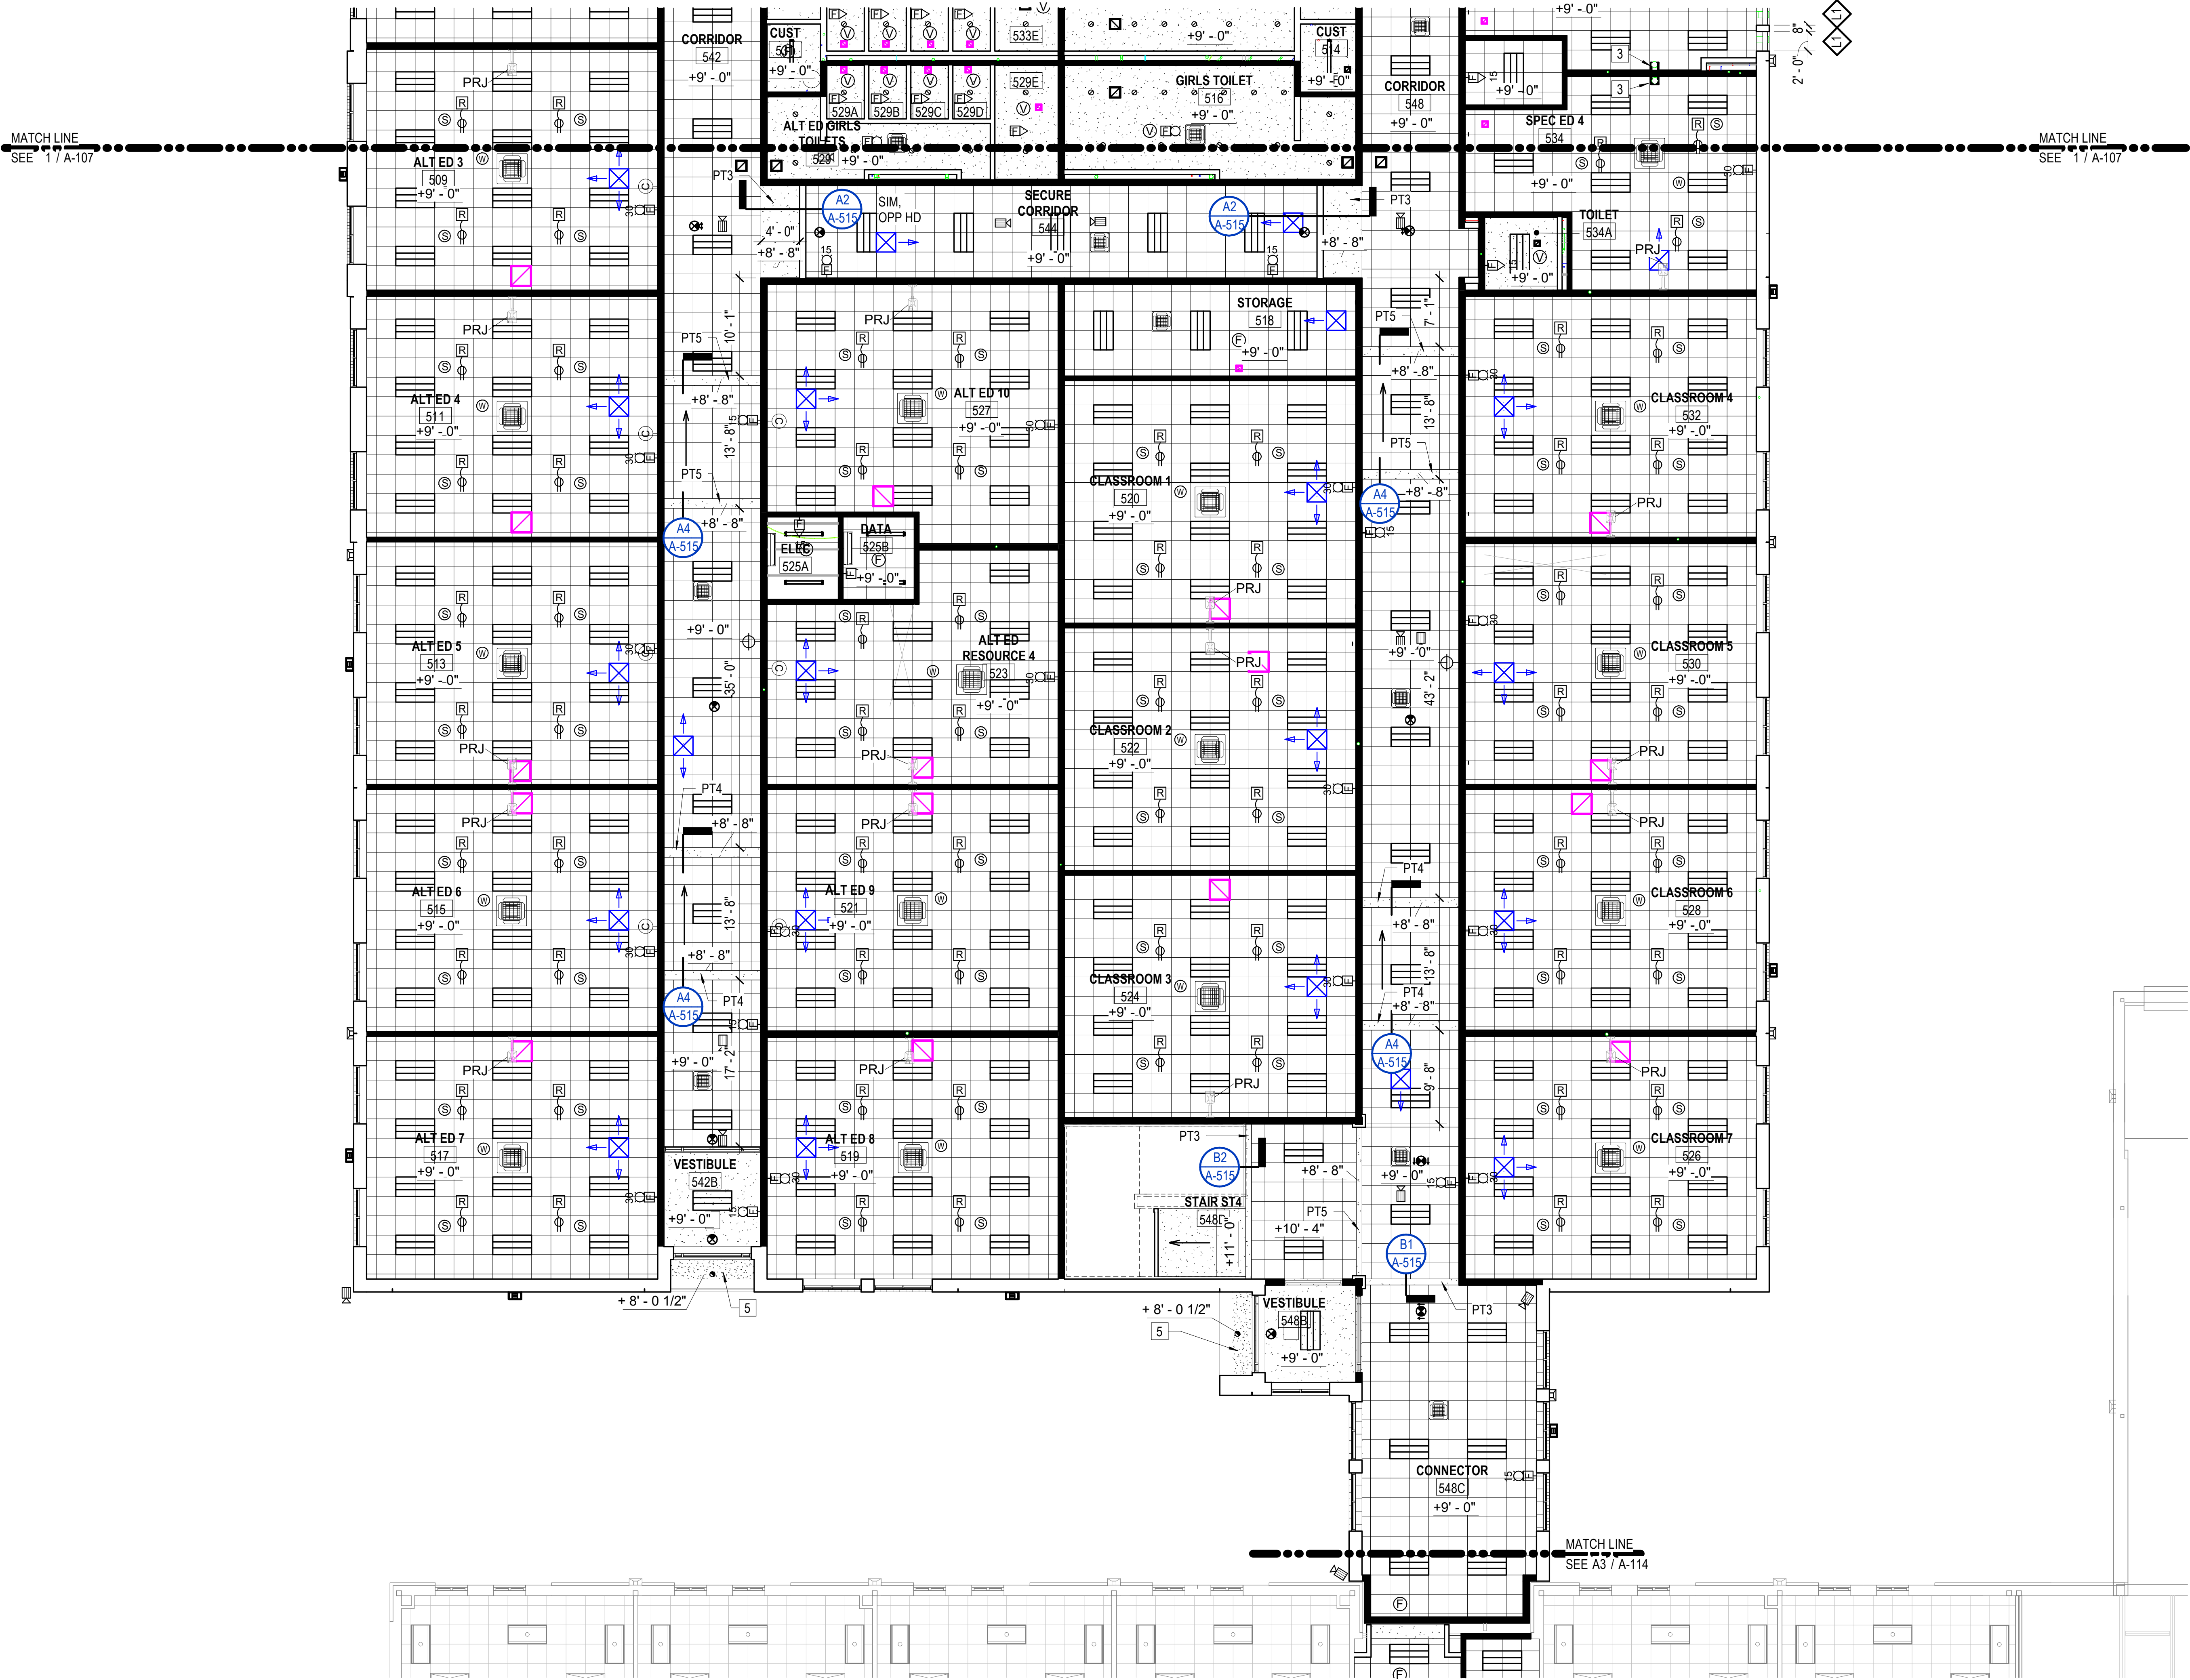

FIRST FLOOR REFLECTED CEILING PLAN - AREA B

SCALE: 1/8" = 1'-0"

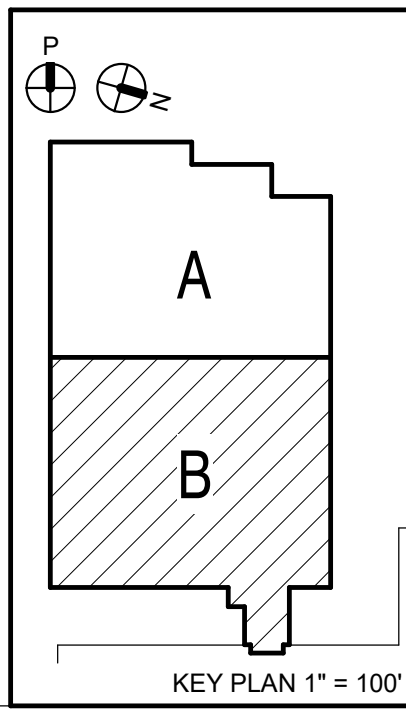




REFER TO SHEET A-107

| MARK | DATE | BY | DESCRIPTION |
|------|------|----|-------------|
|      |      |    |             |


|          |          |
|----------|----------|
| PROJECT  | 23143-00 |
| DESIGNED | JSC      |
| DRAWN    | JAS      |
| CHECKED  | DJW      |

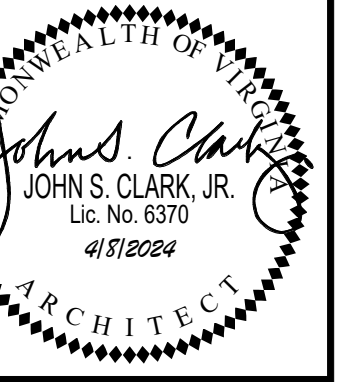



LOUISA COUNTY MIDDLE SCHOOL ADDITION  
1009 DAVIS HIGHWAY  
MINERAL, VIRGINIA  
VIRGINIA DEPARTMENT OF EDUCATION: 054-60-01-101  
DRAWING SECOND FLOOR REFLECTED CEILING PLAN - AREA A

HEET

A-109

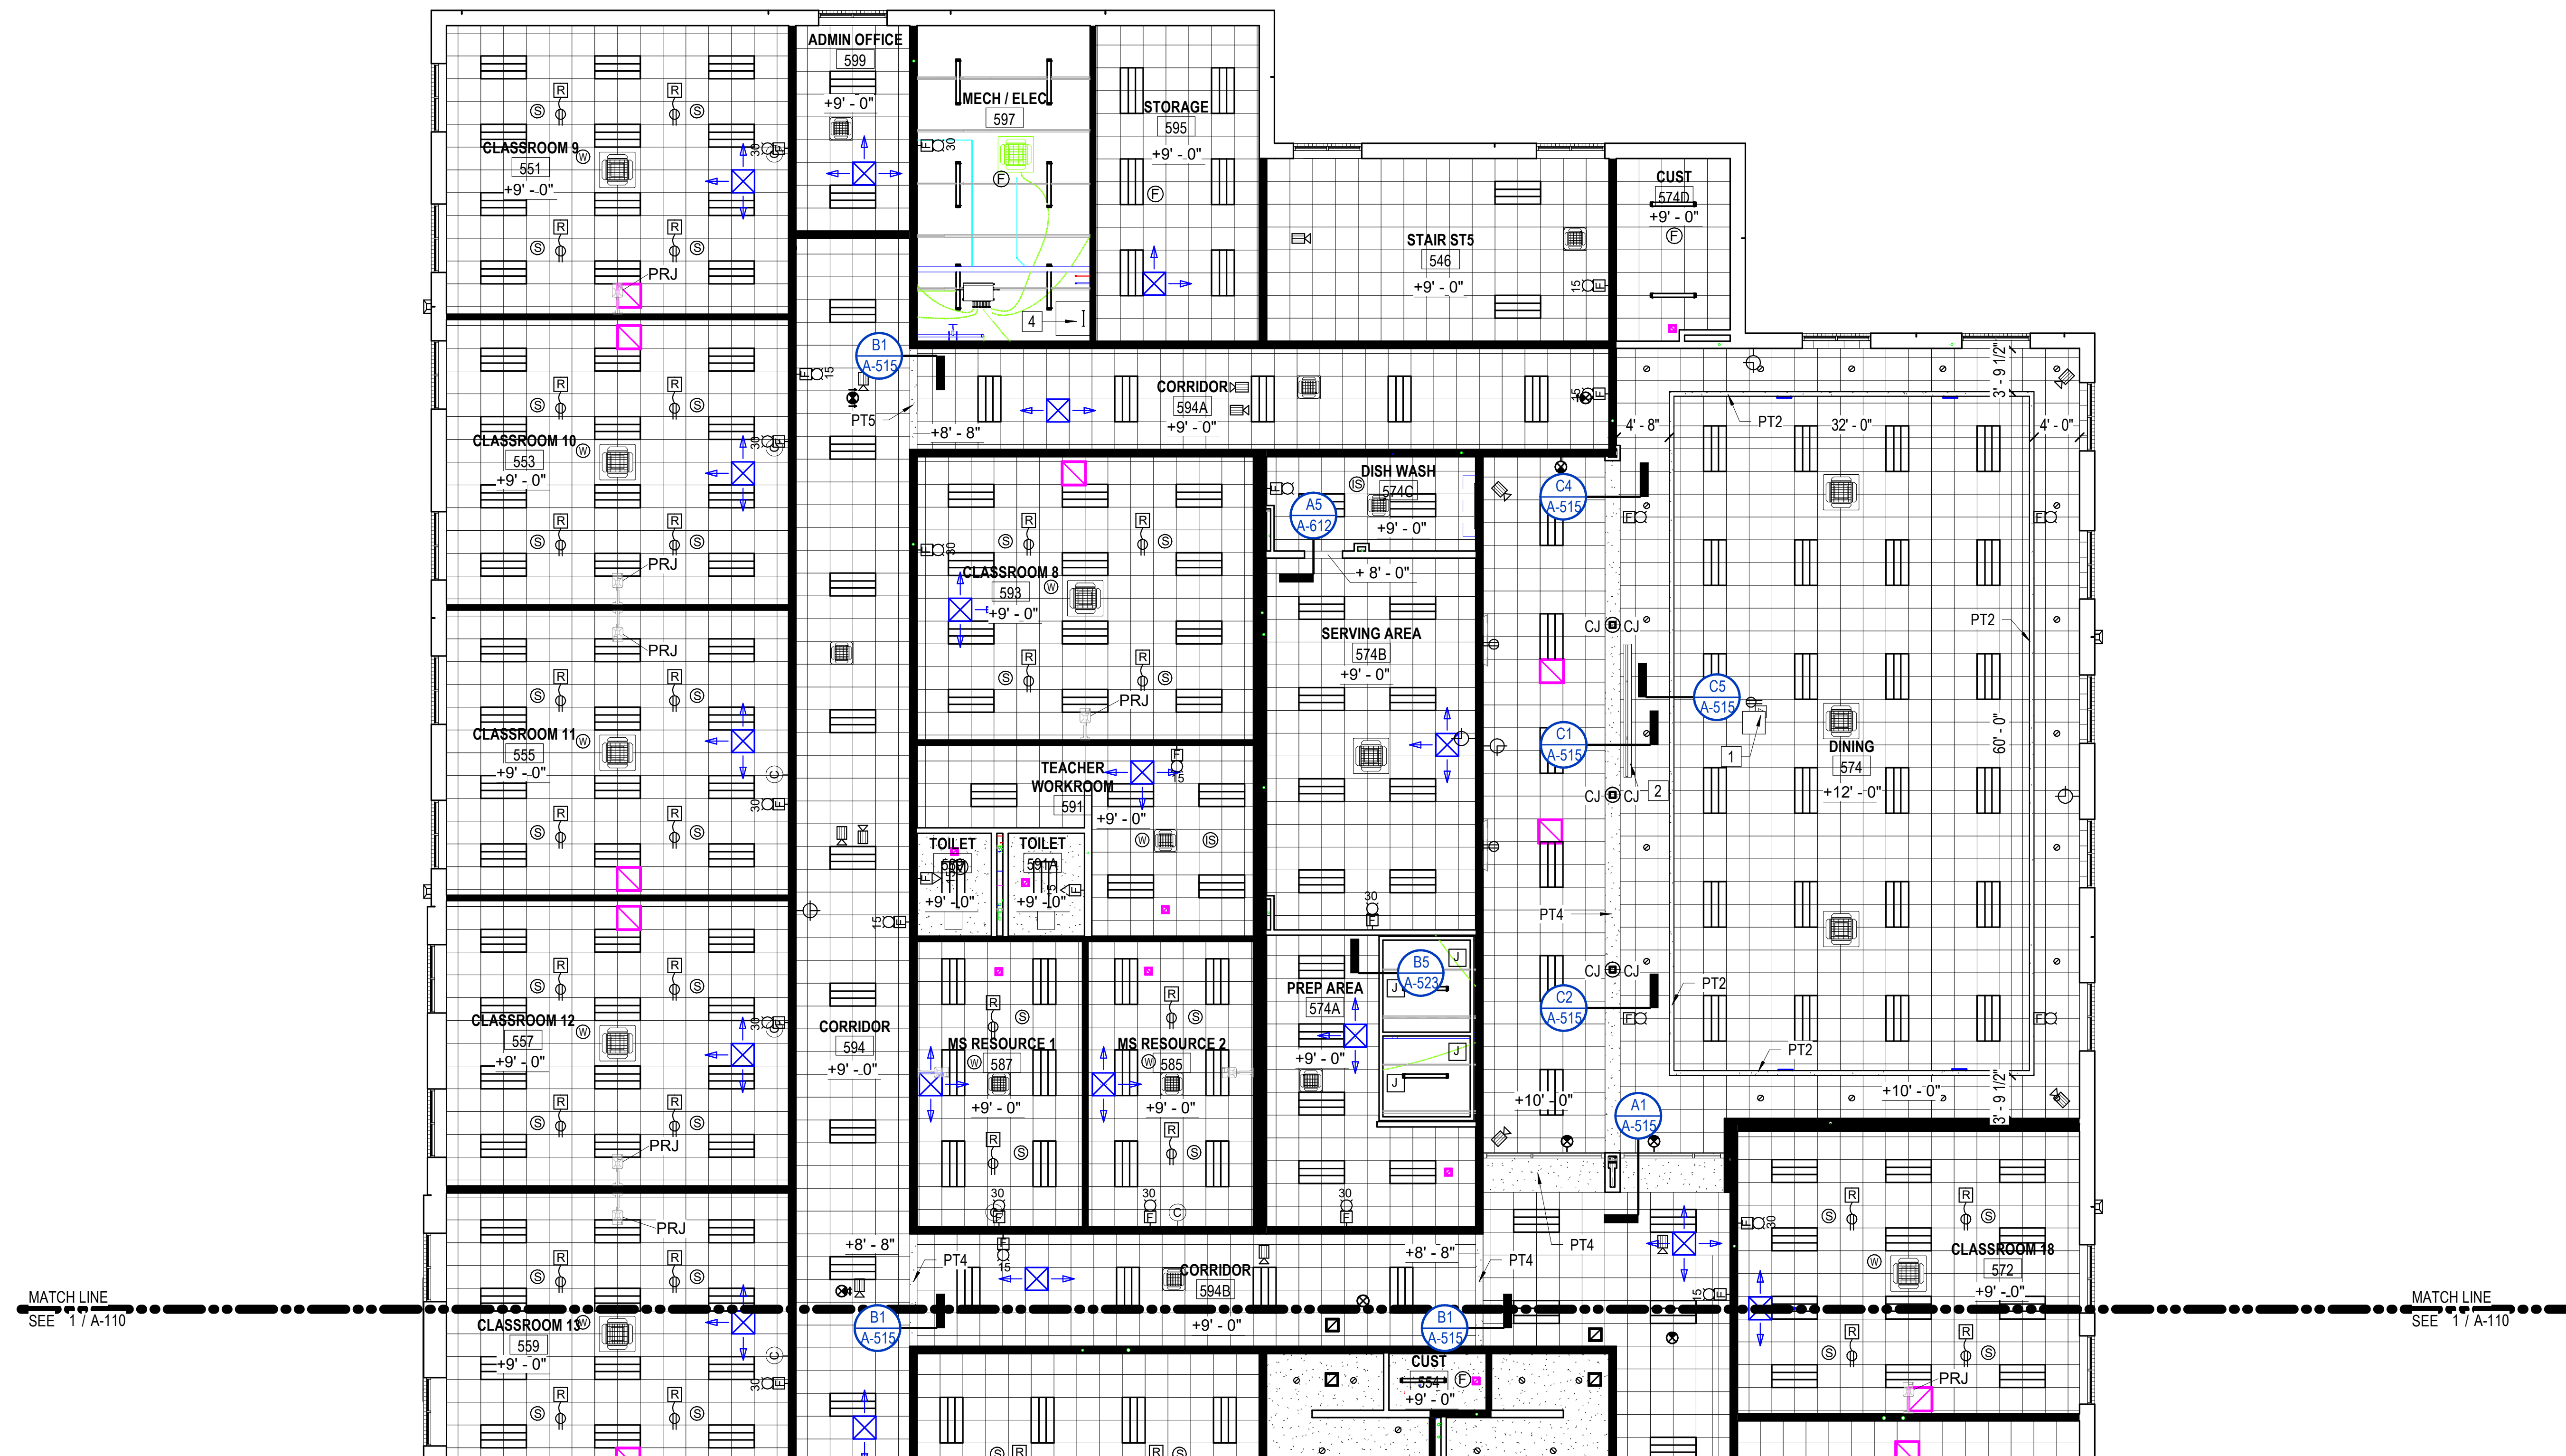

SCALE: 1/8" = 1'-0"

 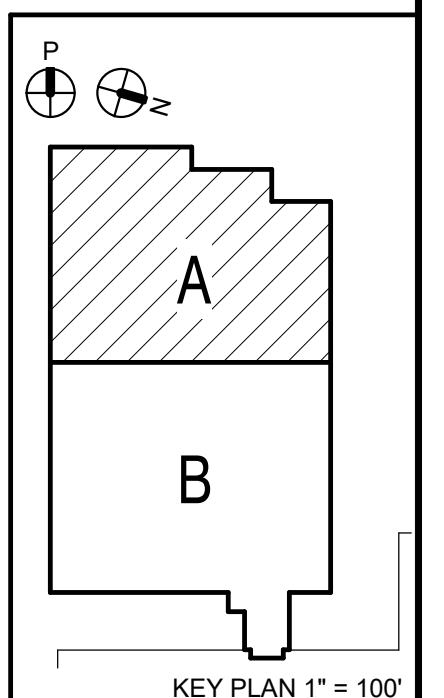



04/05/2024 14:15:39 AutodesK Docs://23143-00 Louisa County MS Addition/23143-00 v23 Louisa County MS Addition - ARCH.rvt



04/05/2024 14:15:44 Autodesk Docs/23143-001 Louisa County MS Addition/23143-00-023 Louisa County MS Addition - ARCH-14

SECOND FLOOR CEILING PLAN - AREA B

 SCALE: 1/8" = 1'-0"

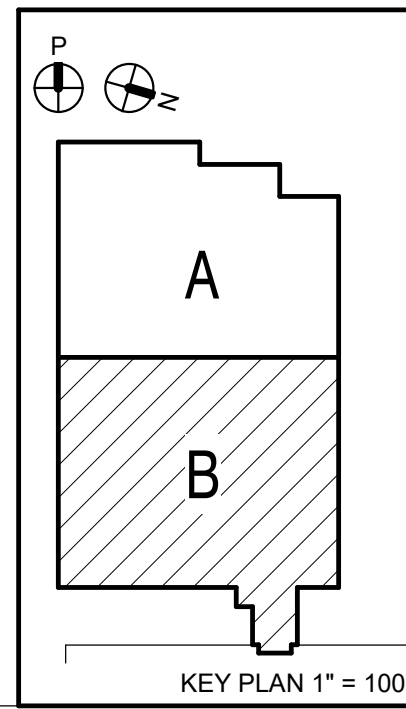

REF CLG GENERAL WORK NOTES

REFER TO SHEET [A-107](#)

KEY NOTES - REF CLG PLAN


REFER TO SHEET [A-107](#)

REF CLG PLAN LEGEND

REFER TO SHEET [A-107](#)

| MARK | DATE | DESCRIPTION |           |
|------|------|-------------|-----------|
|      |      | BY          | REVISIONS |
|      |      |             |           |

|          |            |         |          |     |     |     |
|----------|------------|---------|----------|-----|-----|-----|
| DATE     | 8 APR 2024 | PROJECT | 23143-00 | JSC | JAS | DJW |
| DESIGNED |            | DRAWN   |          |     |     |     |
| CHECKED  |            |         |          |     |     |     |

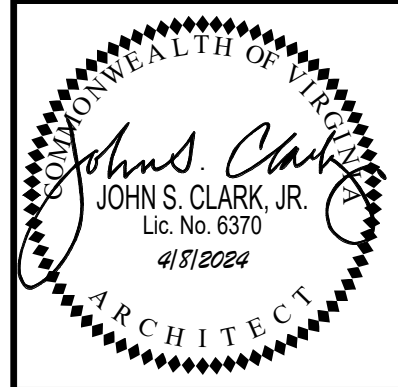

PROJECT LOUISA COUNTY PUBLIC SCHOOLS  
LOUISA COUNTY MIDDLE SCHOOL ADDITION  
1009 DAVIS HIGHWAY  
MINERAL, VIRGINIA  
DRAWING SECOND FLOOR REFLECTED CEILING PLAN - AREA B  
VIRGINIA DEPARTMENT OF EDUCATION 064-6001-001

SHEET  
**A-110**