



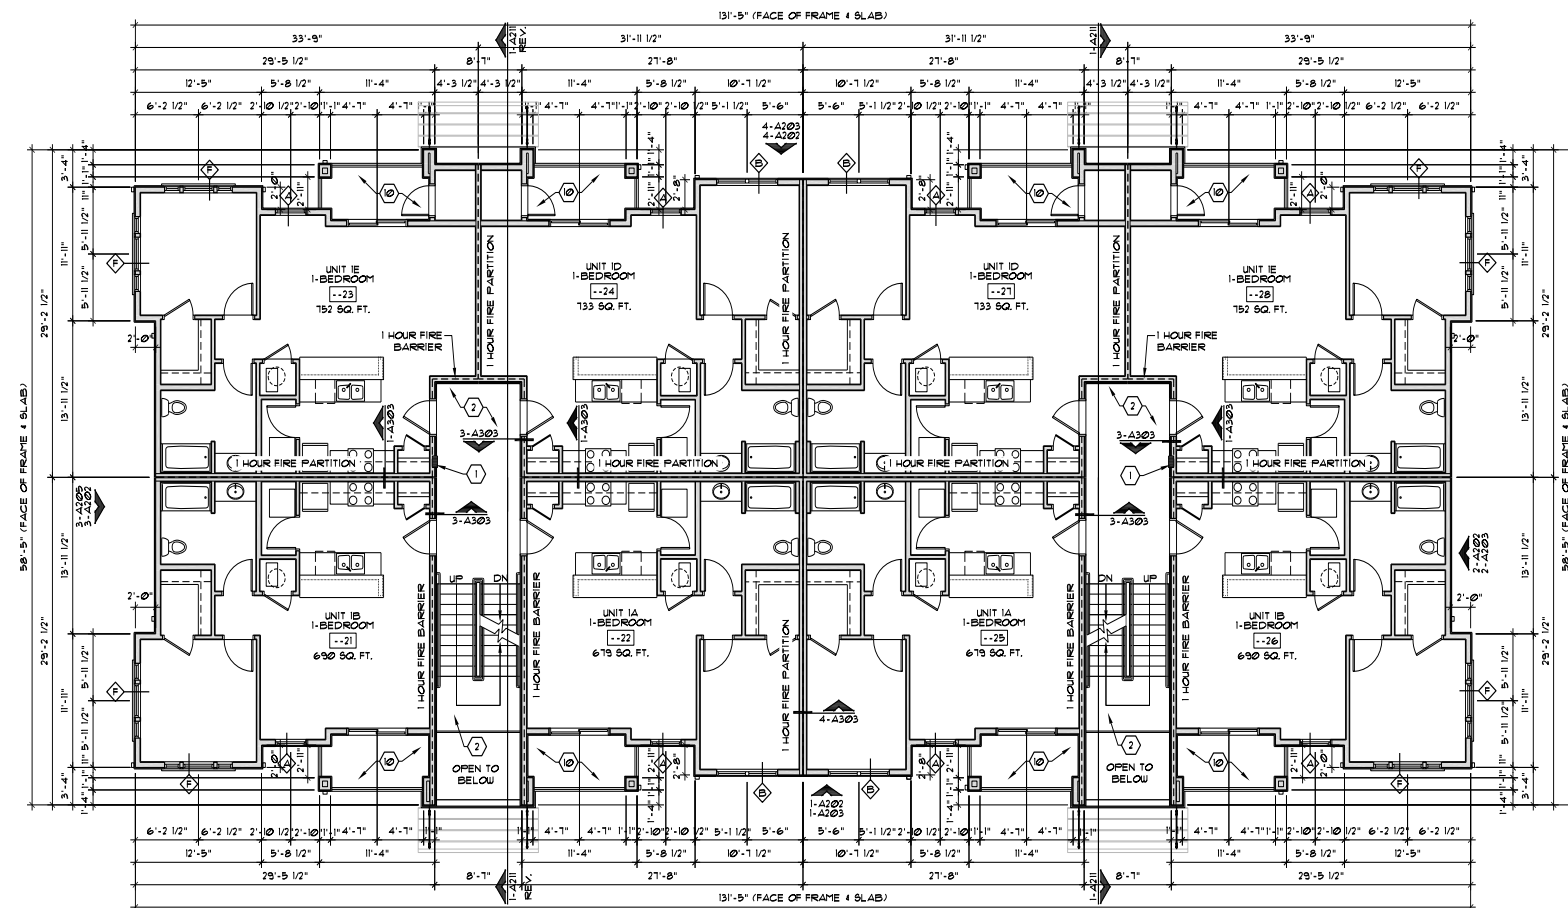

**BUILDING A
2ND LEVEL FLOOR PLAN**
A102 SCALE: 1/8"=1'-0" BUILDINGS 3, 4, 8, 10 & 12

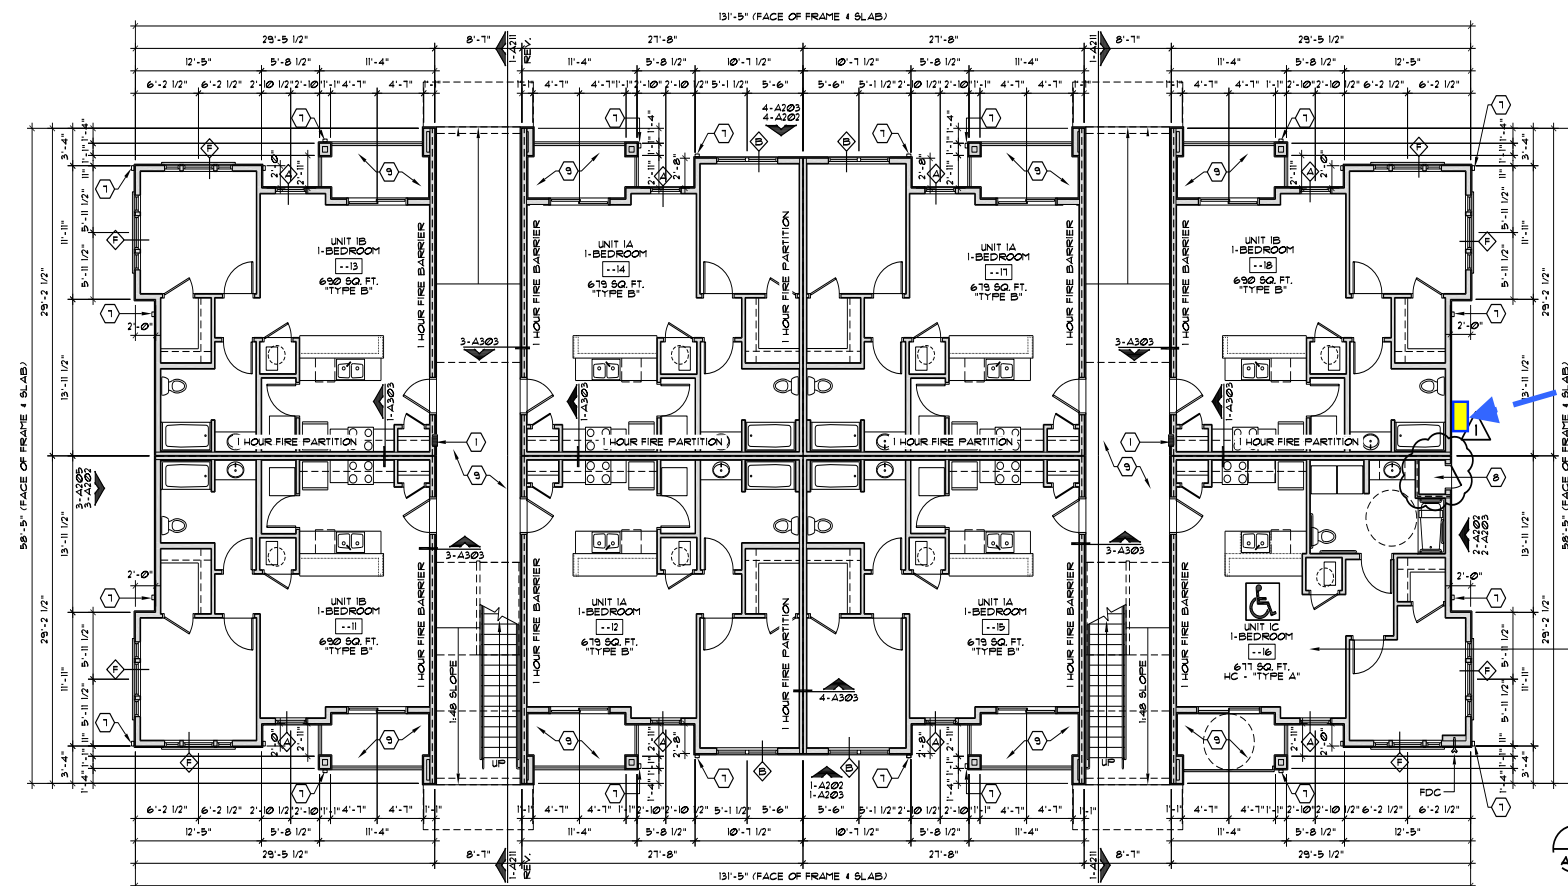

REFER TO A501 ARCHITECTURAL SITE PLAN
SHEET A501 FOR LOCATIONS OF UNIT 1C.
ADDRESS LOCATIONS (RE: SHEET A503):
BUILDING 3 - UNIT 316
BUILDING 4 - UNIT 411
BUILDING 8 - UNIT 816
BUILDING 10 - UNIT 1016
BUILDING 12 - UNIT 1211

**BUILDING A
1ST LEVEL FLOOR PLAN**
A101 SCALE: 1/8"=1'-0" BUILDINGS 3, 4, 8, 10 & 12

Wall
Box


IFC Set 7.18.2022

IFC Set 7.18.2022

Site Pathways

August 9, 2022

VVD.f3

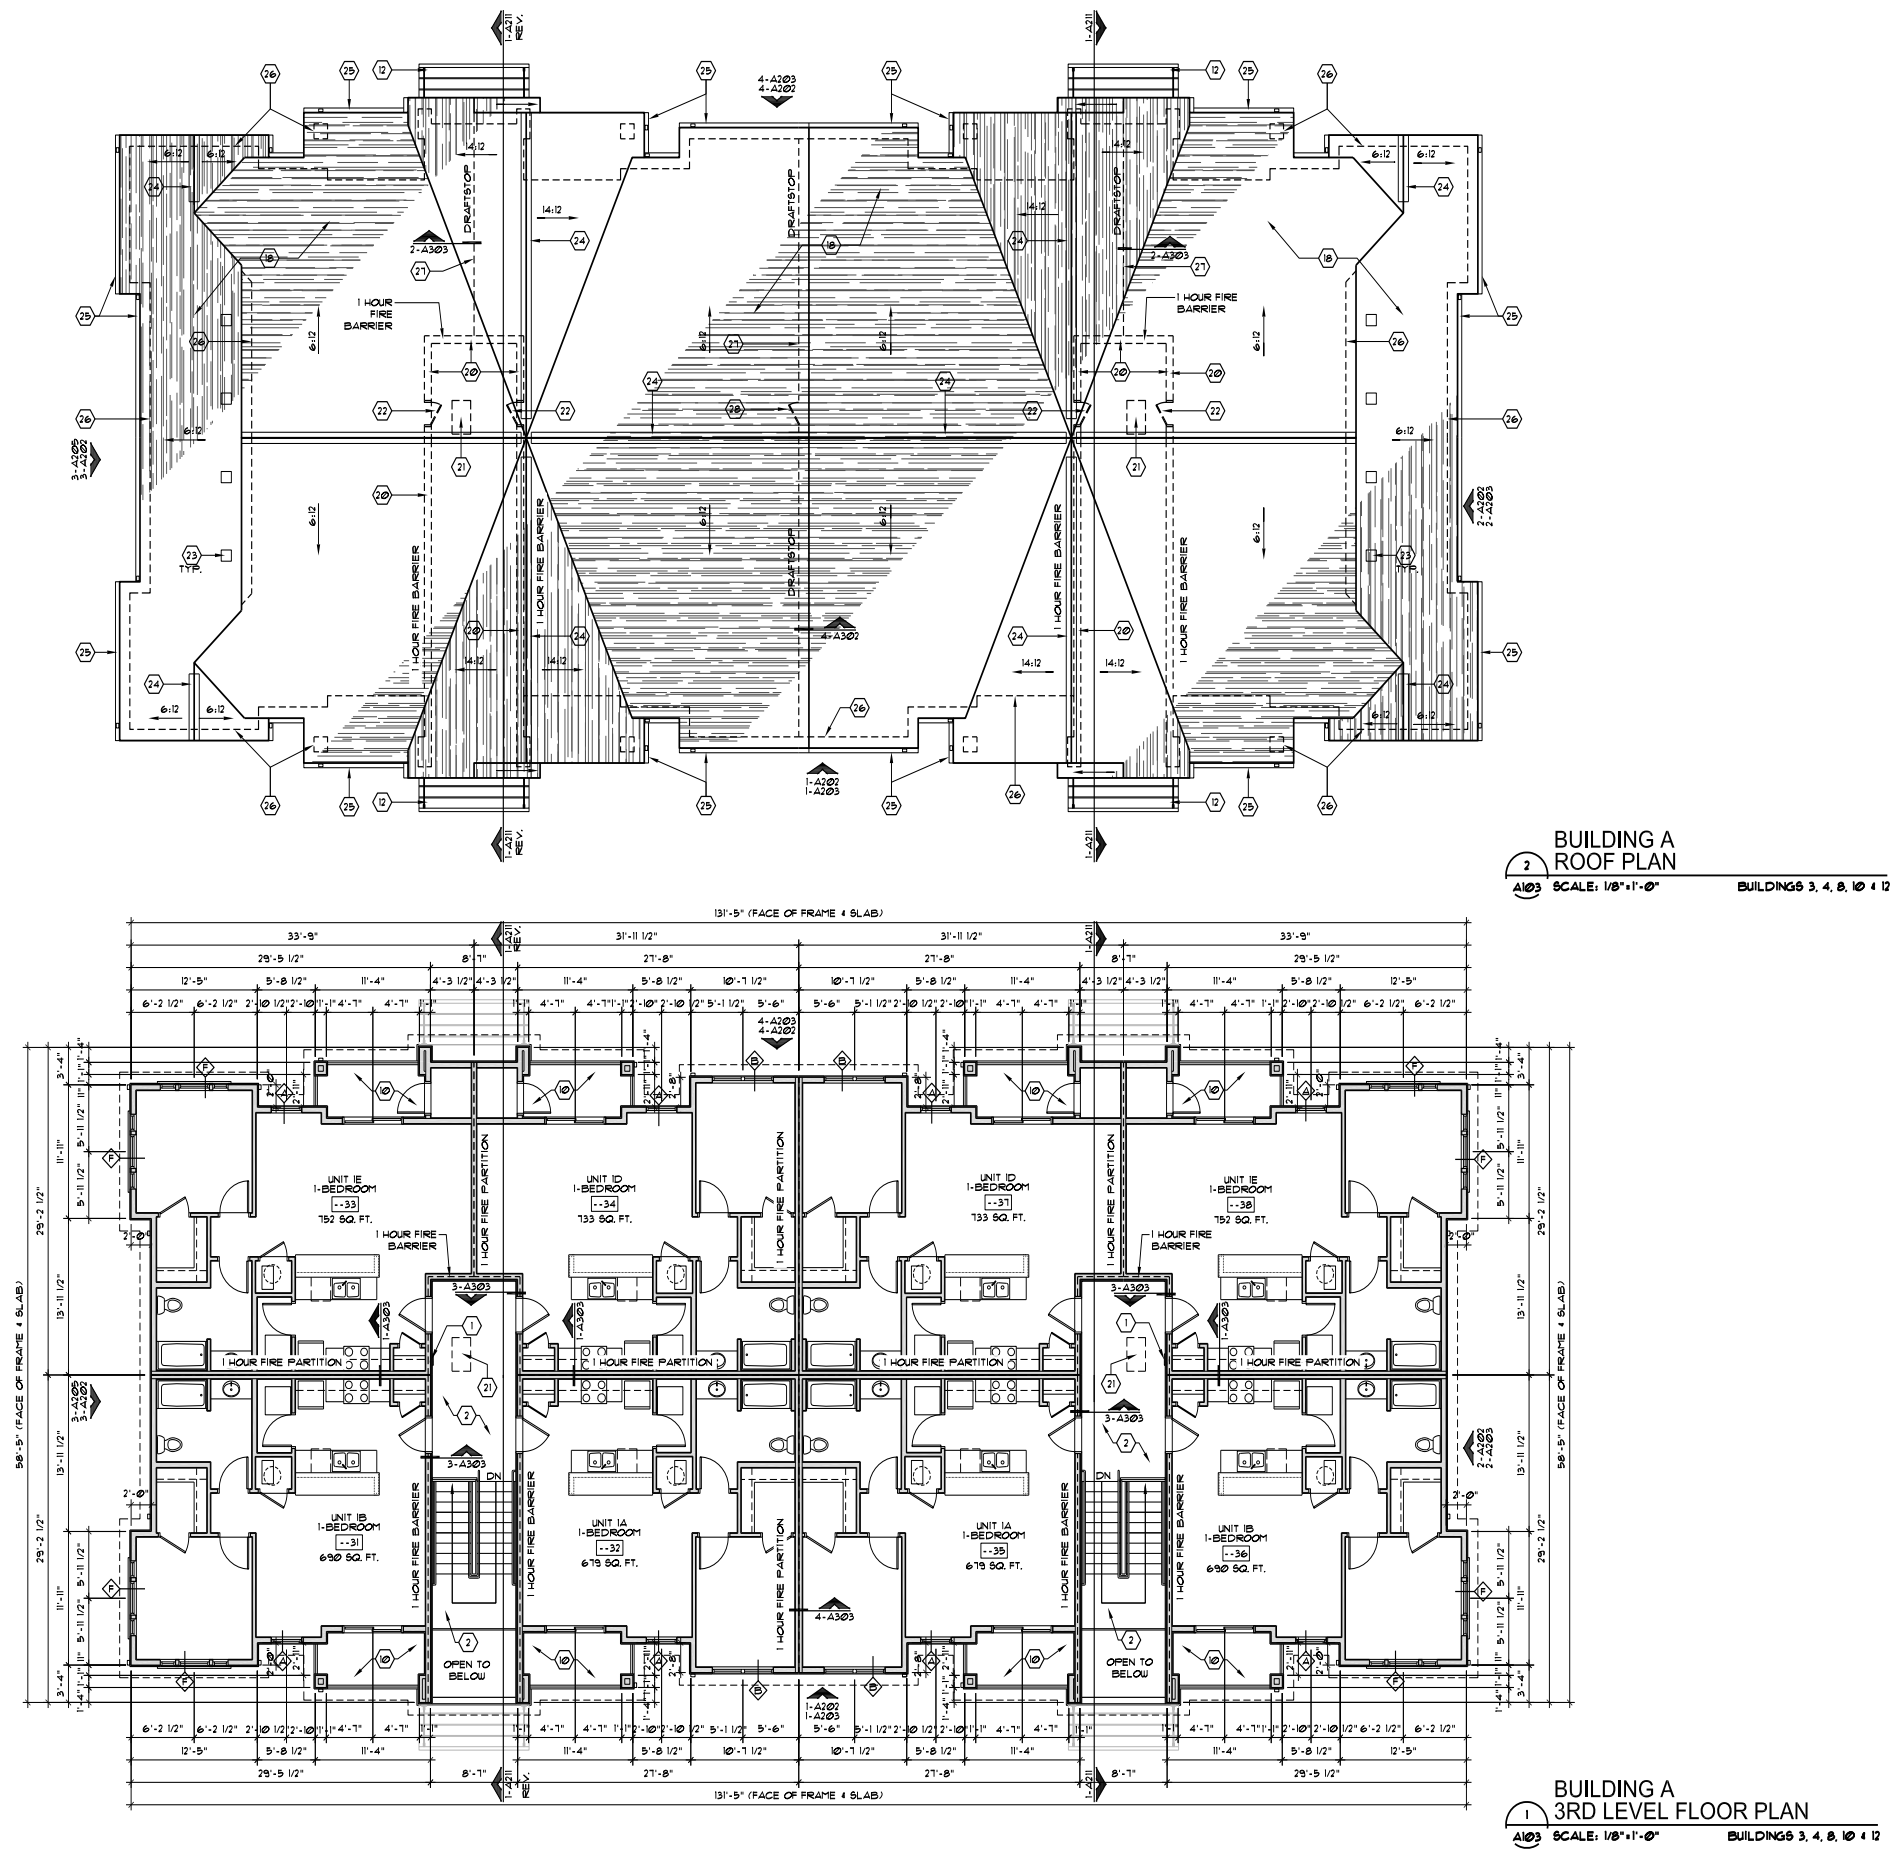


IFC Set 7.18.2022

Site Pathways

August 9, 2022


VVD.f4

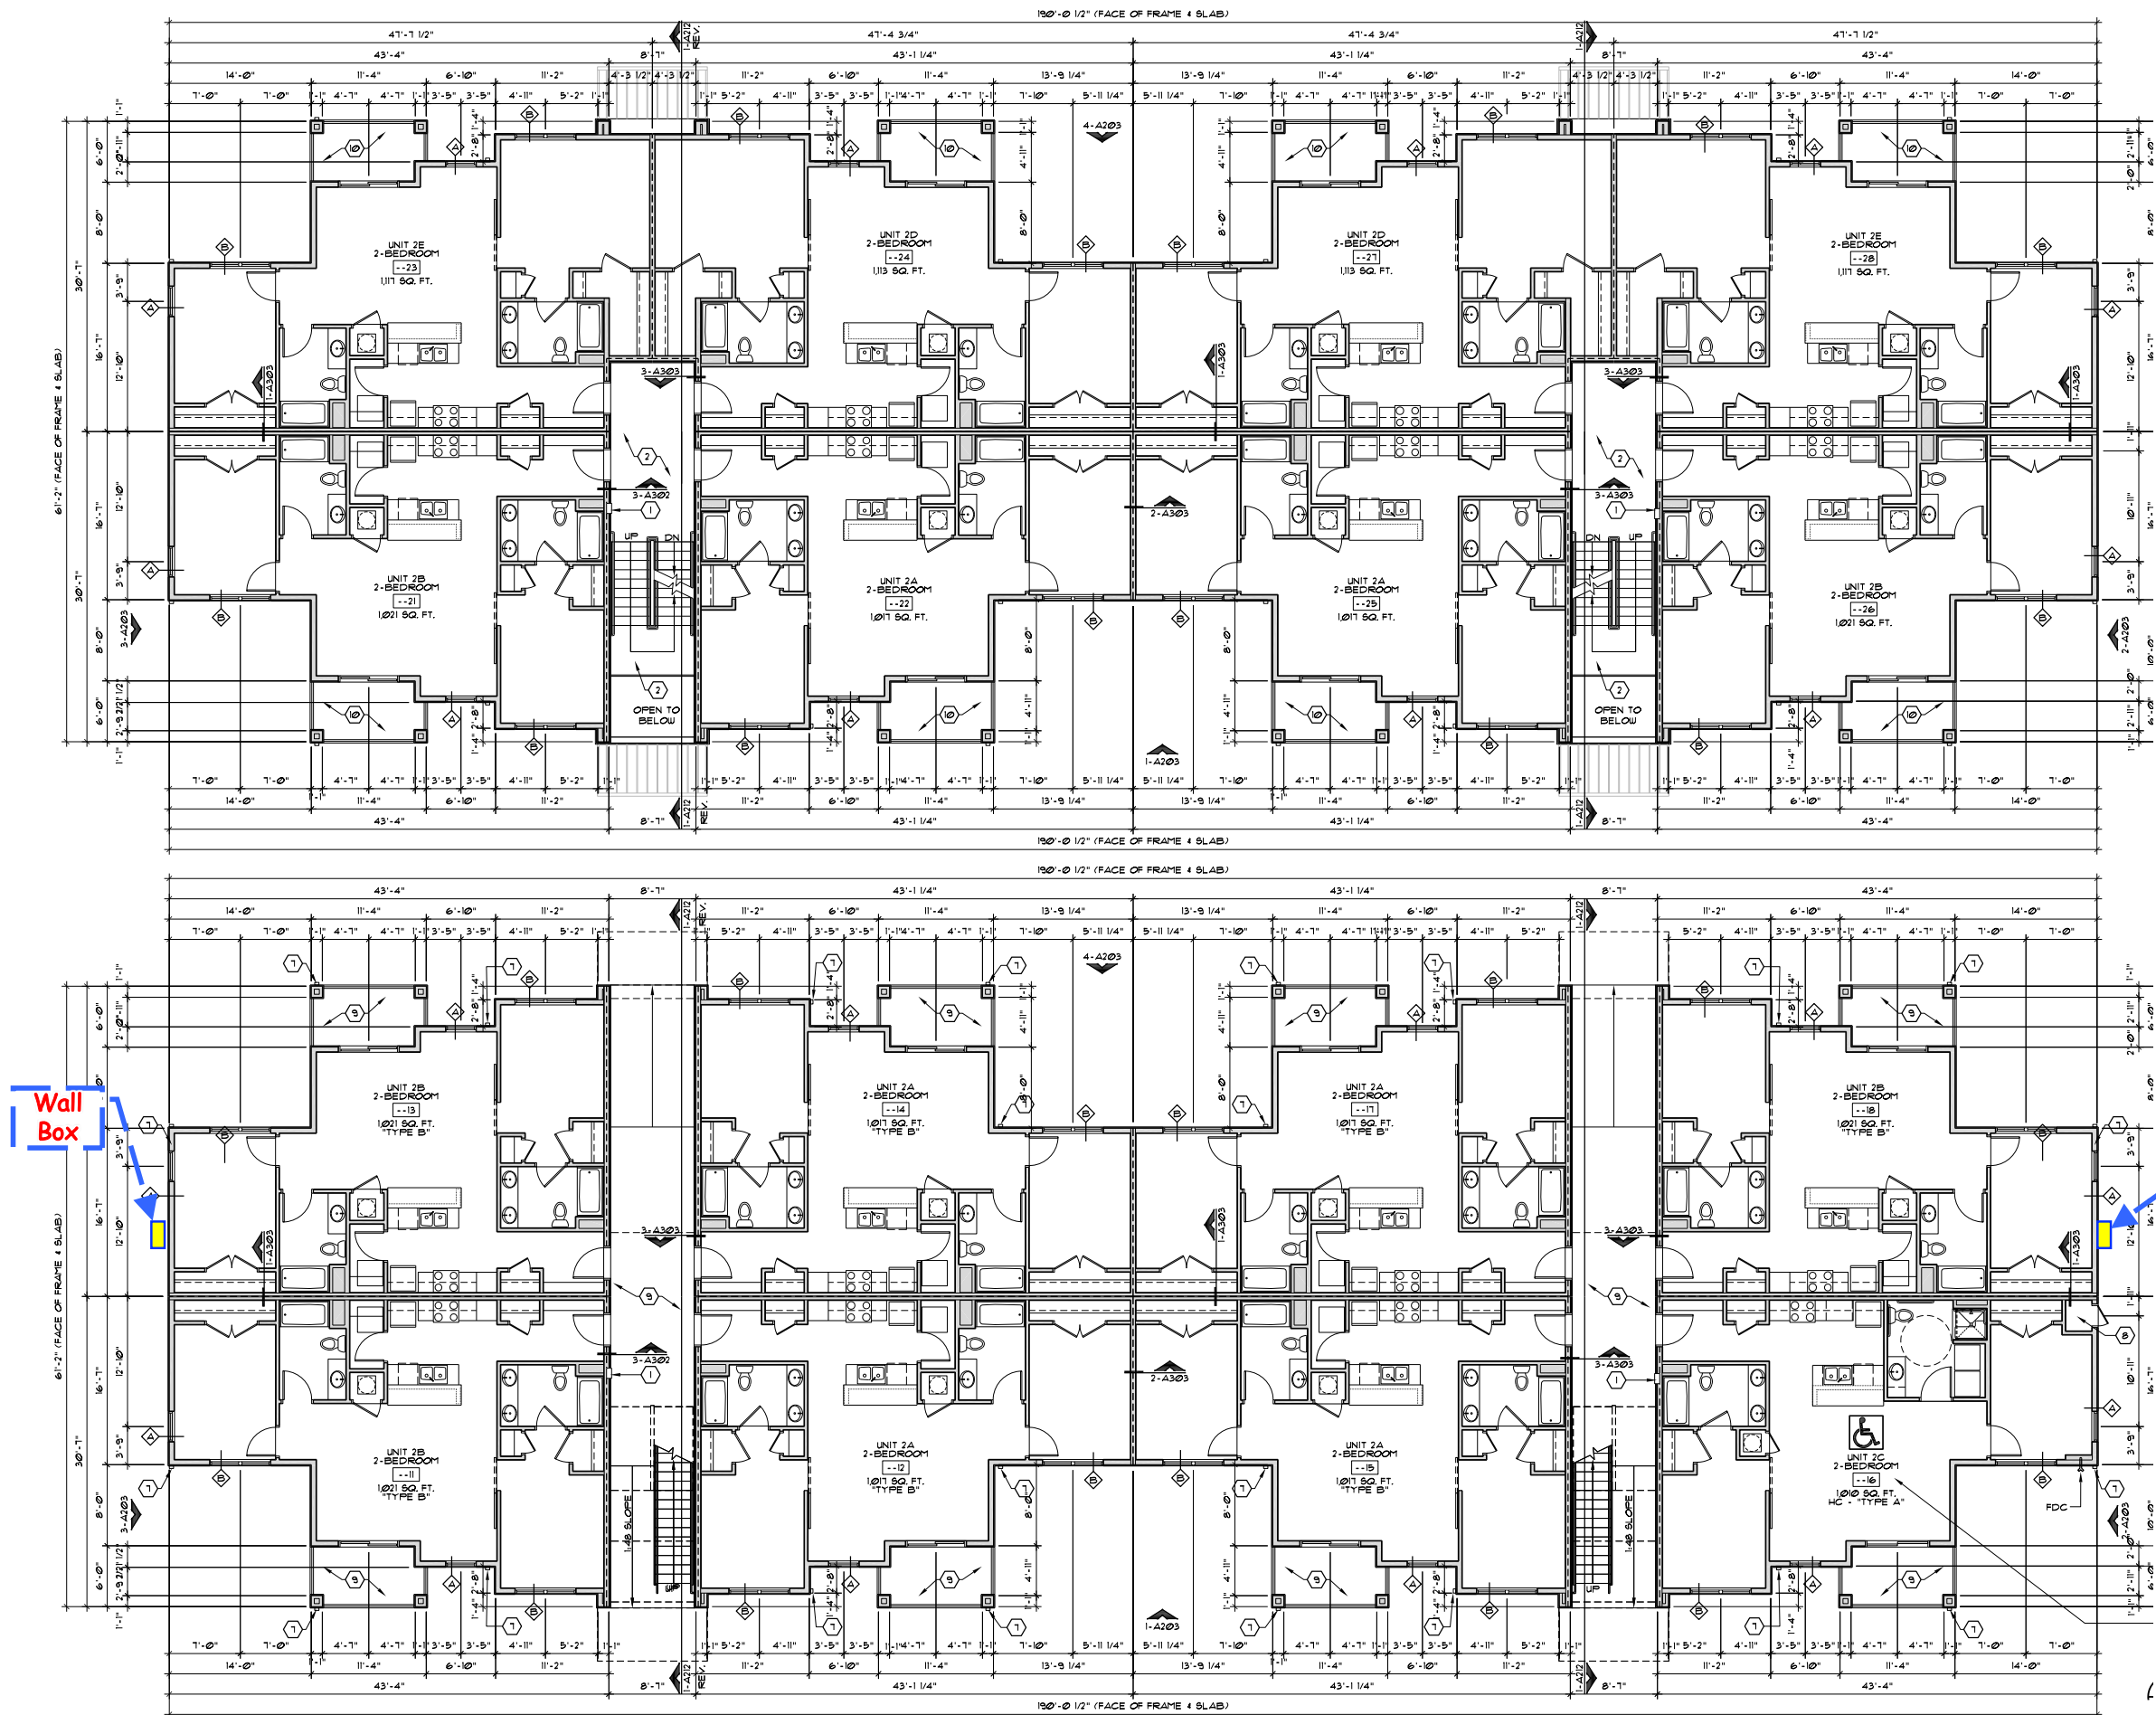


IFC Set 7.18.2022


Diffusion

VVD.f5

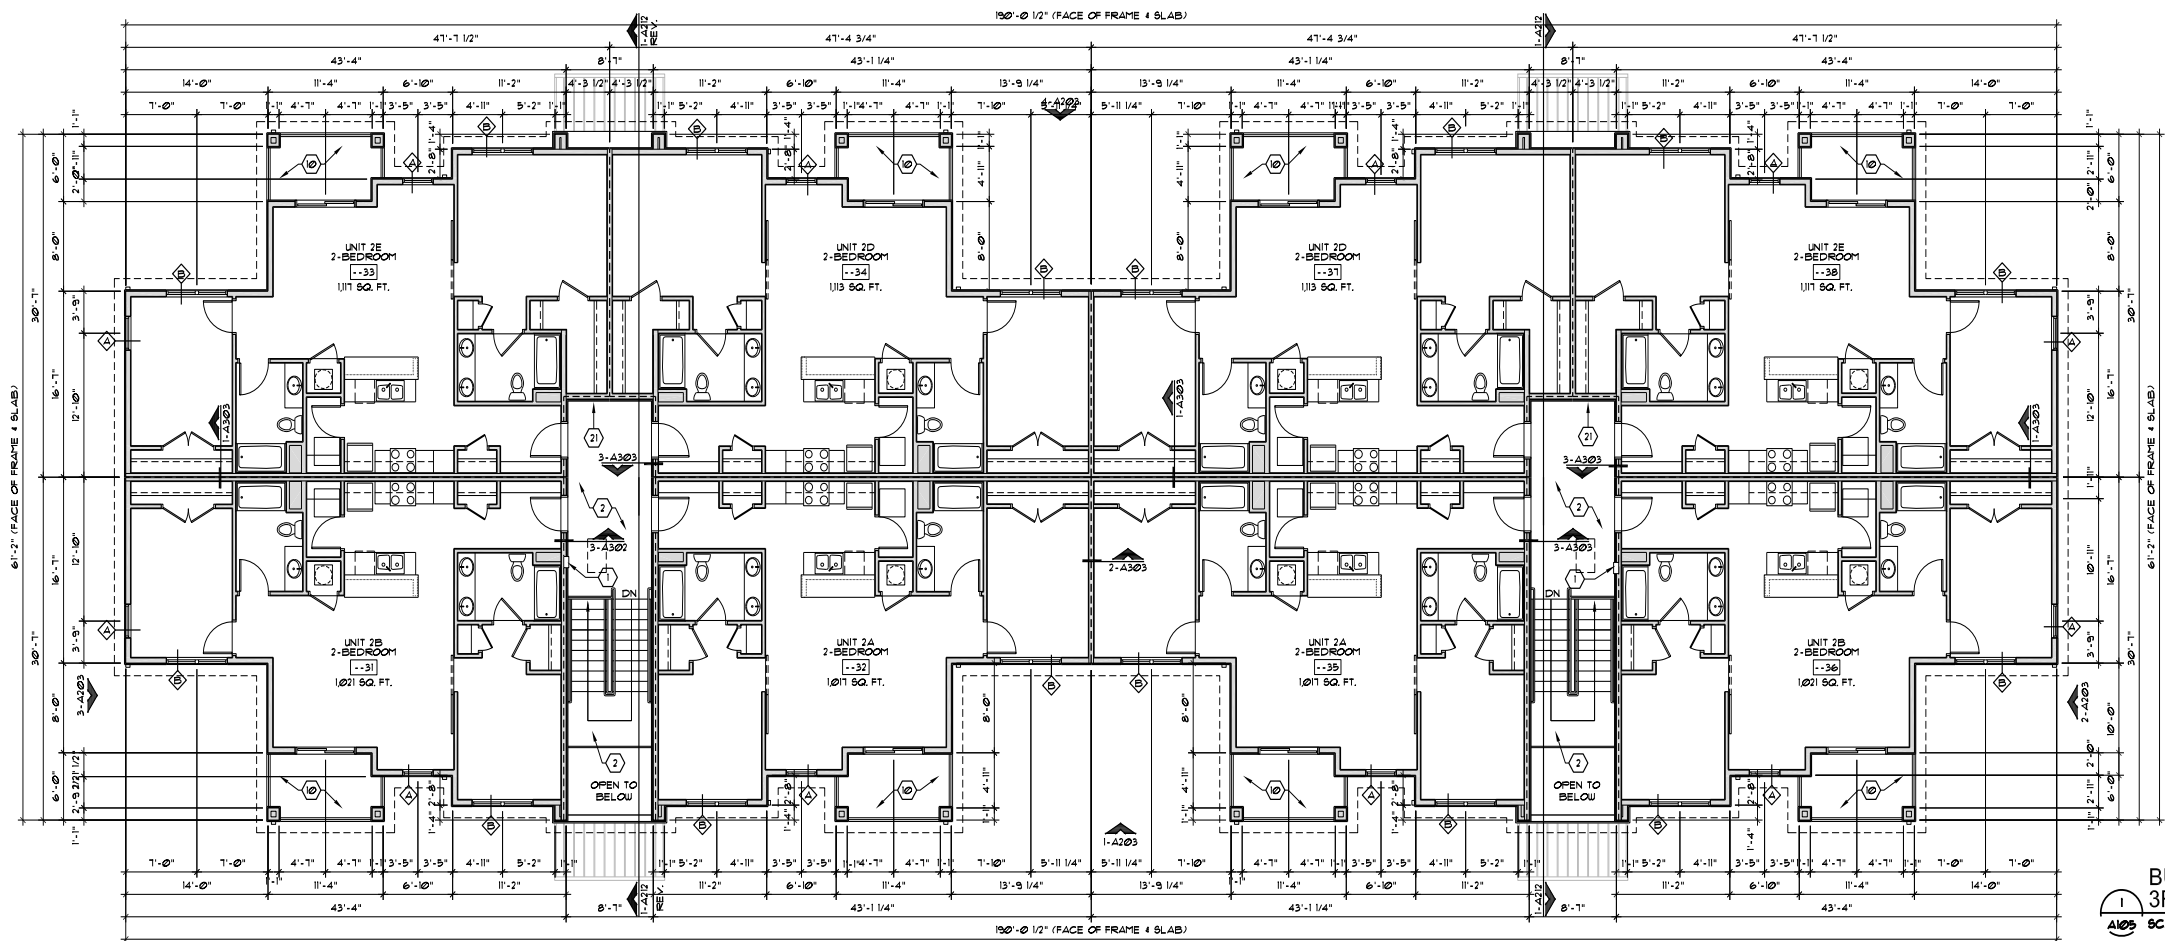

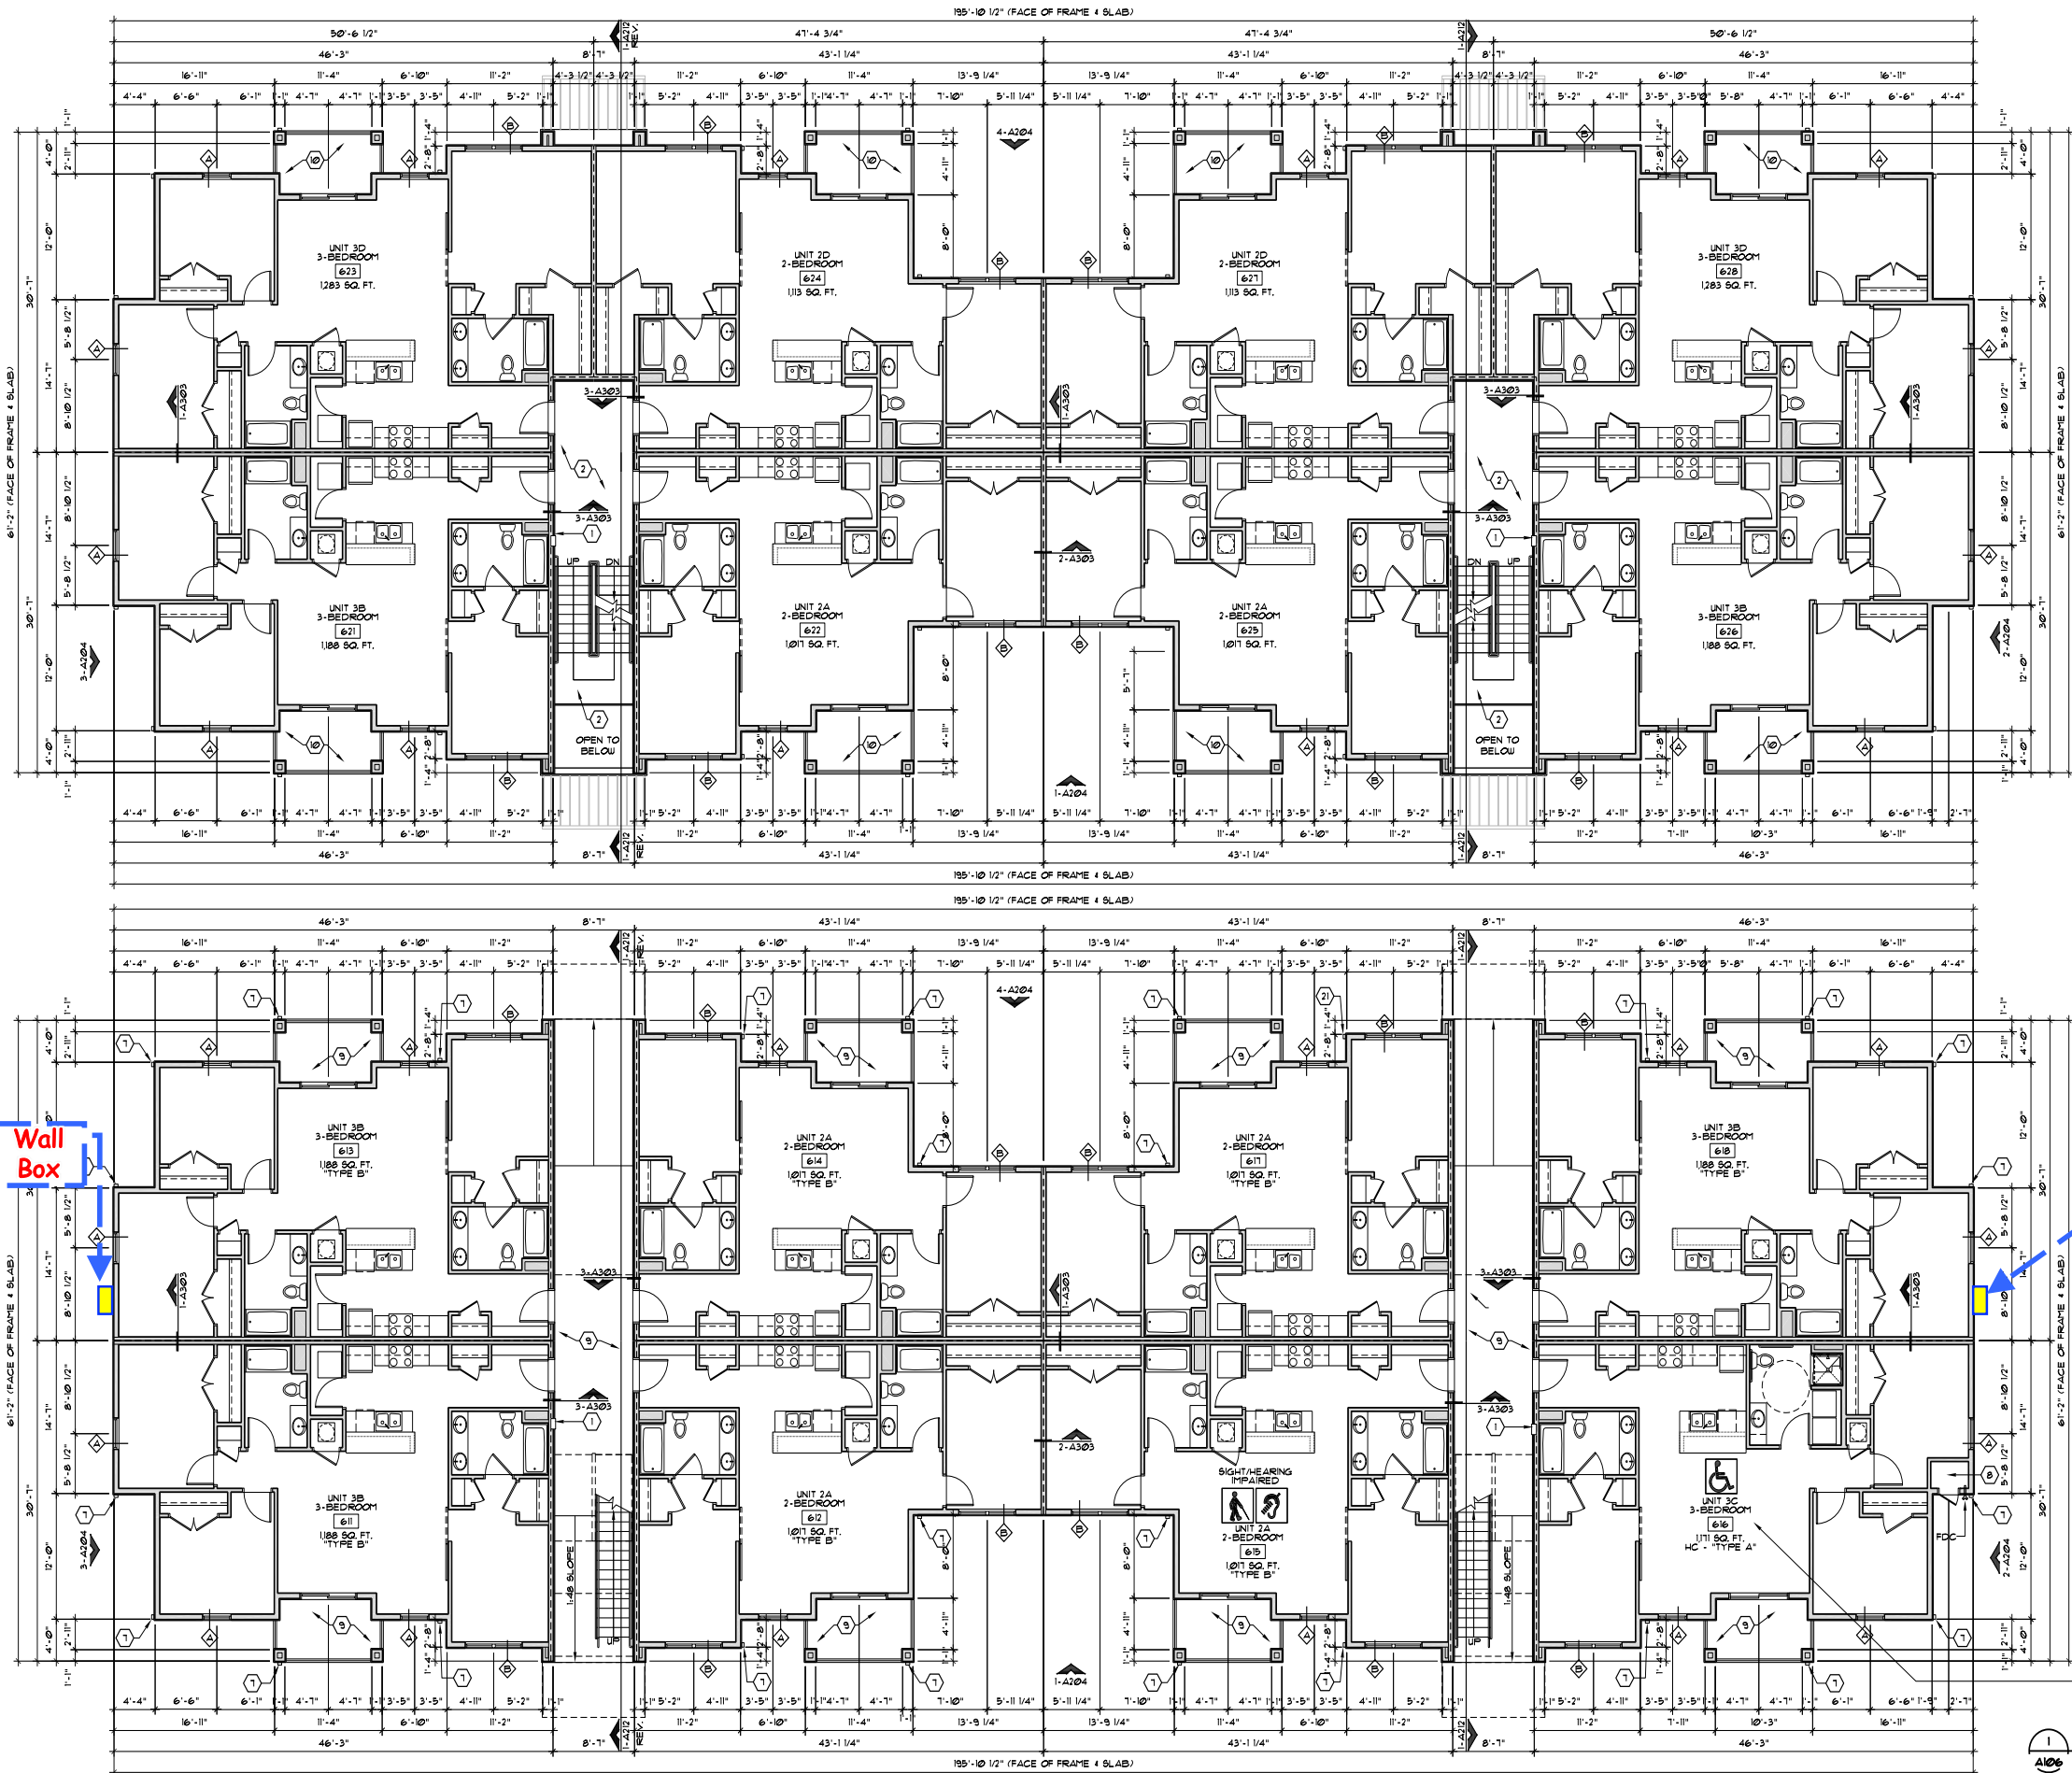

IFC Set 7.18.2022

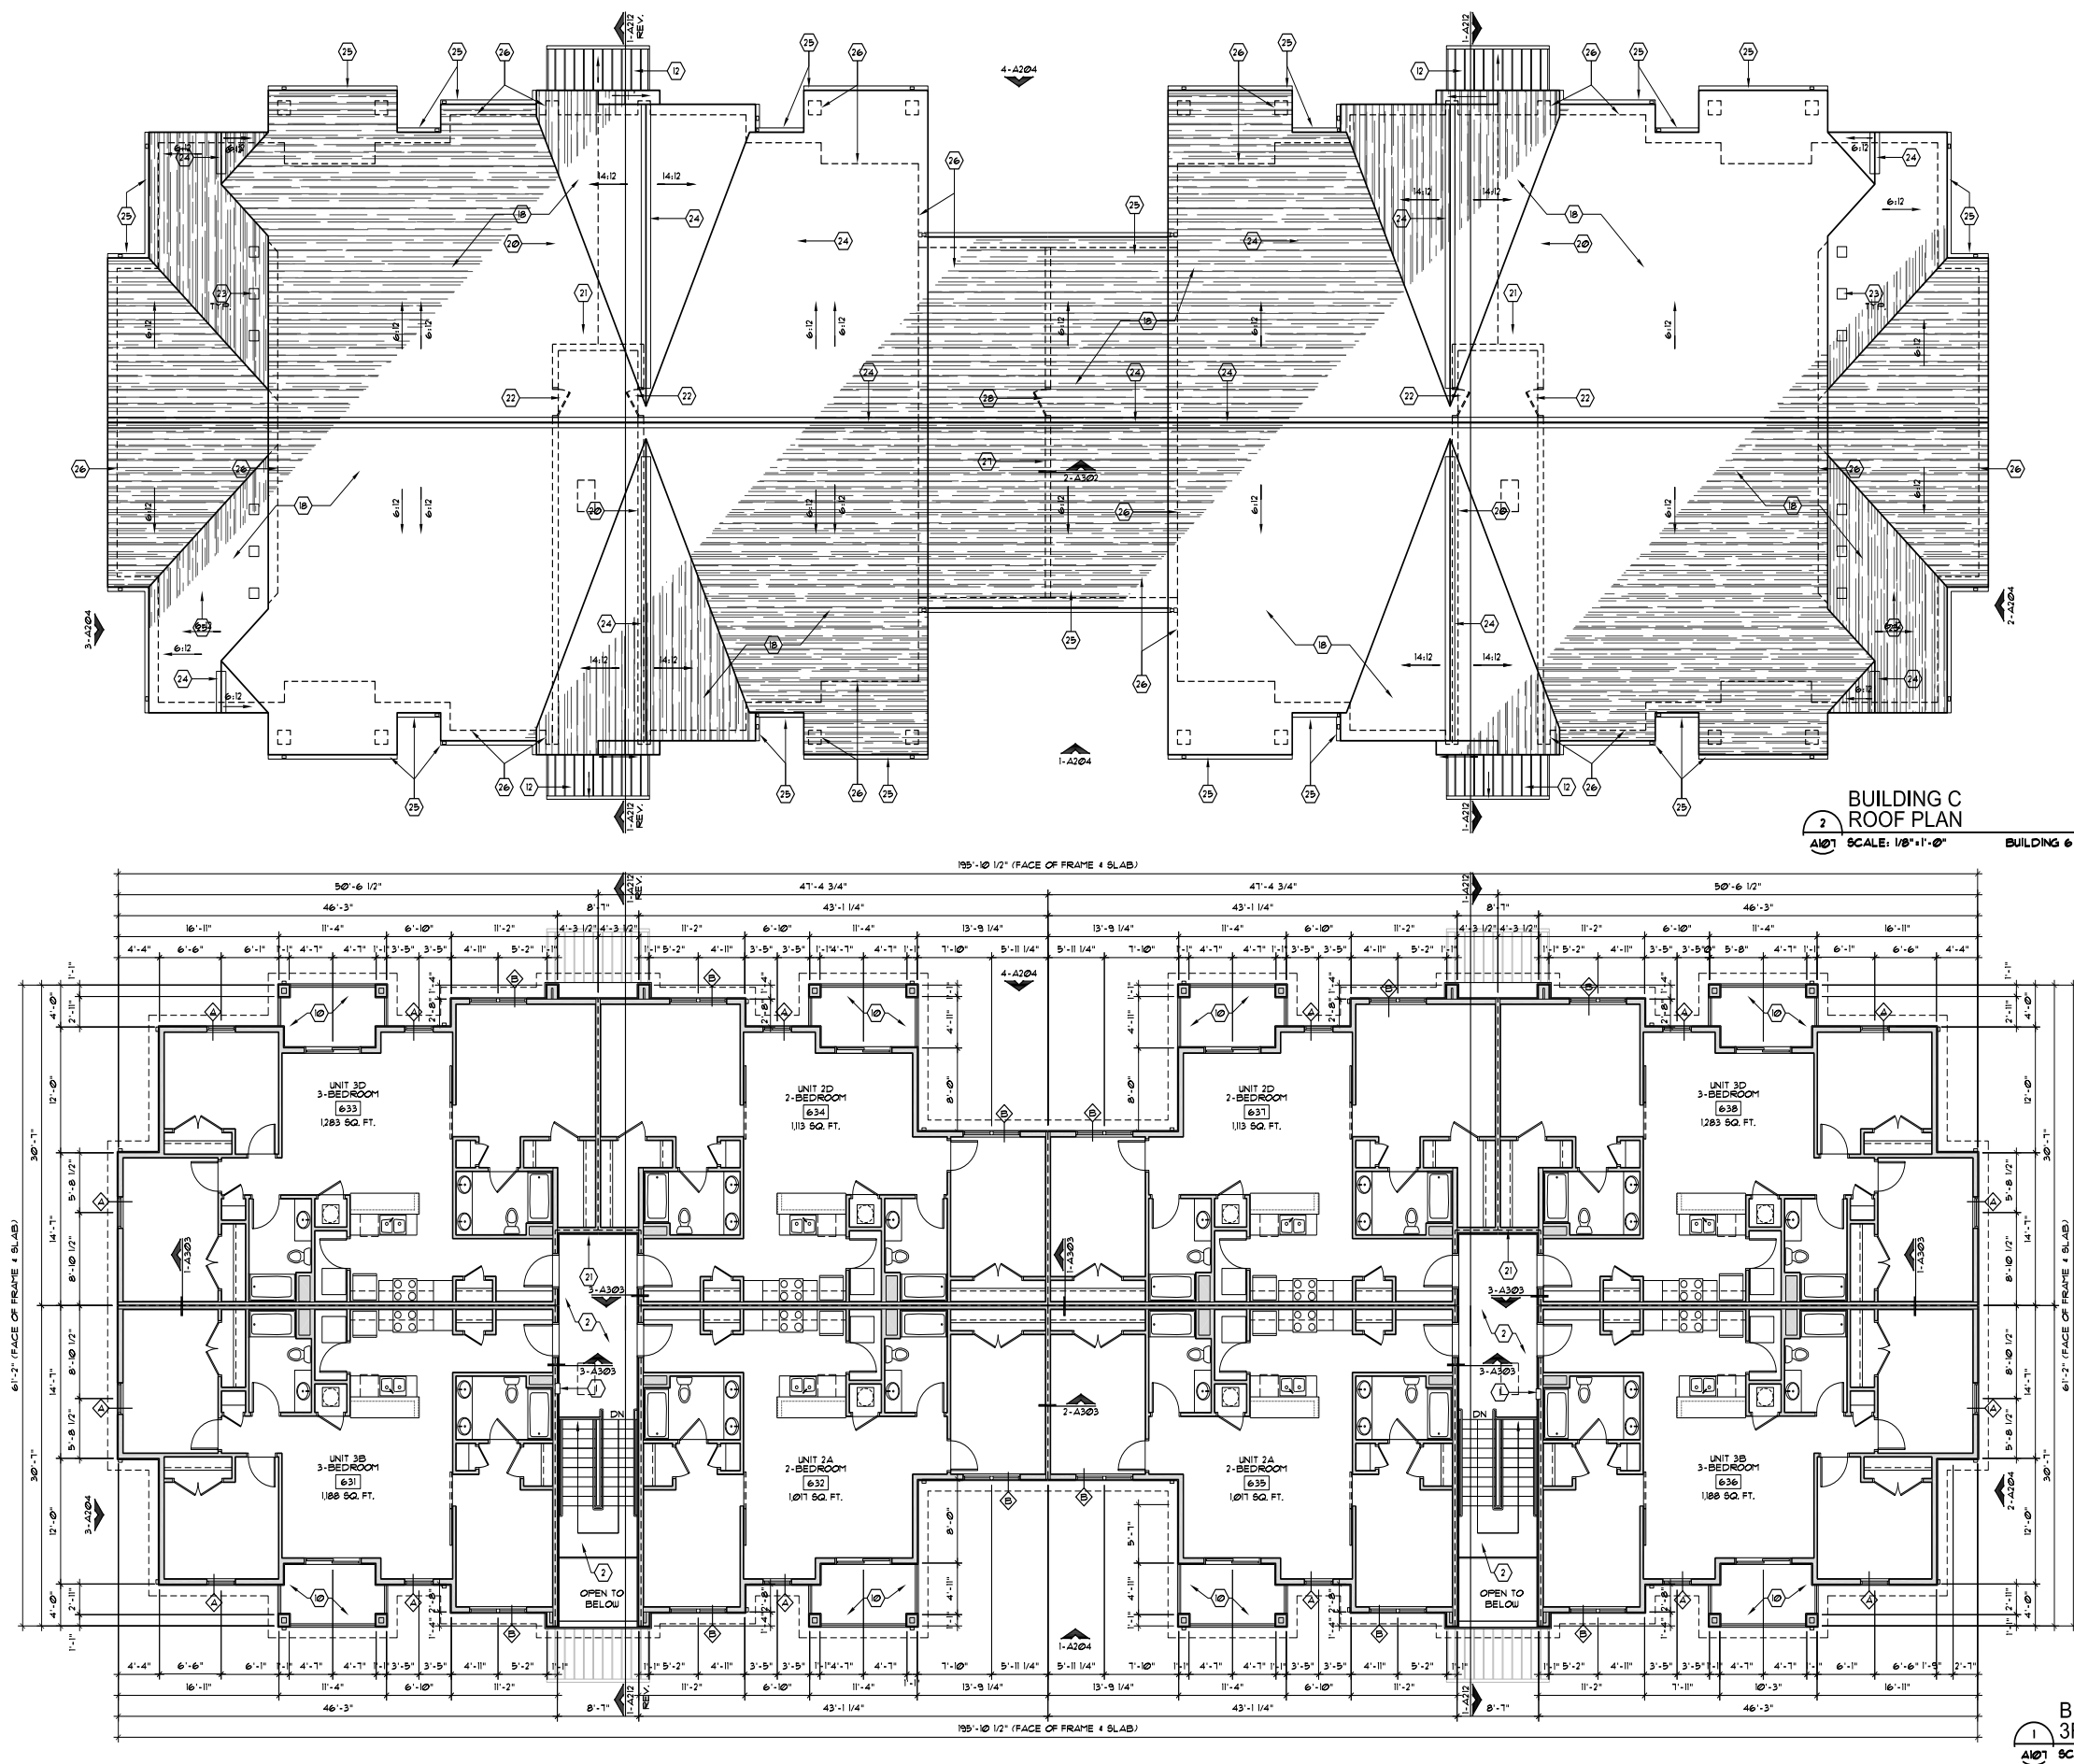


IFC Set 7.18.2022

C:\Dropbox (TRIO)\Projects\Greystan\Elan Brighton\5-CD\TRIO Dwg\Elan Brighton - 24x36 - ID Set.dwg, 10/29/2021 8:29 PM

Prewire for Common Area Wi-Fi Access Points :

Interior Wi-Fi - (1) Cat6a to single gang box w/cover plate on ceiling
Exterior Wi-Fi - (1) Cat6a to weather rated single gang box w/cover on wall minimum 9' AFF
All cables terminated and routed back to closet IDF or MDF

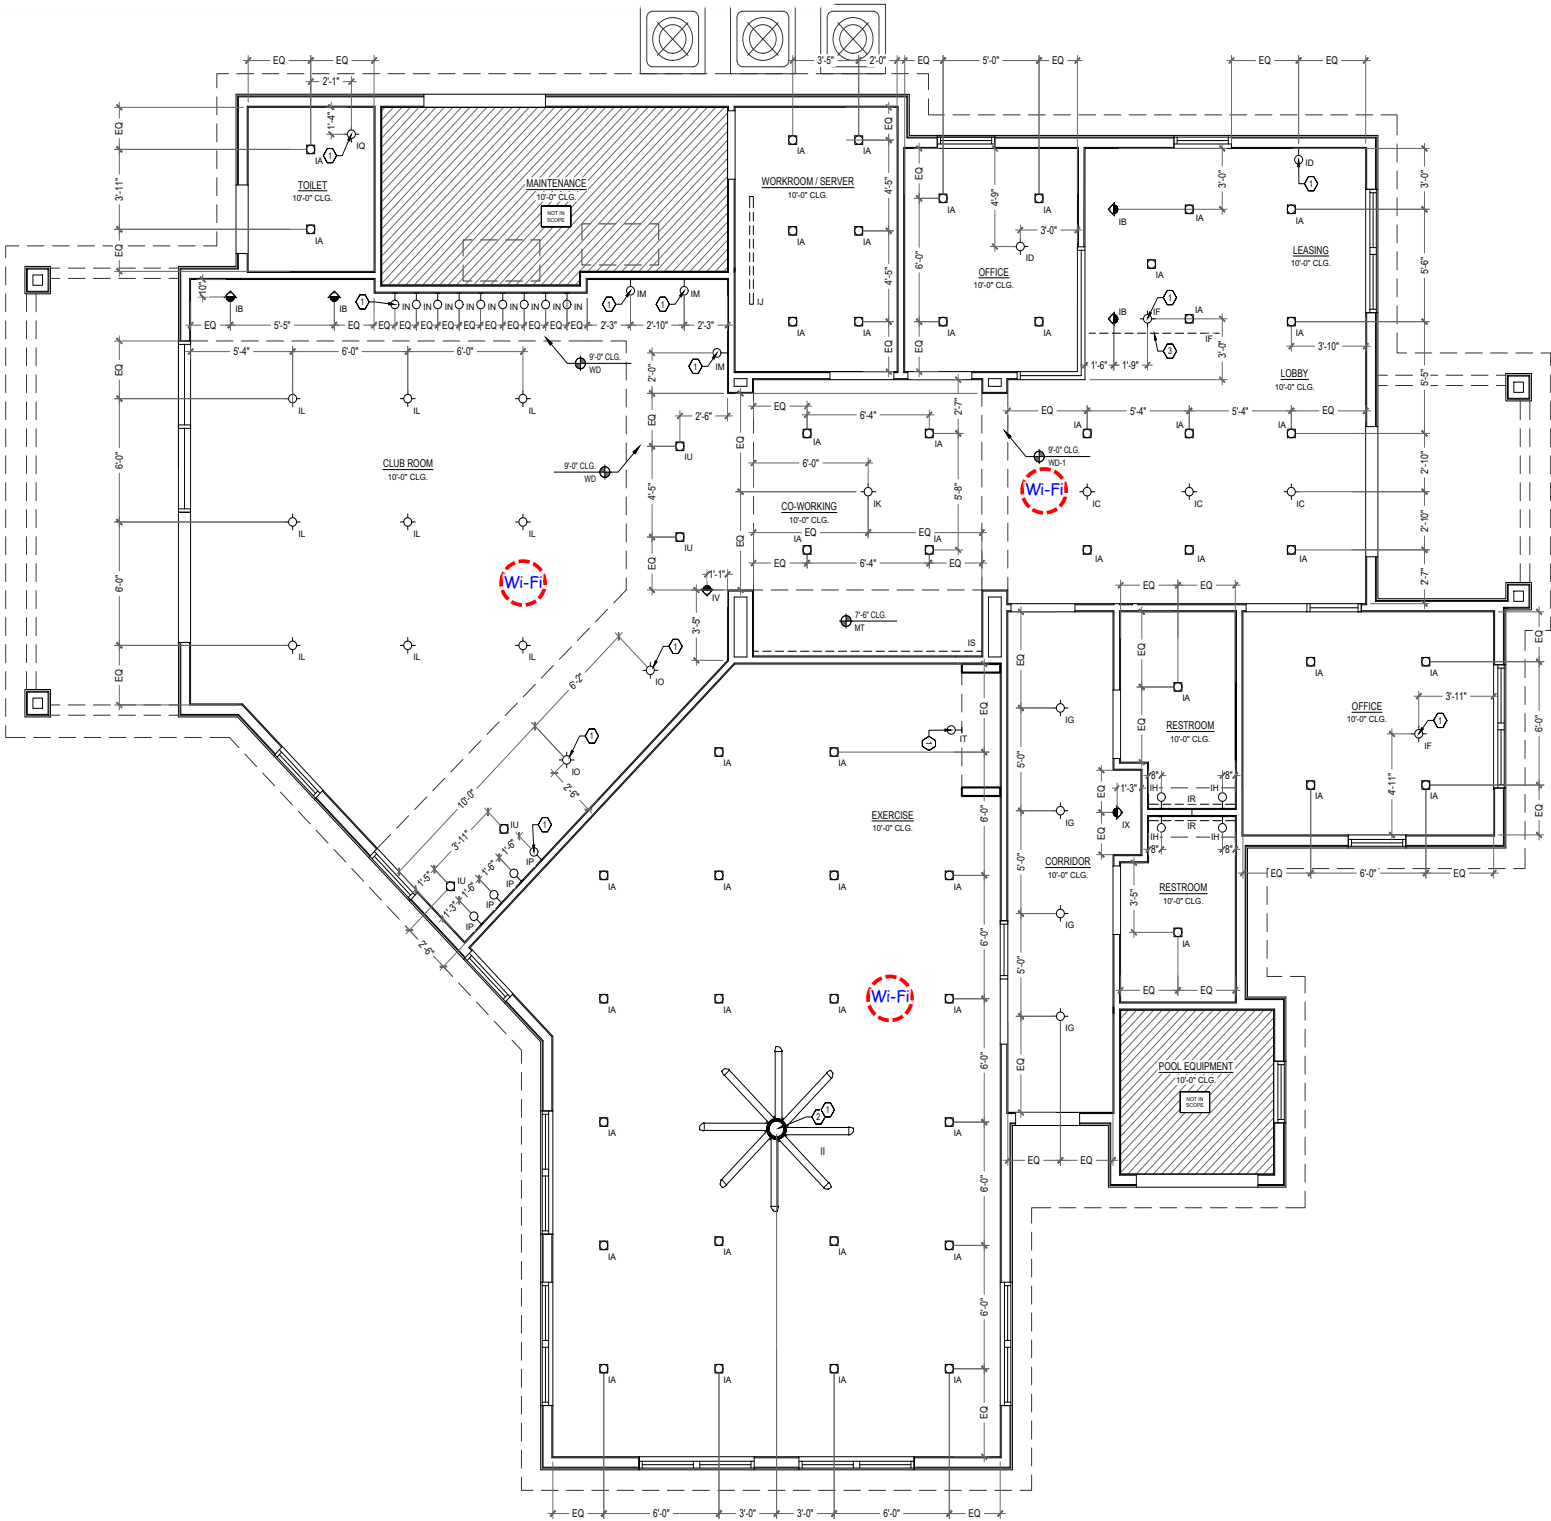

 FIRST FLOOR - REFLECTED CEILING PLAN AND CEILING DETAILS
SCALE: 1/4"=1'-0"

© 2020 RealPage, Inc.
All trademarks and
copyrights are
properties of their
respective owners

IFC Set 7.18.2022

 REALPAGE
Outperform

Office & Amenity
Layouts

August 9, 2022

VVD.i2